

To Adamstown

Dublin - Galway Rail - Line

ESB pylons to be removed from site and services diverted - as per approved ESB planning application

Area of Structure to be demolished (see drawing 6268-P-010)

Area of Works permitted under 'SDZ 20A-0021'

existing pedestrian/cycle connection over rail-line

Haydens Lane

Haydens Lane

R120 (NEWCASTLE ROAD)

R120 (NEWCASTLE ROAD)

IRISH GRID COORDINATES OF SITE:
EASTINGS (x): 303064
NORTHINGS (y): 232515


Legend:

- Proposed application boundary
- Extent of lands in client ownership
- Extent of permitted lands in client ownership

O.S. reference:
3260-A
3620-15

DIGITALLY REPRODUCED UNDER LICENCE NUMBER: CYAL50177125 © ORDNANCE SURVEY IRELAND / GOVERNMENT OF IRELAND.

Subject Site Keyplan (NTS)

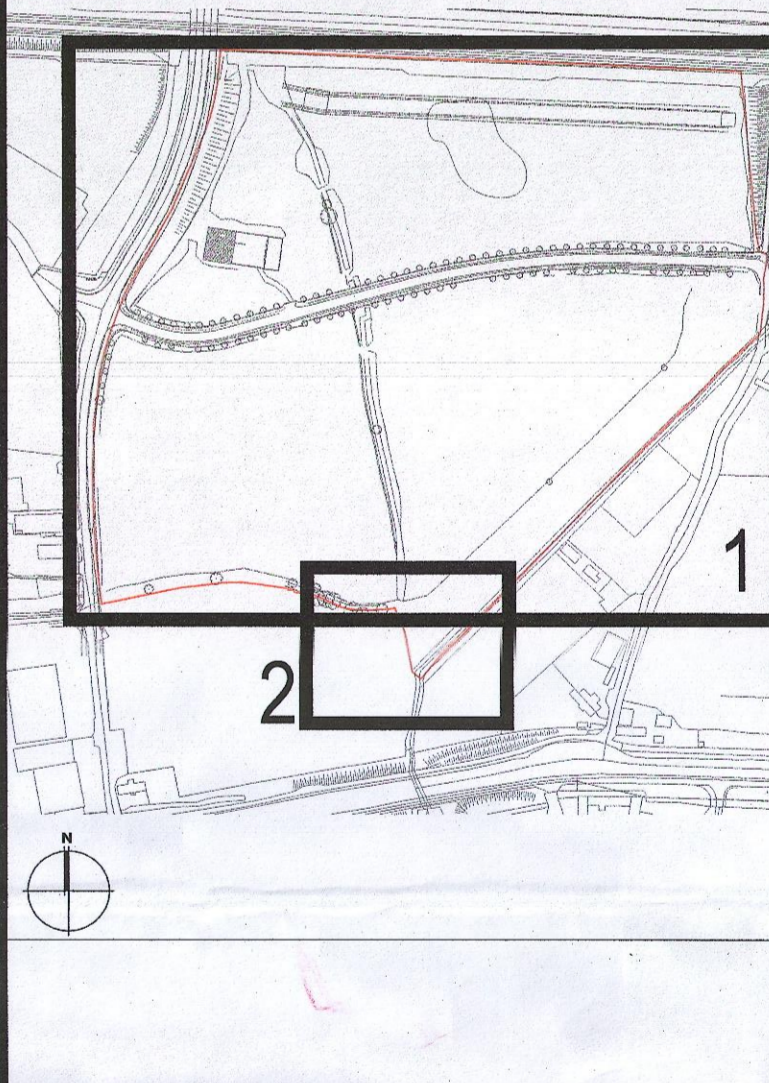

- Notes:**
1. Copyright Reserved
 2. Work to be done on site only. Do not use drawings.
 3. The contractor is responsible for checking all levels and dimensions on site and shall refer all discrepancies to the Architect.
 4. Where appropriate, for details of a structure, or mechanical and electrical details, see Engineers drawings.
 5. Proprietors shall be held to strict compliance with manufacturer's instructions.
 6. Sites of proximity shall be checked with manufacturer.
 7. The contractor shall be responsible for the coordination of structure, services and services.

Issue	SB/DA	Progress
Planning Application		
Fire Cert		
Disability Cert		
Tender		
Construction		
As Built		
Information Only		

No.	Date	Revision	By	Check
01	27/01/23	Planning Application		

Project: Adamstown Extension - Clonburris SDZ Residential Development

Drawing Title: Existing Site Plan

Drawing No: 6268-P-002

Scale: 1:1000 @ A0

Rev: 01

Drawn: RT

Date: July 23

bkd architects
BURKE KENNEDY DOYLE

6-7 FARRINGTON TERRACE, DUBLIN 2, IRELAND
T: +353 1 410 1401 F: +353 1 410 1404
www.bkd.ie