


**TYPE L3 - 2 Bed
Level 00-01- Duplex**


DUPLEX TYPE L	60.0m ²
Ground floor area	53.1m ²
First floor area	113.1m ²
Total Floor Area (2-bed unit):	

**TYPE M3 - 3 Bed
Level 02-03-Duplex**


DUPLEX TYPE M	111.0m ²
First floor (stair)	62.3m ²
Second floor area	62.3m ²
Third floor area	62.3m ²
Total Floor Area (3-bed unit):	135.6m ²

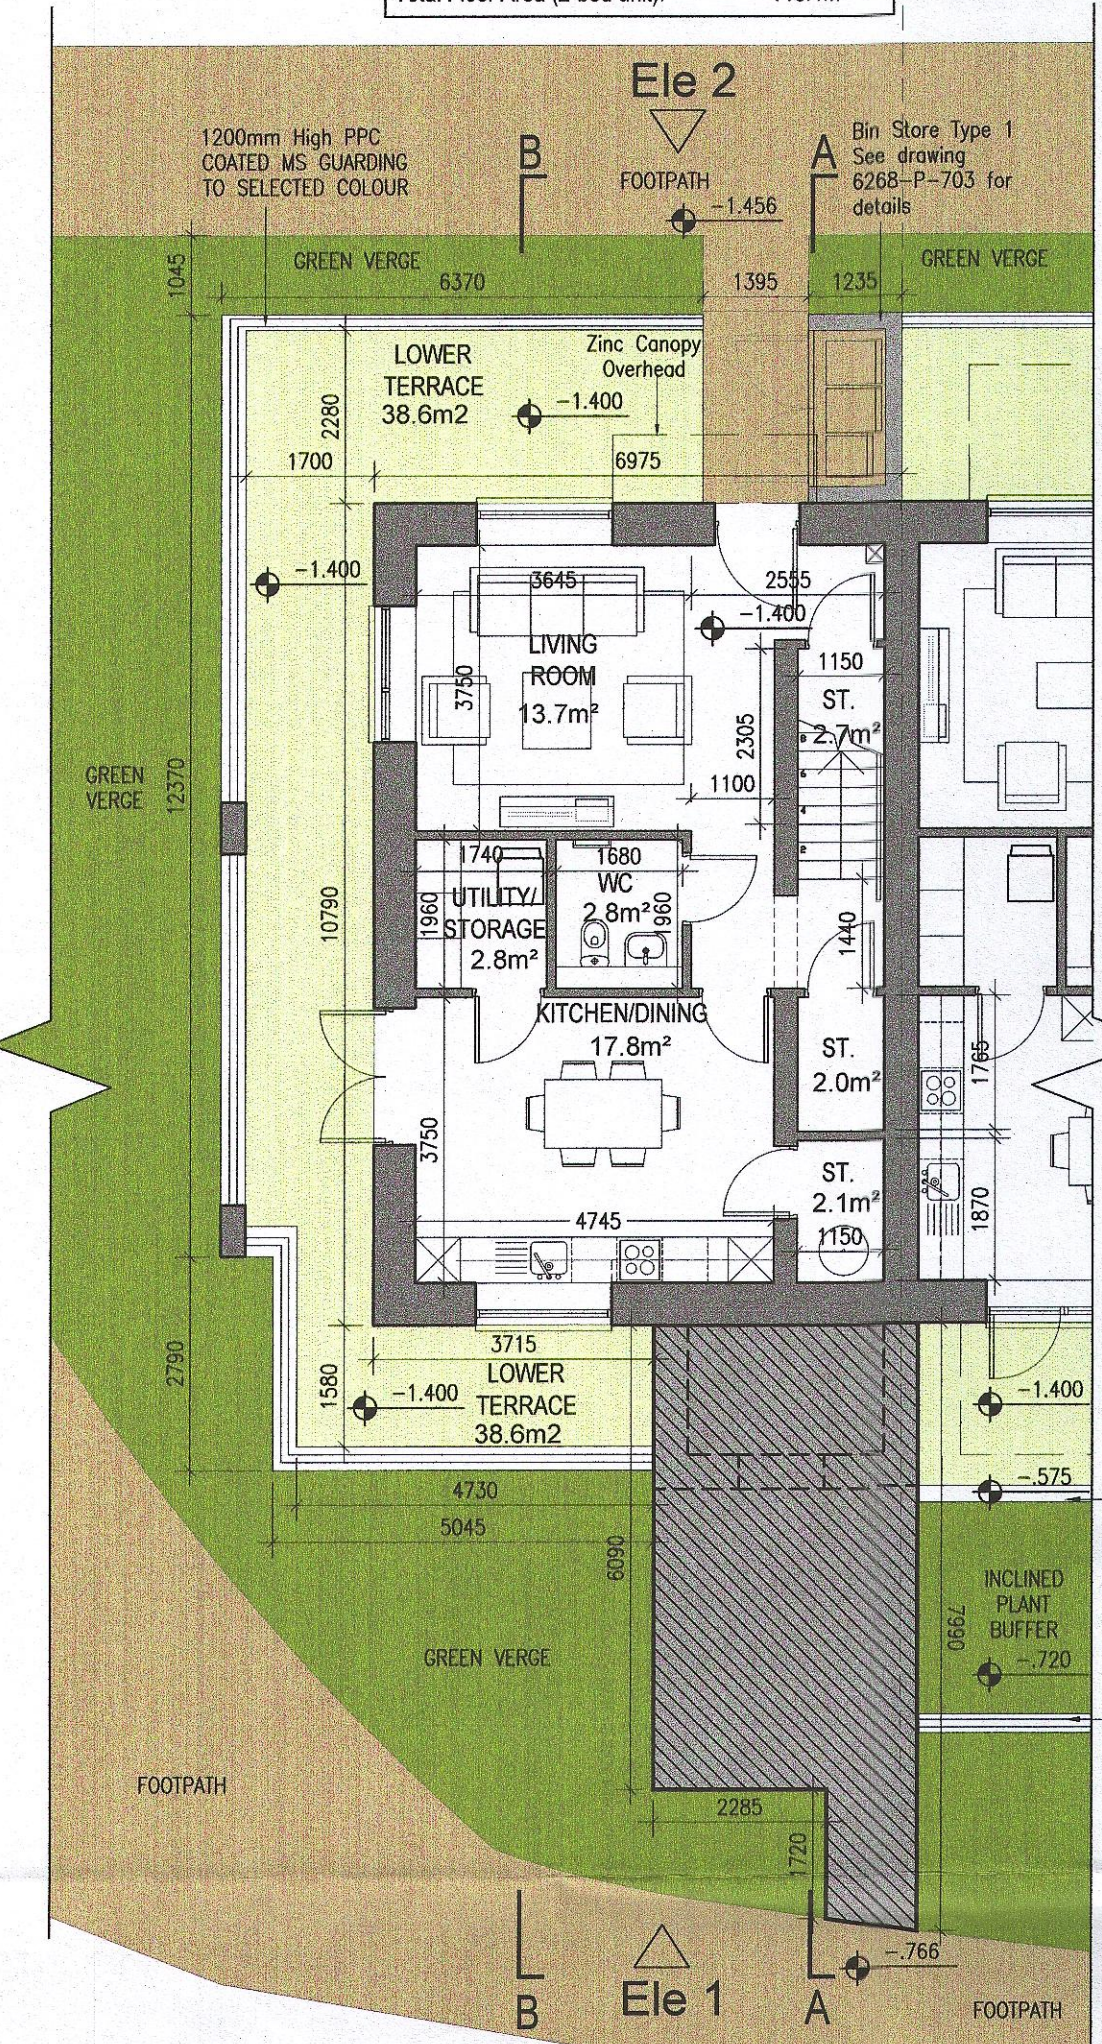


01 Ground Floor Plan

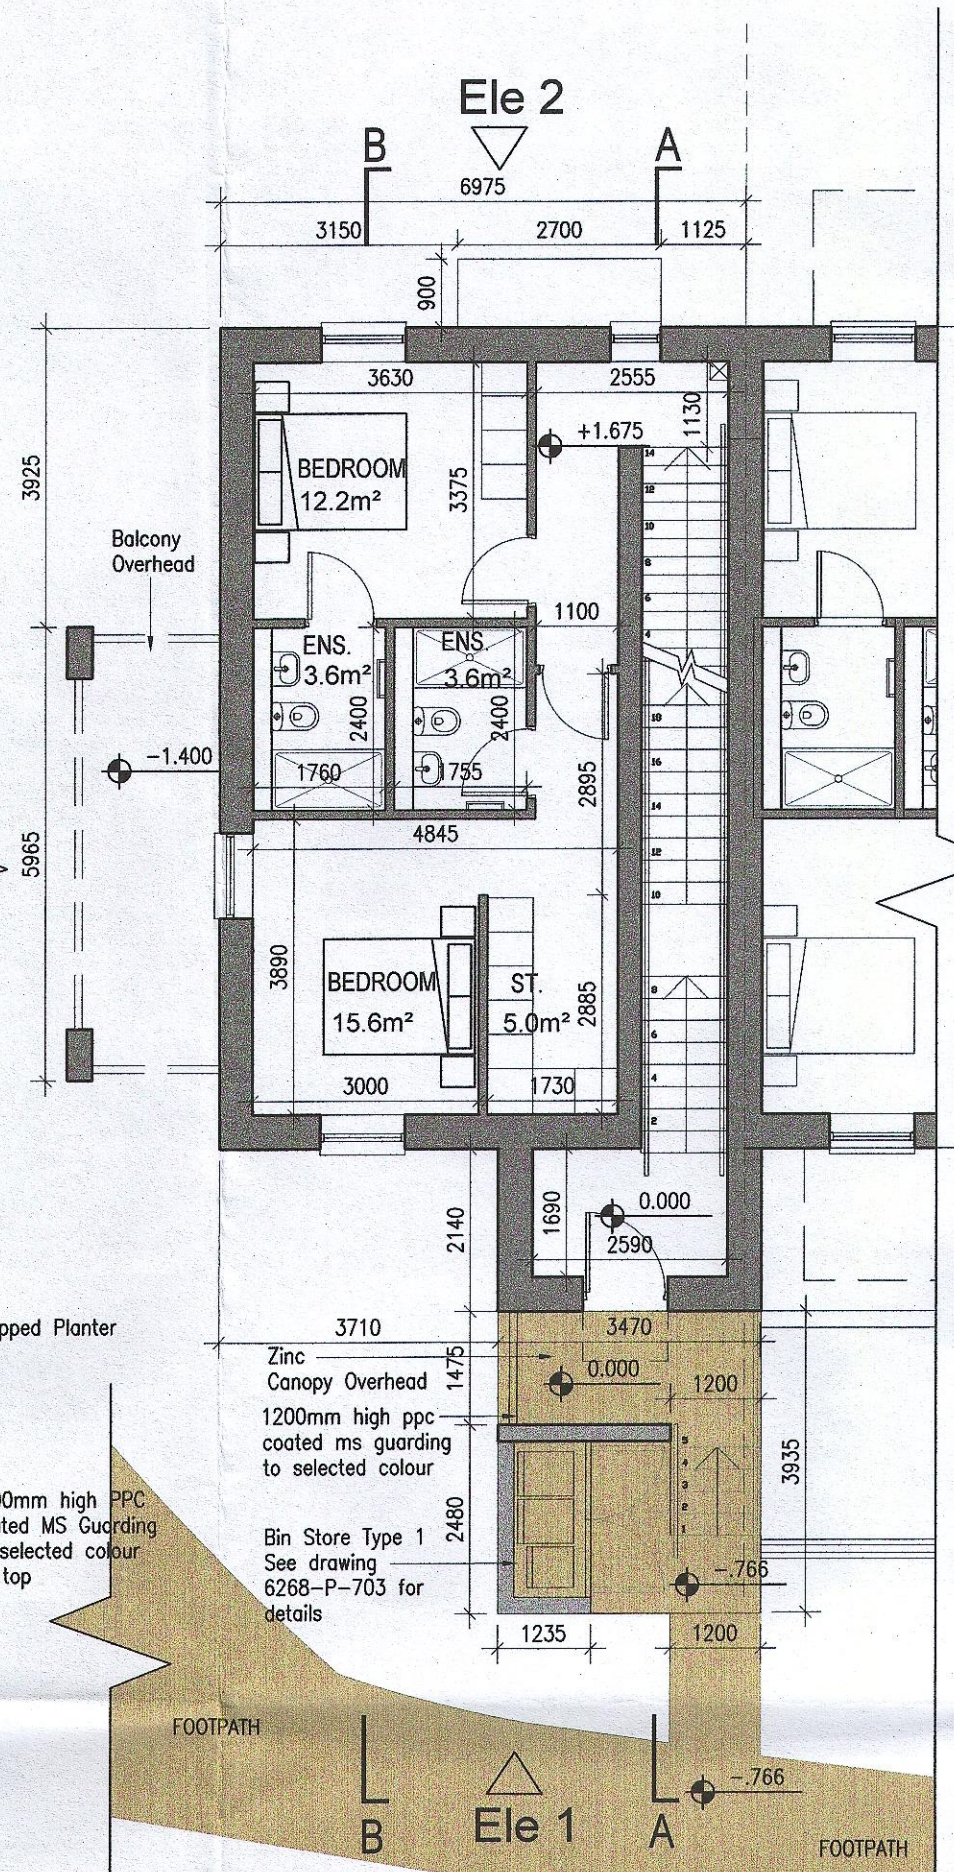


02 First Floor Plan

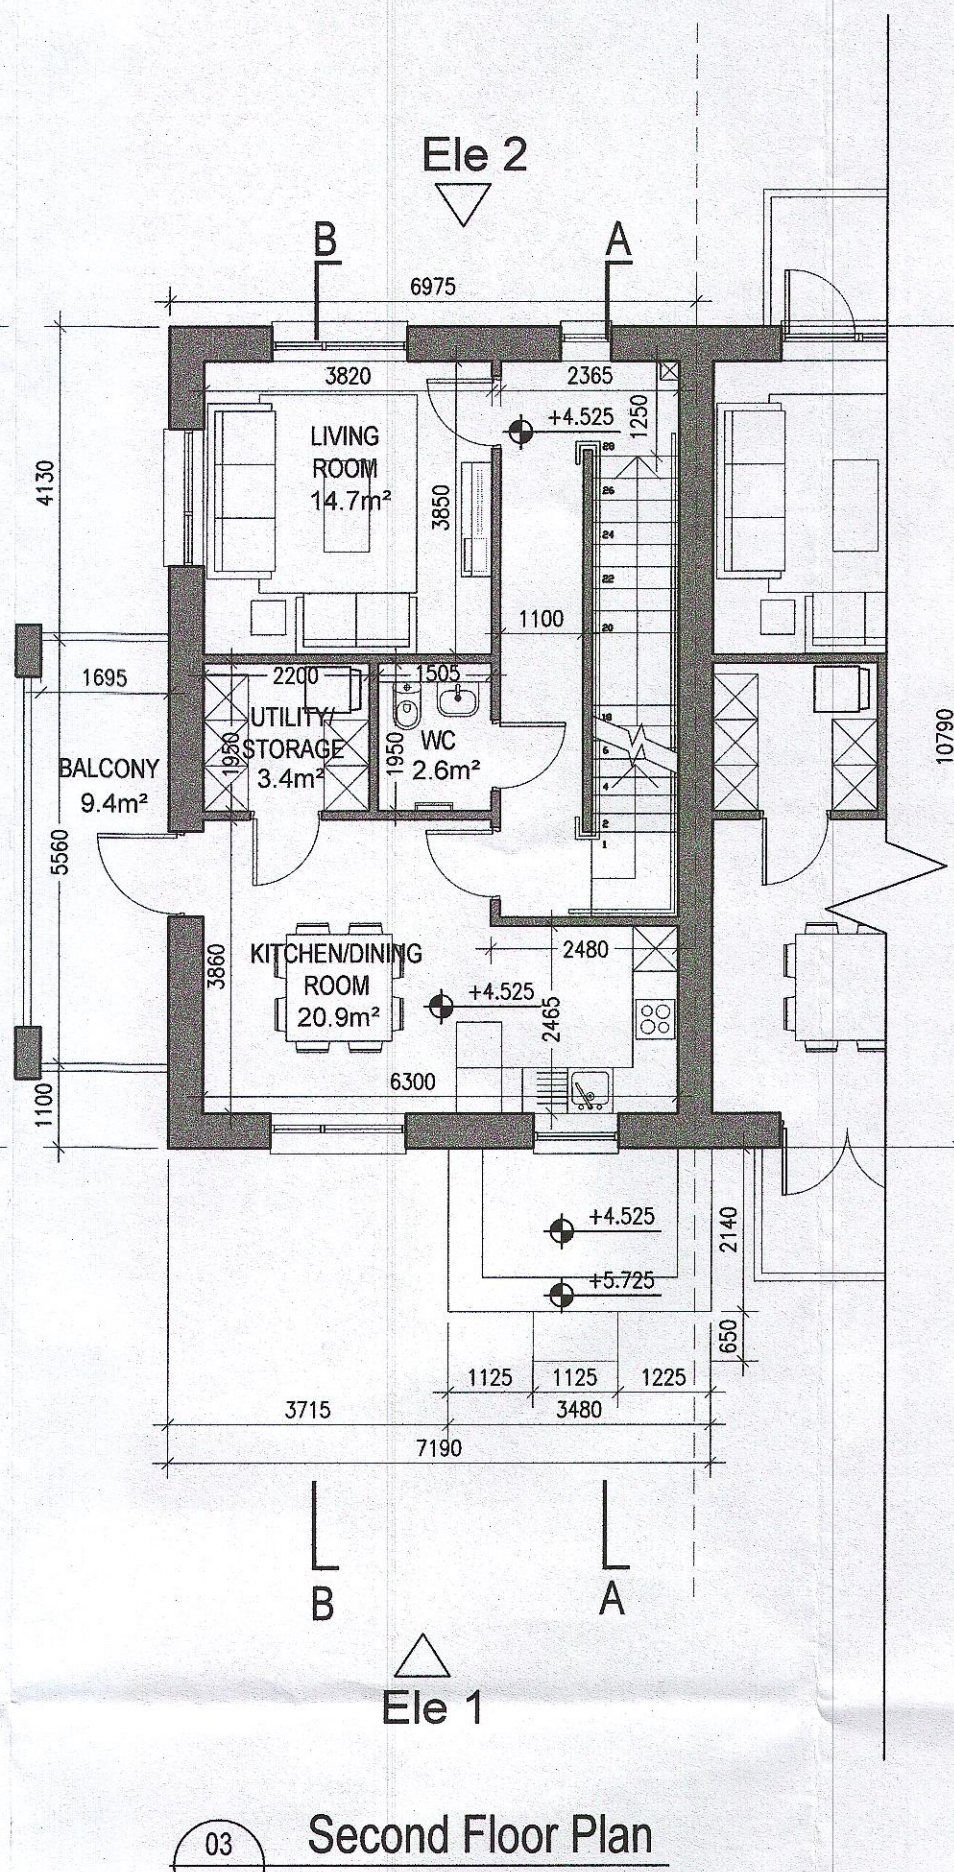


03 Second Floor Plan

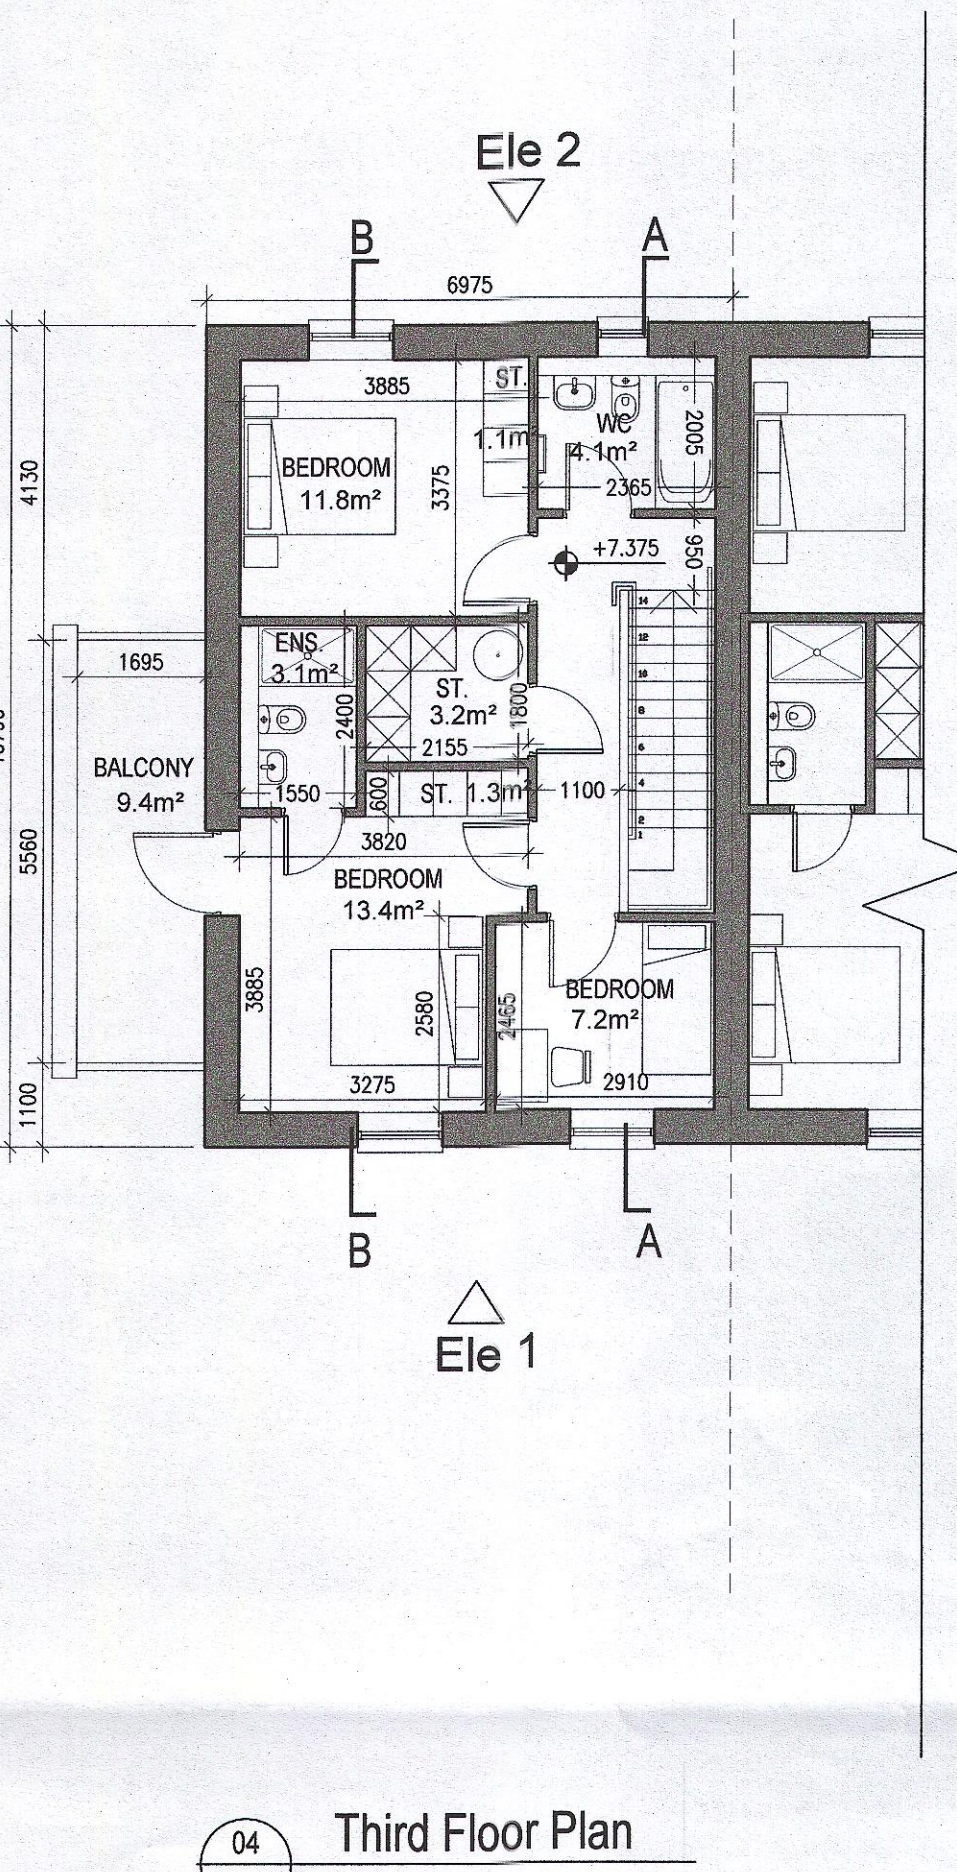


04 Third Floor Plan

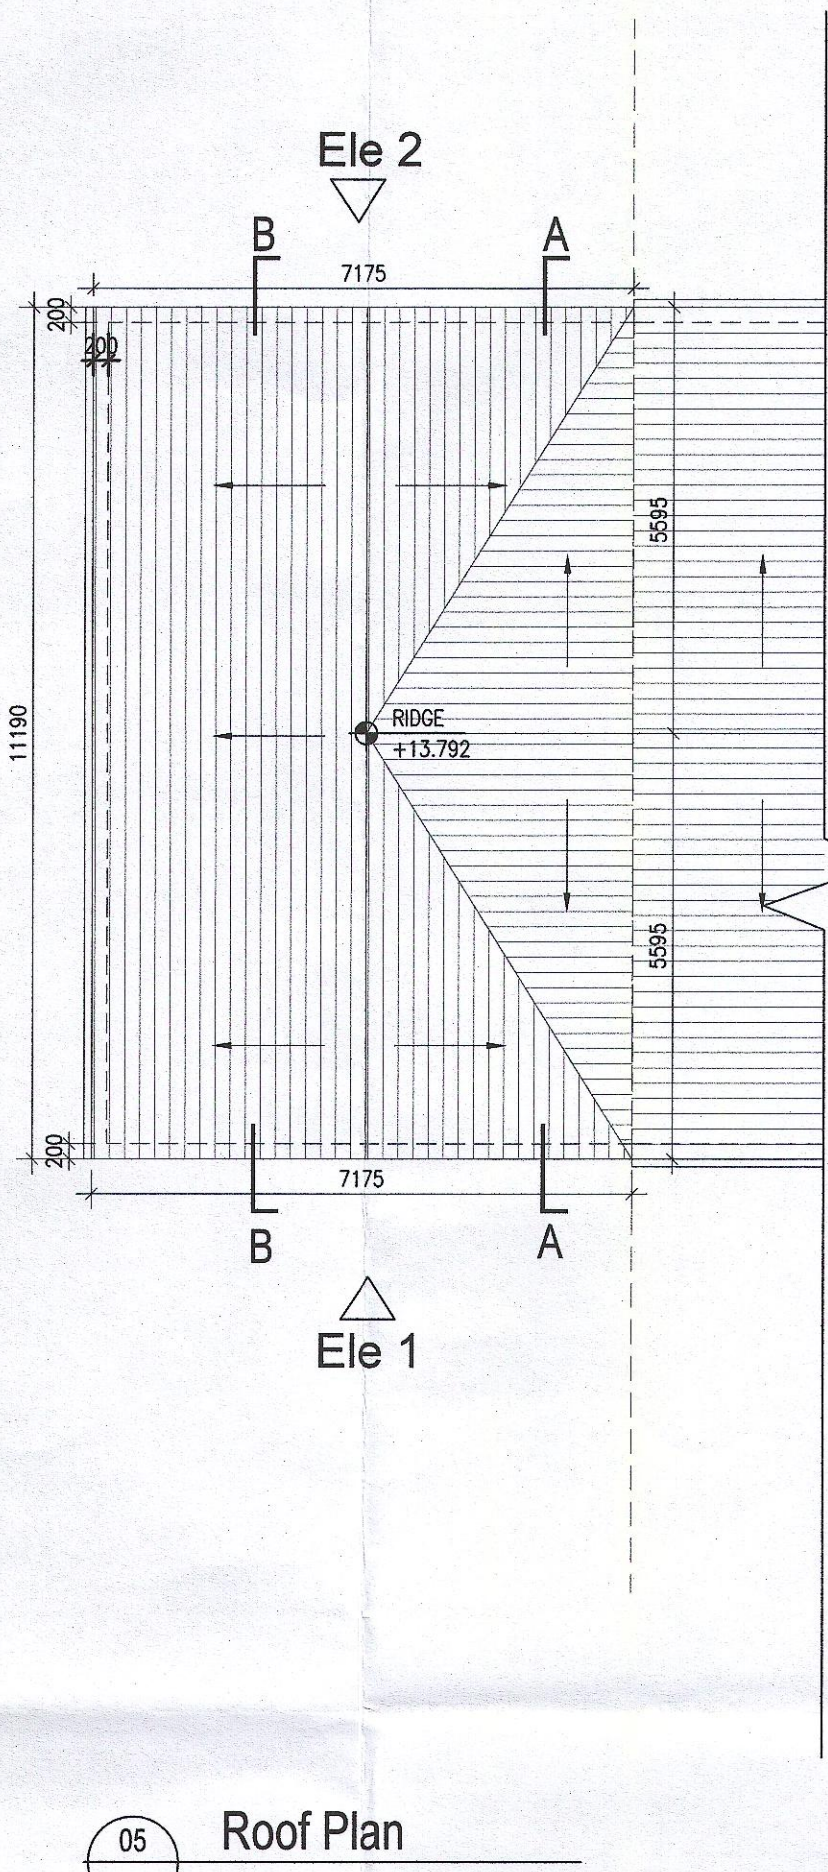


05 Roof Plan

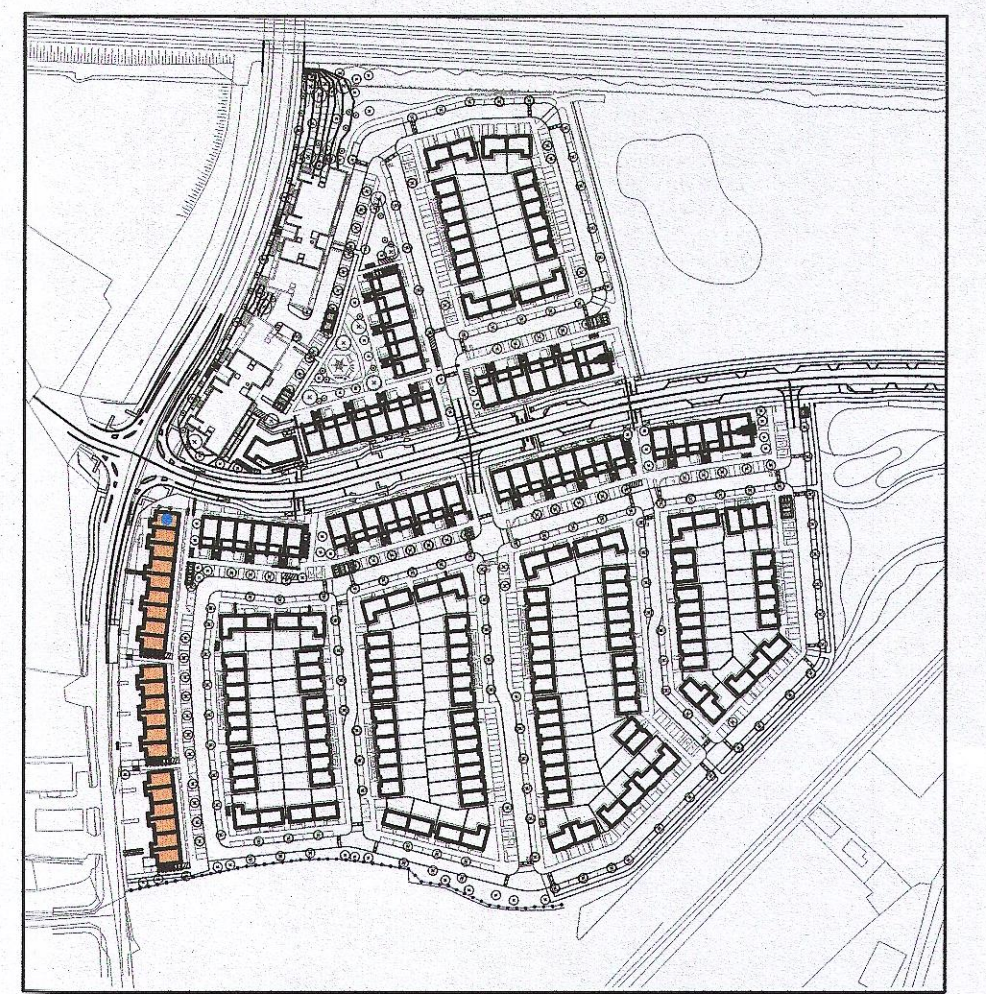

Indicates unit locations
KEY PLAN [NTS]

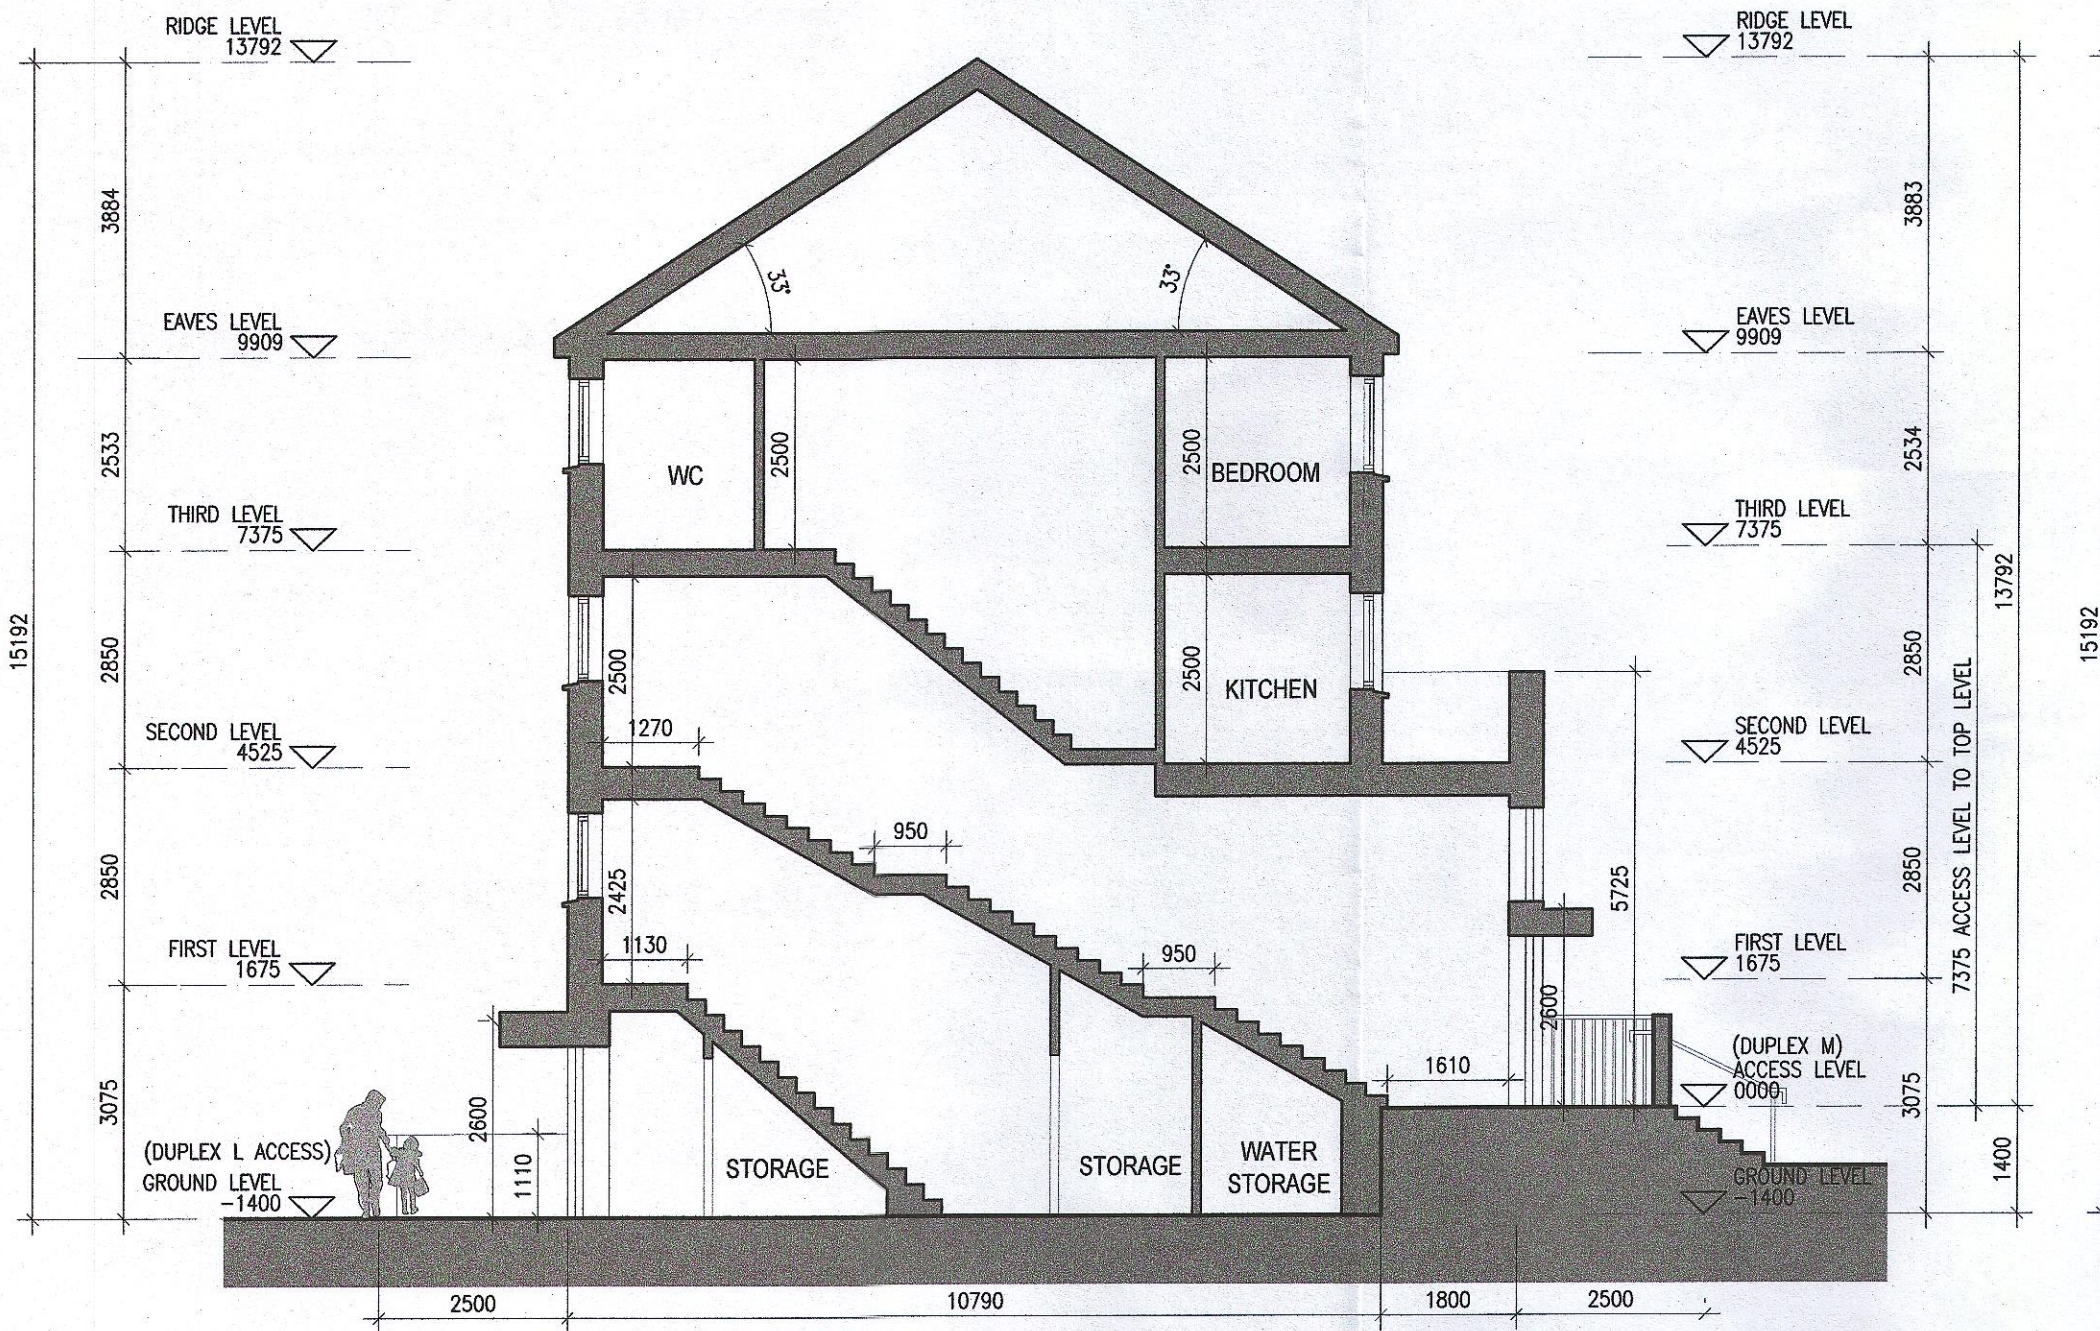

06 Typical Section A-A
1:100@A1

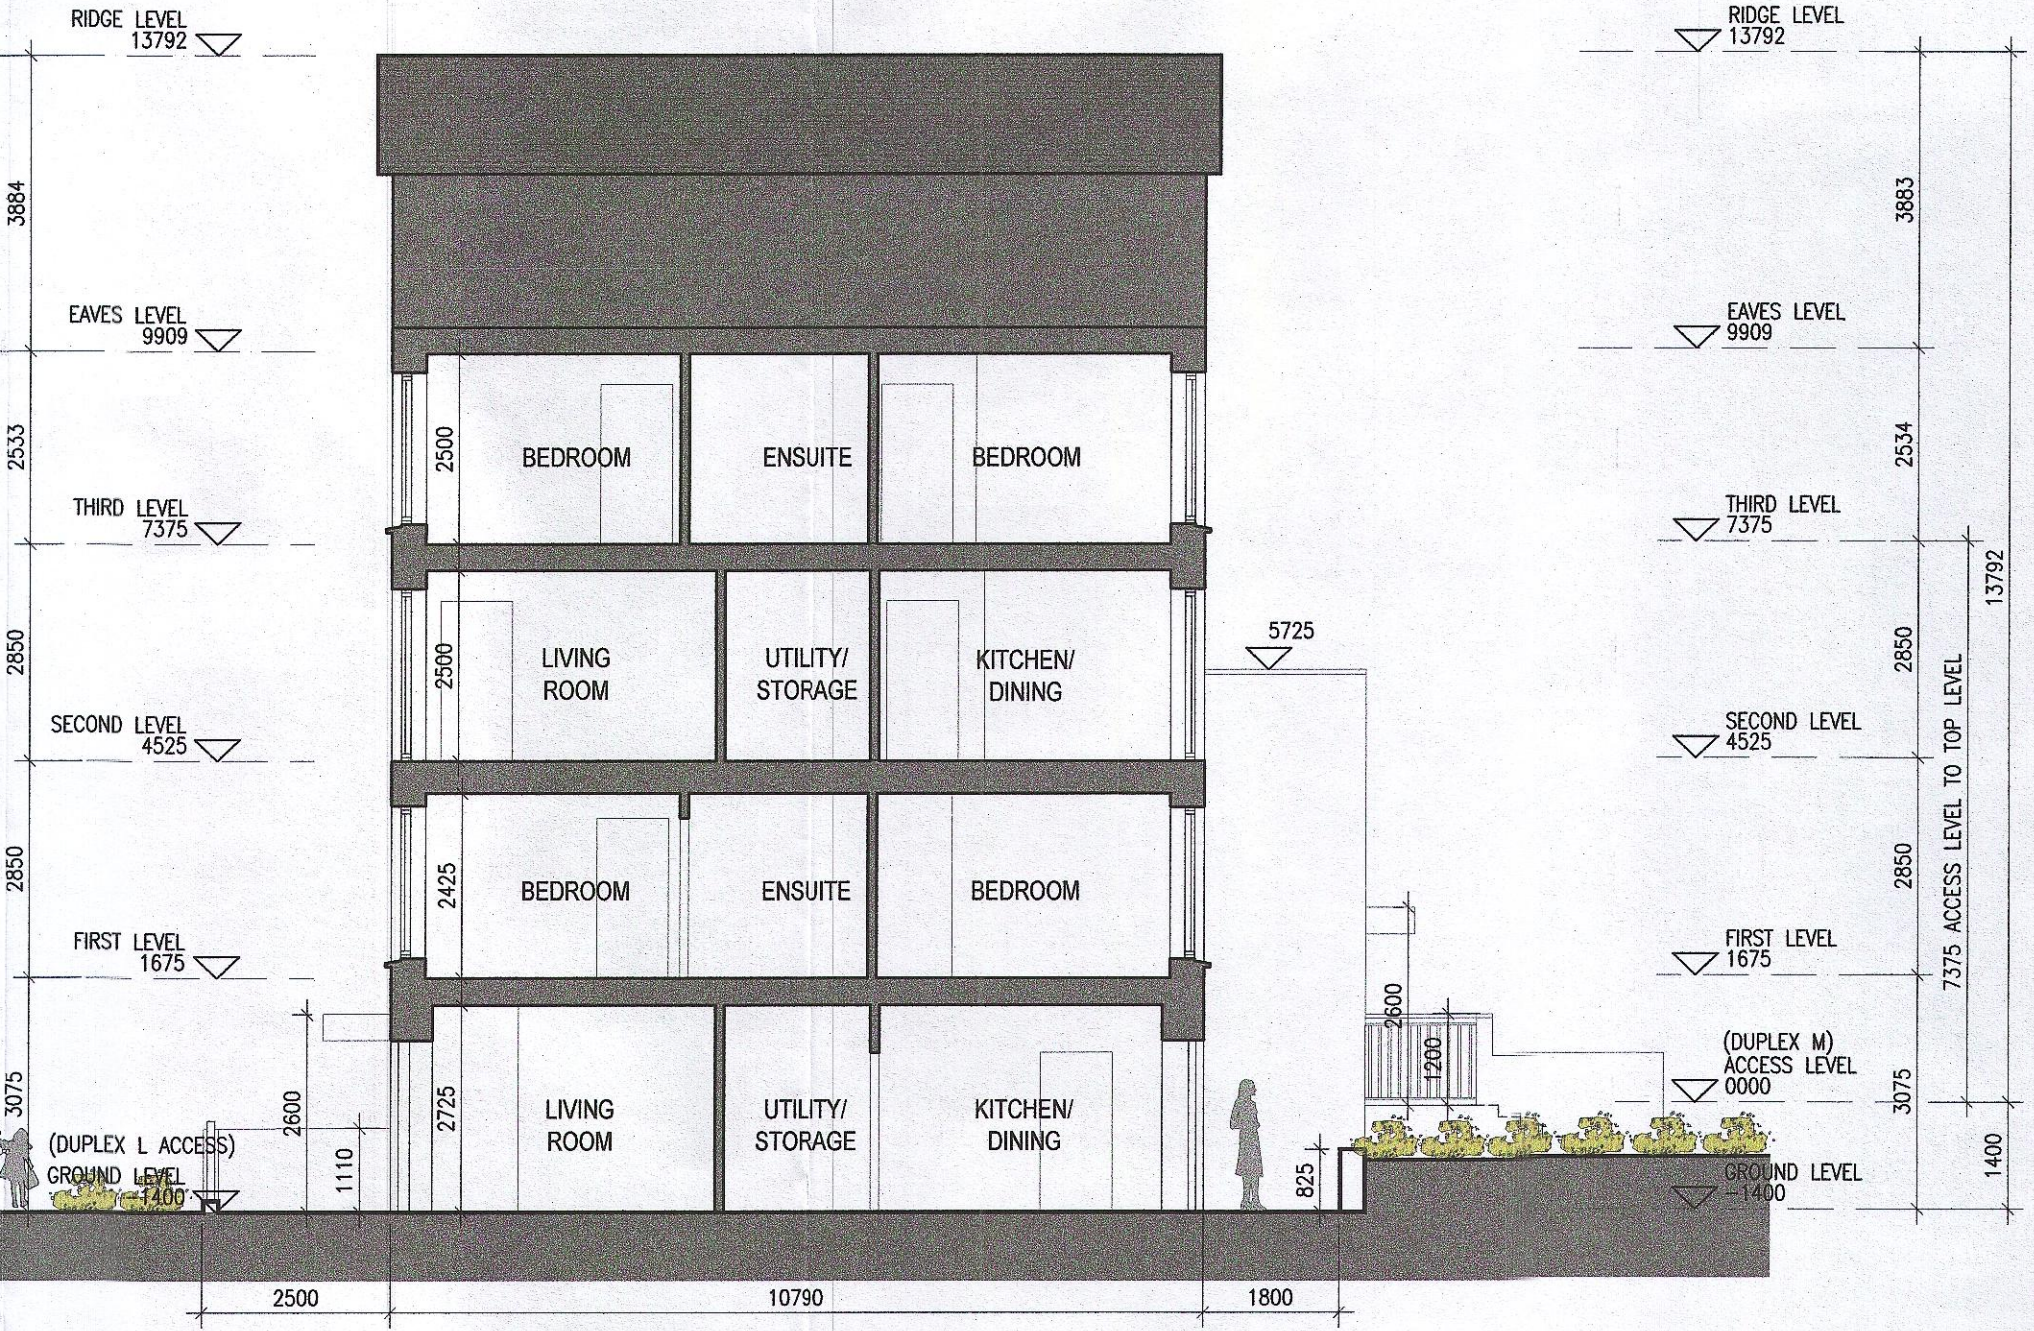

07 Typical Section B-B
1:100@A1

MATERIAL CODE LEGEND

- 01 - BUFF BRICK - STANDARD BOND - LIGHT APPROVED TONE
- 02 - BUFF BRICK - FEATURE BOND - LIGHT APPROVED TONE
- 03 - BUFF BRICK - STANDARD BOND - BROWN APPROVED TONE
- 04 - BUFF BRICK - FEATURE BOND - BROWN APPROVED TONE
- 05 - SELF COLOURED RENDER - LIGHT APPROVED TONE
- 06 - SELF COLOURED RENDER - DARK APPROVED TONE
- 07 - CONCRETE ROOF TILES - DARK APPROVED TONE
- 08 - POWDERCOATED METALWORK OR uPVC - DARK APPROVED RAL COLOUR
- 09 - POWDERCOATED METAL SCREENING - DARK APPROVED RAL COLOUR
- 10 - CLEAR GLAZING WITH DARK APPROVED RAL COLOUR FRAMING
- 11 - OPACIFIED GLAZING WITH DARK APPROVED RAL COLOUR FRAMING

EXTERNAL FINISHES

WALLS: PAINTED SAND / CEMENT RENDER OR PROPRIETARY PRECOLOURED RENDER FINISH SELECTED BRICKWORK WHERE INDICATED ON DRAWINGS

WINDOWS: SELECTED PROPRIETARY DOUBLE / TRIPLE GLAZED WINDOW SYSTEM WITH FRAMES TO APPROVED COLOUR OBTAINED TO BATHROOMS AND EN-SUITES.

DOORS: SELECTED PROPRIETARY DOORS AND GLAZED SIDE SCREENS TO APPROVED COLOUR.

RAINWATER GOODS: uPVC OR POWDER COATED METAL GUTTERS AND RAINWATER PIPES TO SELECTED COLOUR.

MAIN ROOF: CONCRETE ROOF TILES IN SELECTED COLOUR.

LOW LEVEL PROJECTION: ZINC CANOPY TO ENTRANCE OF UNITS

OTHER ITEMS: uPVC OR POWDER COATED METAL FASCIAS, SOFFITS AND BARGE BOARDS PAINTED MILDSTEEL RAILINGS AND BALUSTRADES

REFER TO LANDSCAPE ARCHITECT'S DRAWINGS FOR ALL LANDSCAPING DETAILS

Notes

- Copyright Reserved
- Work to figure dimensions only. Do not scale drawing
- The contractor is responsible for checking all levels and dimensions on site and shall refer all discrepancies to the Architect
- Where appropriate, for details of r.c. structure, or mechanical and electrical details, see Engineers drawings
- Proprietary items shall be fixed in strict accordance with manufacturers instructions.
- Size of proprietary items shall be checked with manufacturer.
- The contractor shall be responsible for the coordination of structure, finishes and services.

Issue Status

Progress	
Planning Application	
Fire Cert	
Disability Cert	
Tender	
Construction	
As Built	
Information Only	

No.	Date	Revision	Initials
01	27/01/23	Planning Application	AM

Project Adamstown Extension - Clonburris SDZ Residential Development

Drawing Title Duplex Type L3M3 - (end) - Plans & Section

Drawing No 6268-P-214

Scale 1:100 @ A1 **Rev** 01 **Drawn** SH **Date** JAN/2023

6-7 HARCOURT TERRACE, DUBLIN 2, IRELAND
T +353-1-616 2400 F +353-1-676 7365
www.bkd.ie

bkdarchitects
BURKE-KENNEDY DOYLE