



UNIT TYPE B2.1
2 Bed Unit - Floor Area: 81.53m²

	REQUIRED (m ²)	PROVIDED (m ²)
STORAGE SPACE	6.0	6.1
PRIVATE AMENITY SPACE	7.0	7.1
AGGREGATE BEDROOM AREA	24.4	24.6
AGGREGATE KITCHEN / LIVING / DINING	30.0	30.1

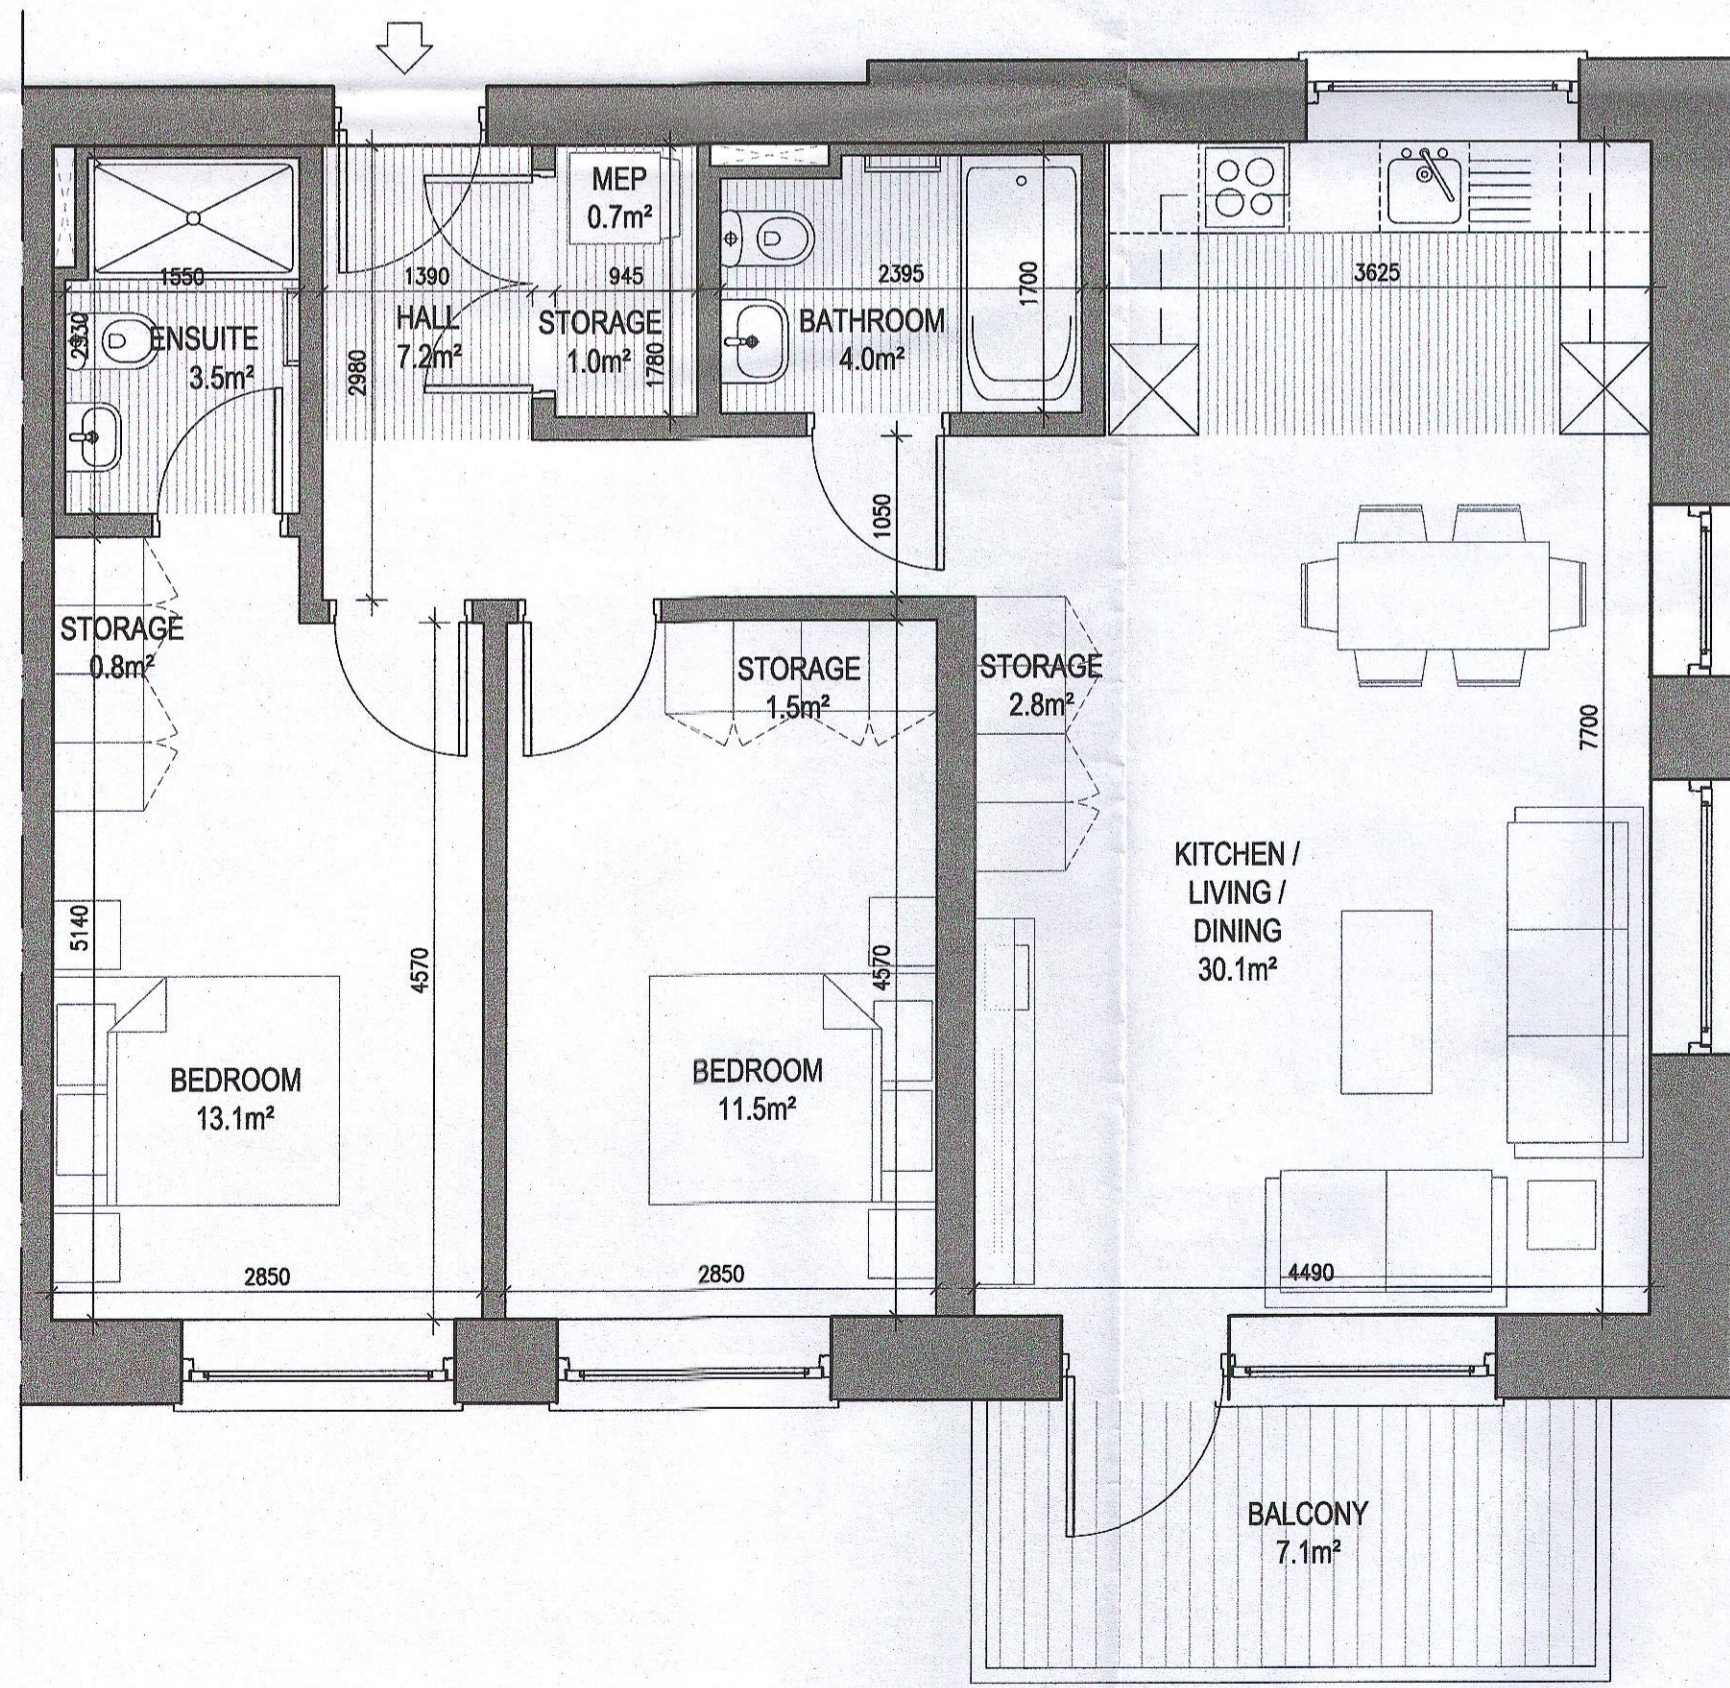


UNIT TYPE B2.3
2 Bed Unit - Floor Area: 81.53m²

	REQUIRED (m ²)	PROVIDED (m ²)
STORAGE SPACE	6.0	6.1
PRIVATE AMENITY SPACE	7.0	7.1
AGGREGATE BEDROOM AREA	24.4	24.6
AGGREGATE KITCHEN / LIVING / DINING	30.0	30.1

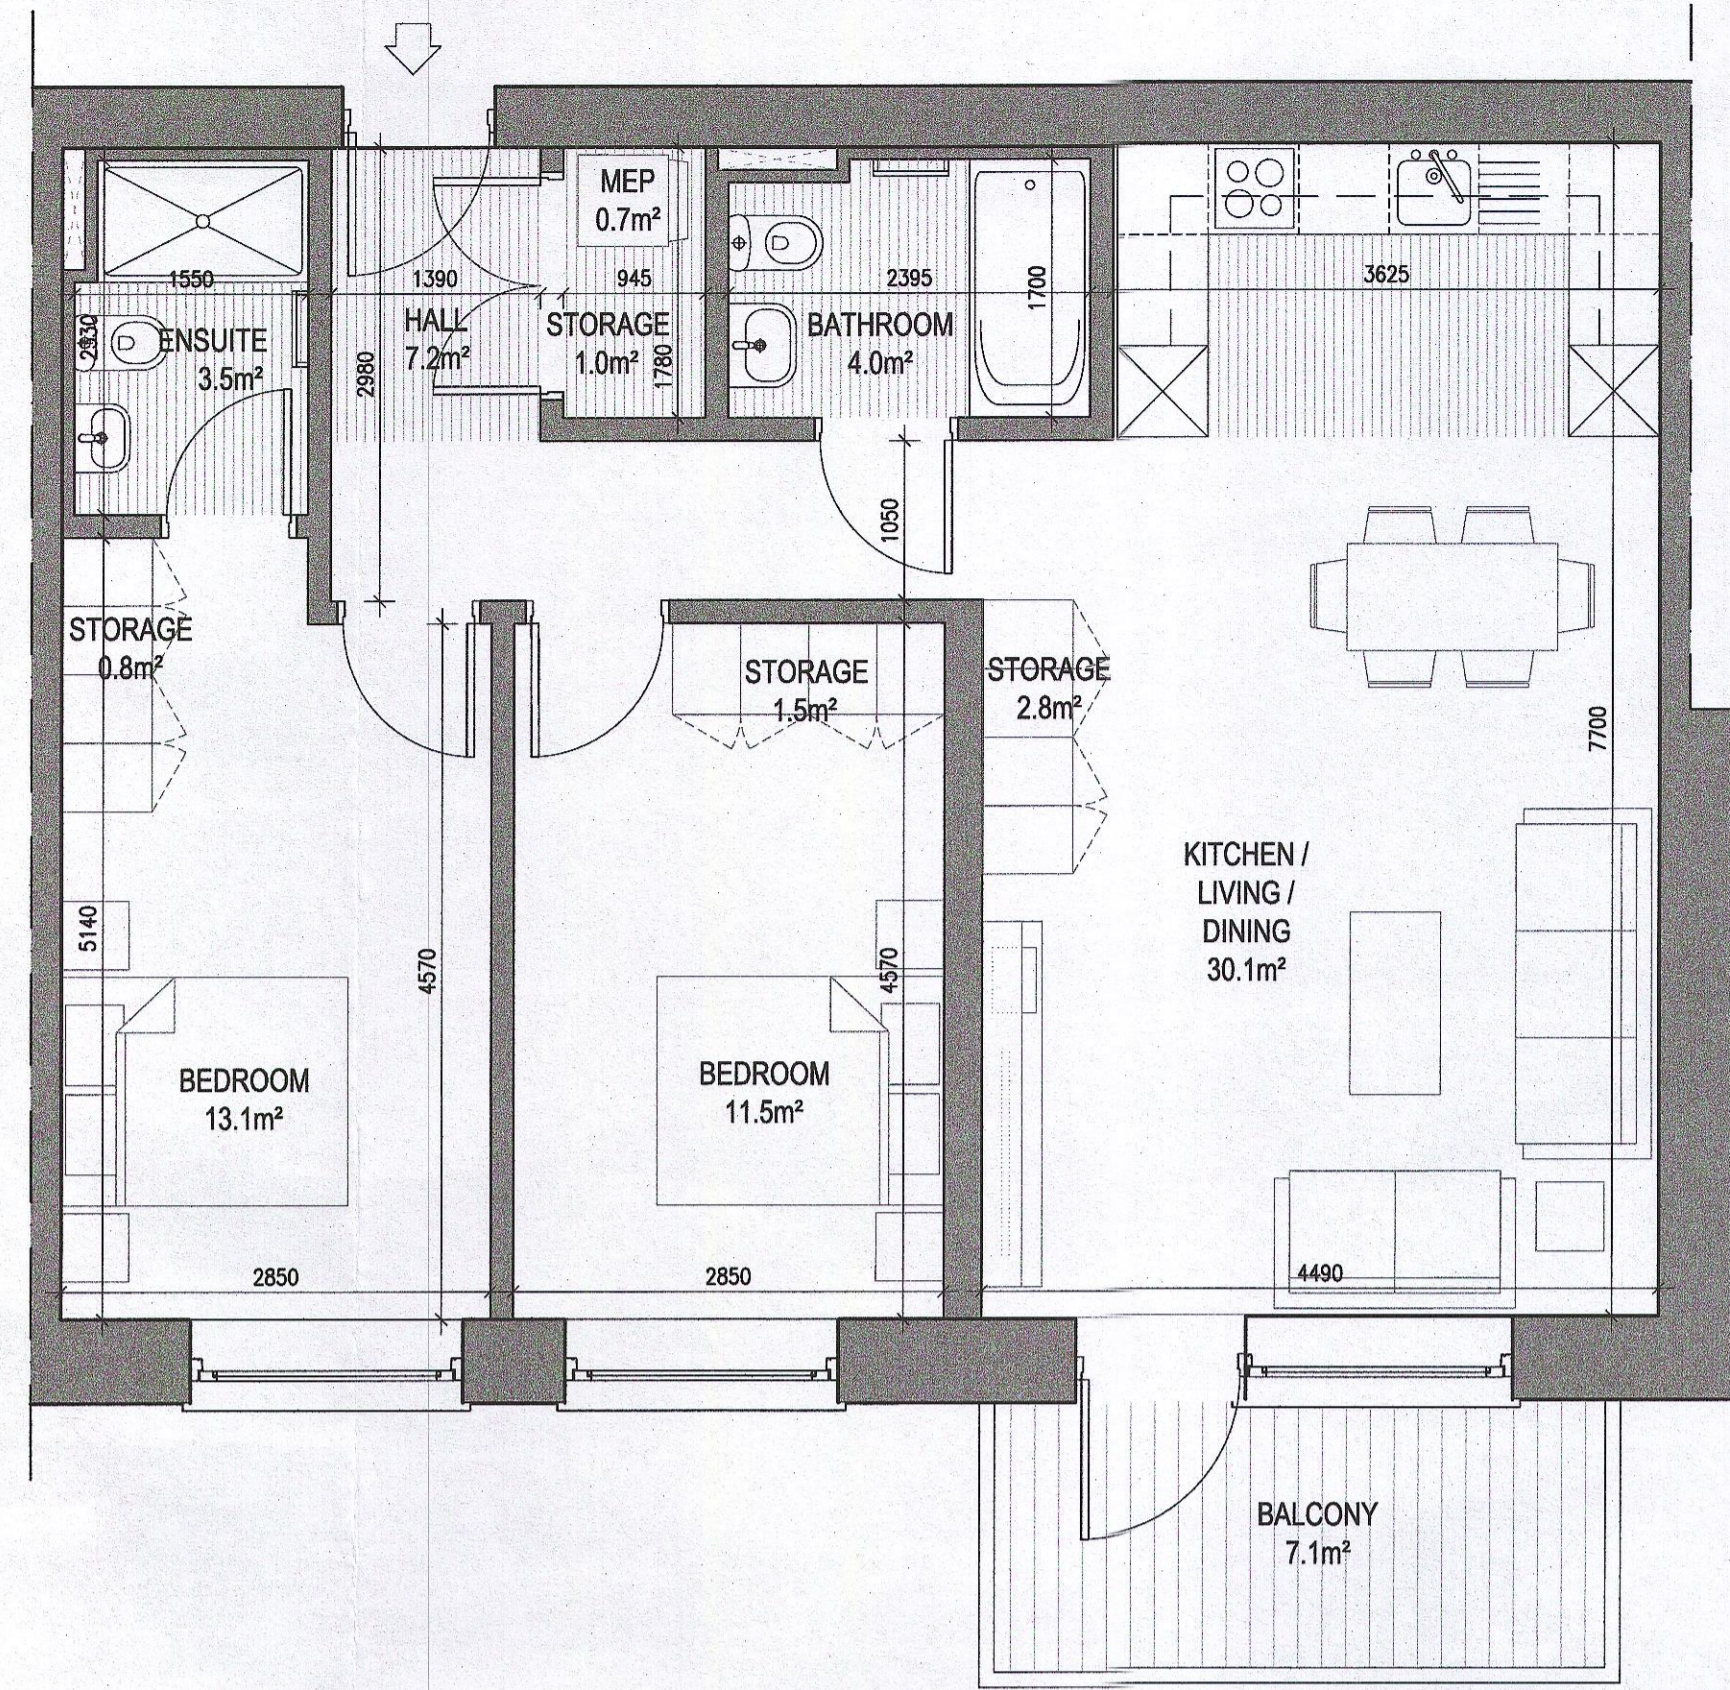


UNIT TYPE B2.2
2 Bed Unit - Floor Area: 81.53m²

	REQUIRED (m ²)	PROVIDED (m ²)
STORAGE SPACE	6.0	6.1
PRIVATE AMENITY SPACE	7.0	7.1
AGGREGATE BEDROOM AREA	24.4	24.6
AGGREGATE KITCHEN / LIVING / DINING	30.0	30.1

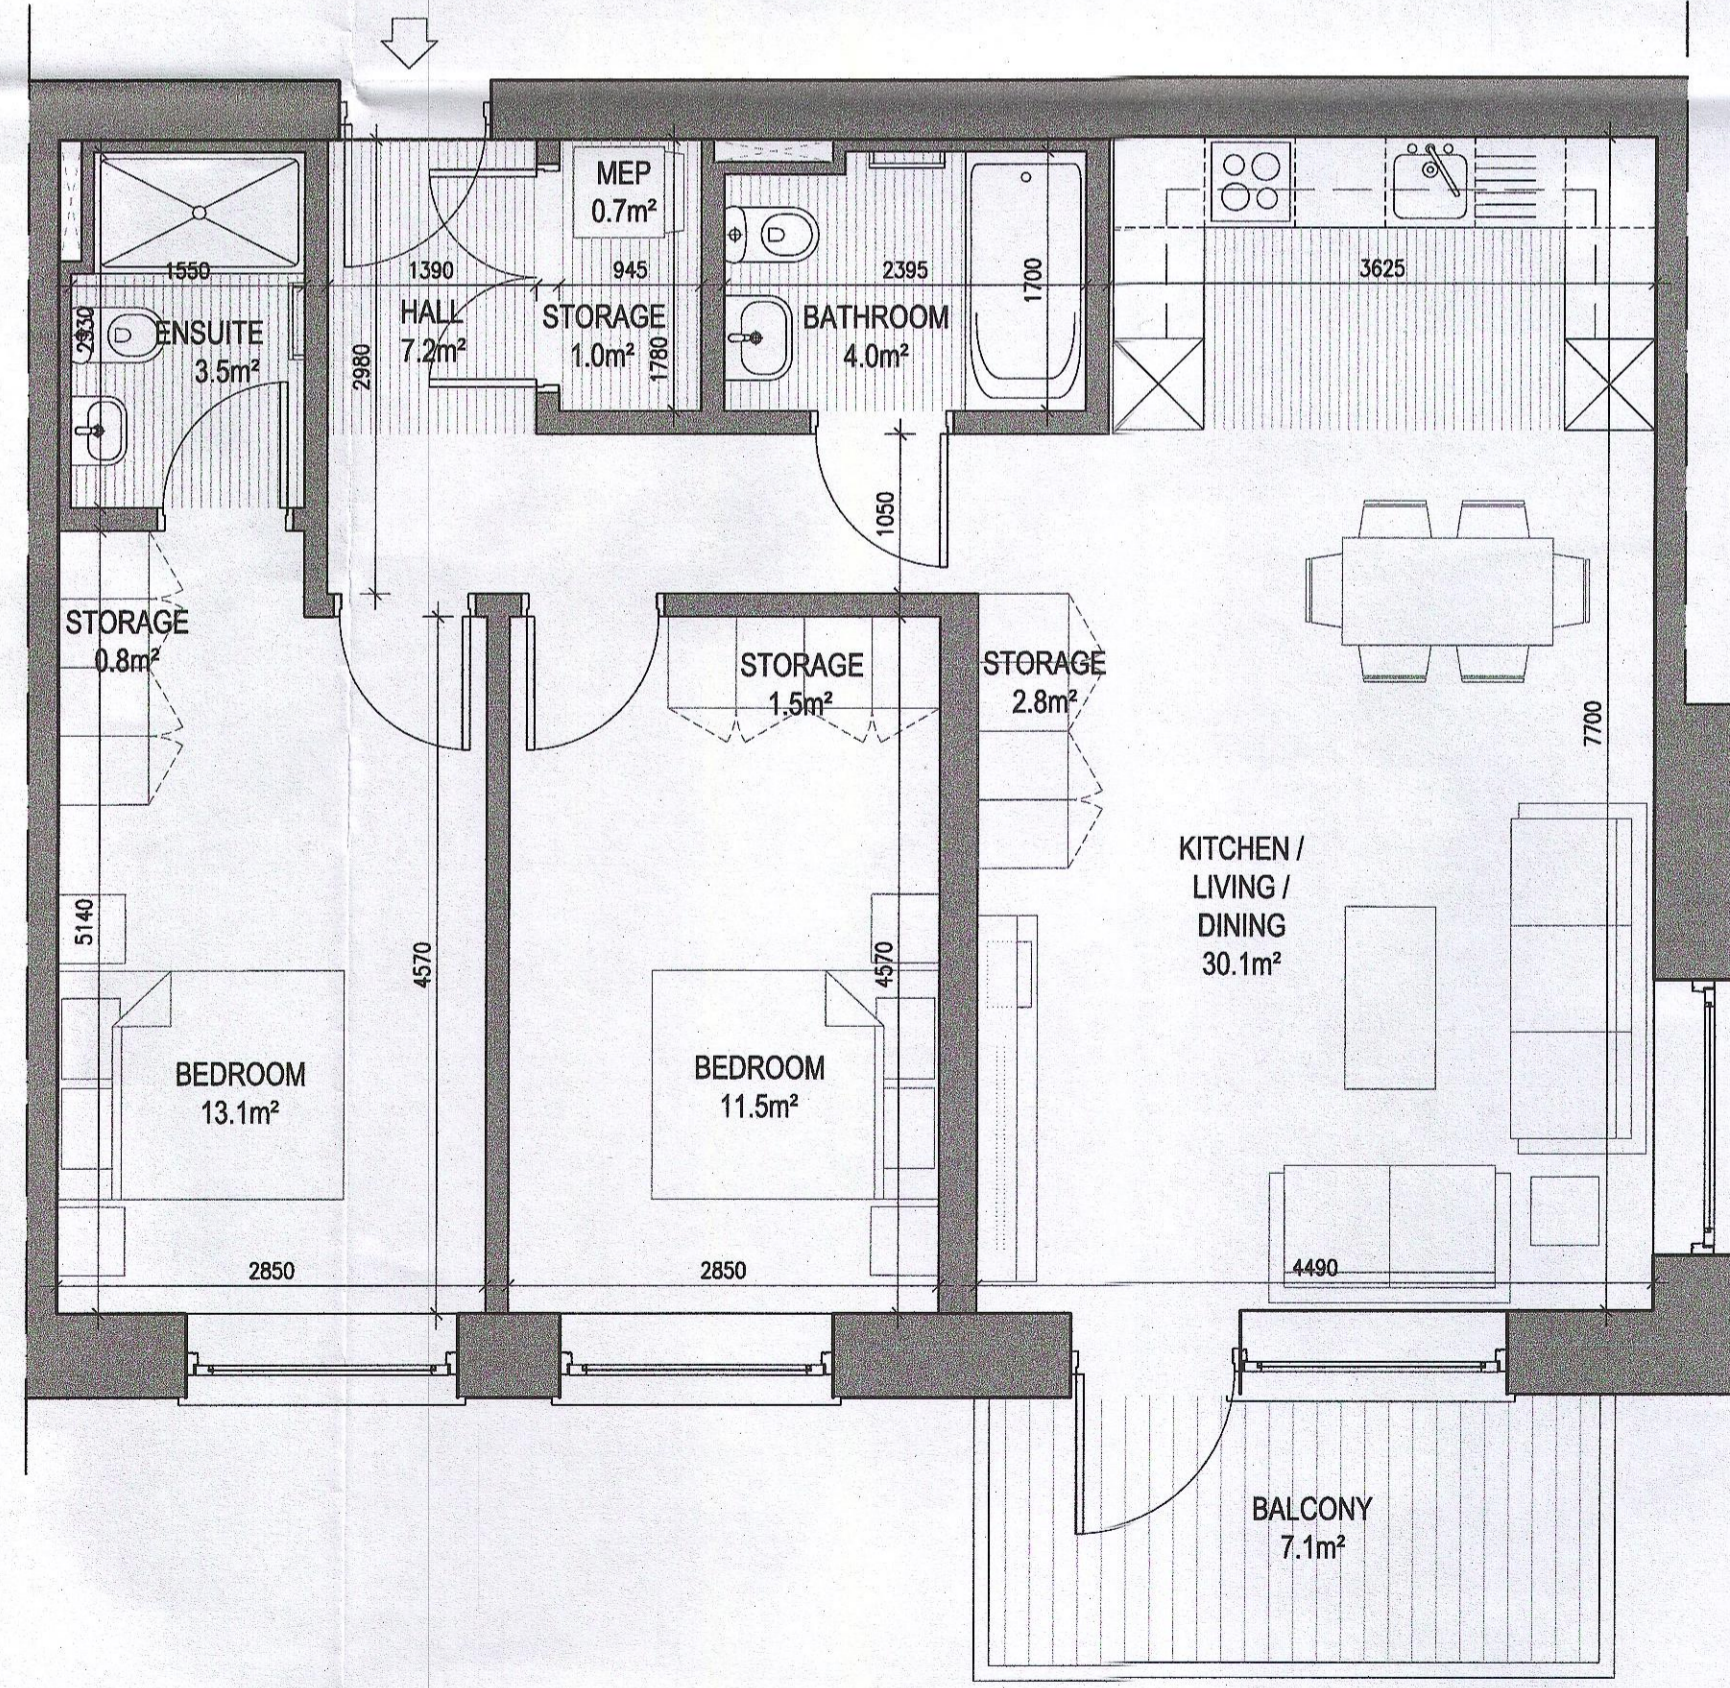

UNIT TYPE B2.4
2 Bed Unit - Floor Area: 81.53m²

	REQUIRED (m ²)	PROVIDED (m ²)
STORAGE SPACE	6.0	6.1
PRIVATE AMENITY SPACE	7.0	7.1
AGGREGATE BEDROOM AREA	24.4	24.6
AGGREGATE KITCHEN / LIVING / DINING	30.0	30.1

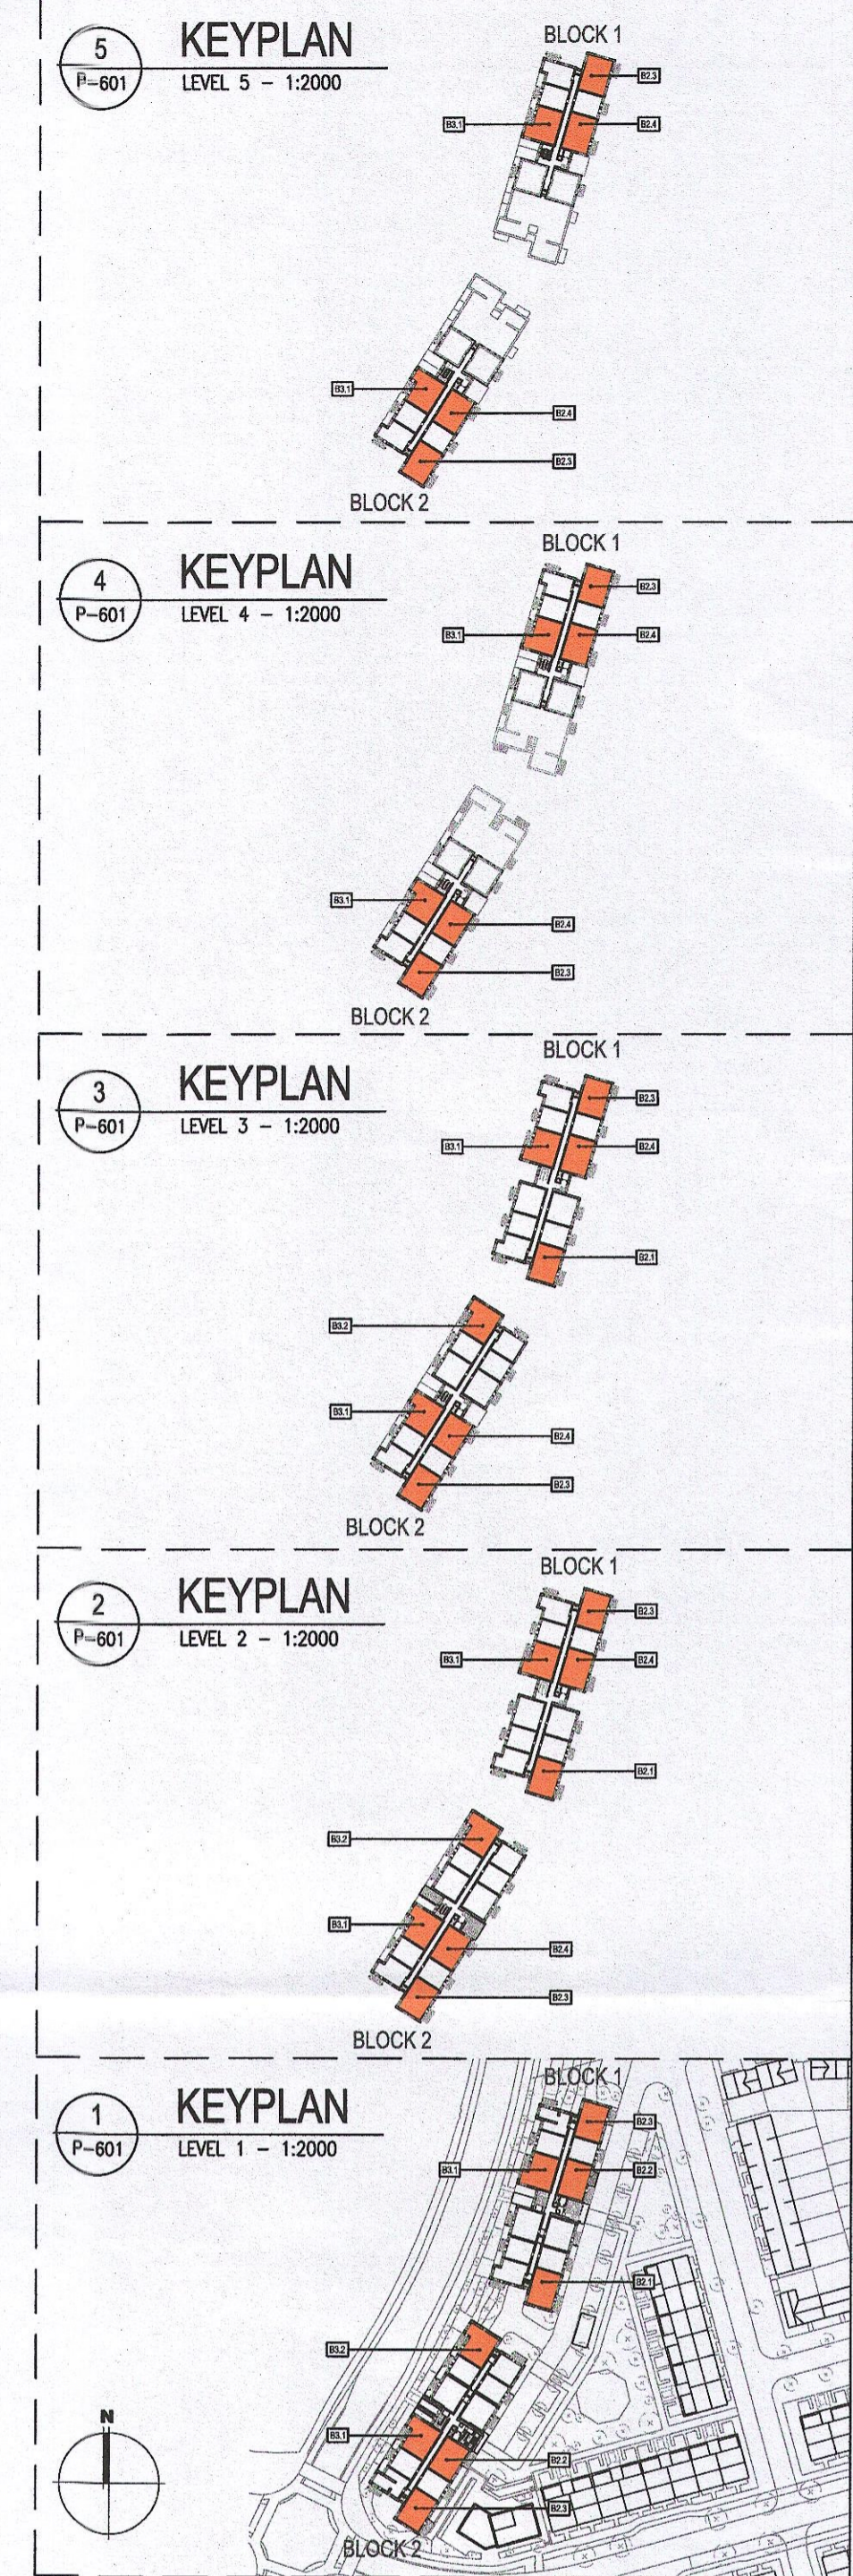

Notes
 1. Copyright Reserved
 2. Work to figured dimensions only. Do not scale drawing.
 3. The contractor is responsible for checking all levels and dimensions on site and shall refer all discrepancies to the Architect.
 4. Where appropriate, for details of r.c. structure, or mechanical and electrical details, see Engineers drawings.
 5. Proprietary items shall be fixed in strict accordance with manufacturers instructions.
 6. Sizes of proprietary items shall be checked with manufacturer.
 7. The contractor shall be responsible for the coordination of structure, finishes and services.

Issue Status	No.	Date	Revision	Initials
Progress	0	15/09/22	First draft, issued for revision	VB
Planning Application				
Fire Cert				
Disability Cert				
Tender				
Construction				
As Built				
Information Only				

Project Adamstown Extension - Clonburris SDZ
Residential Development

Drawing Title Proposed Apartment Unit Types - Internal Layouts - Sheet 2 of 3

Drawing No 6268-P-601

Scale 1:50@A1 **Rev** A **Drawn** BKD **Date** 20/09/22

6-7 HARPCOURT TERRACE, DUBLIN 2, IRELAND
t +353-1-618 2400 f +353-1-678 7895
www.bkd.ie
bkdarchitects
BURKE-KENNEDY DOYLE