


E-E
P-001
1:500 @ AD
Proposed Street Elevation E-E
Local Streets 3 and 9 Elevations looking East




E-E1
P-002
1:200 @ AD
Proposed Street Elevation E-E1

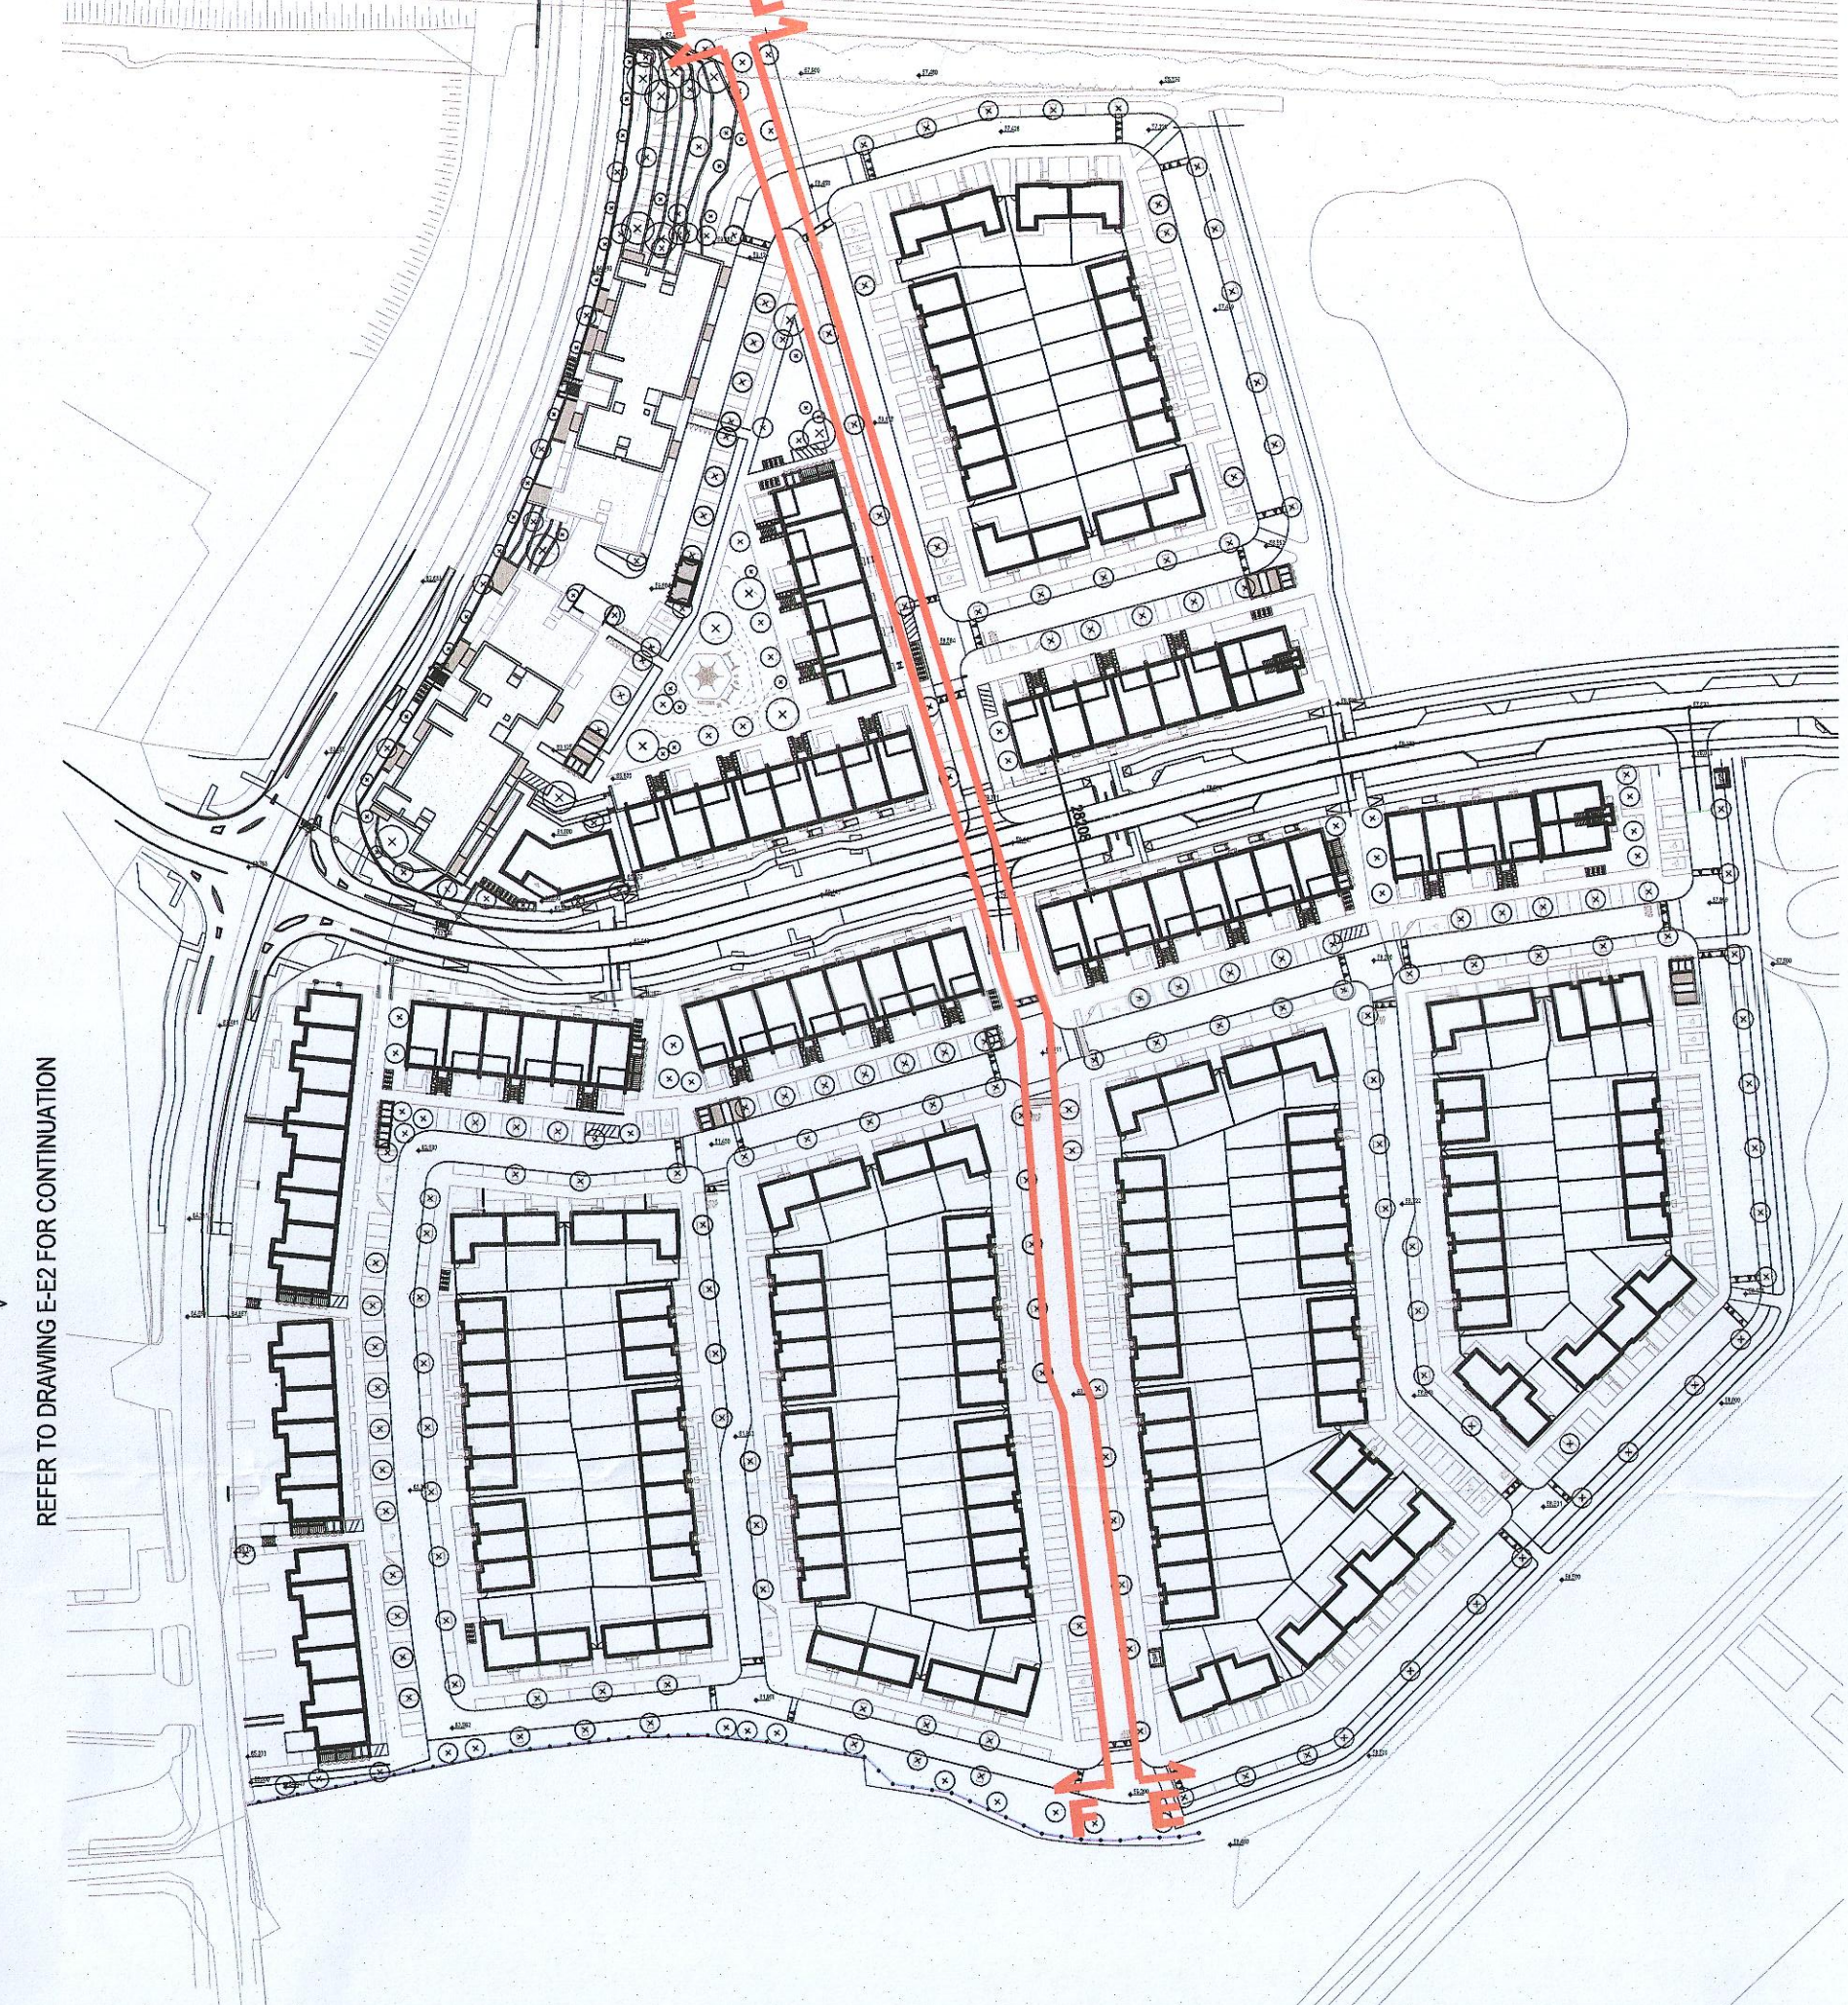

00
P002
Keyplan
Not to scale



E-E2
P-003
1:200 @ AD
Proposed Street Elevation E-E2

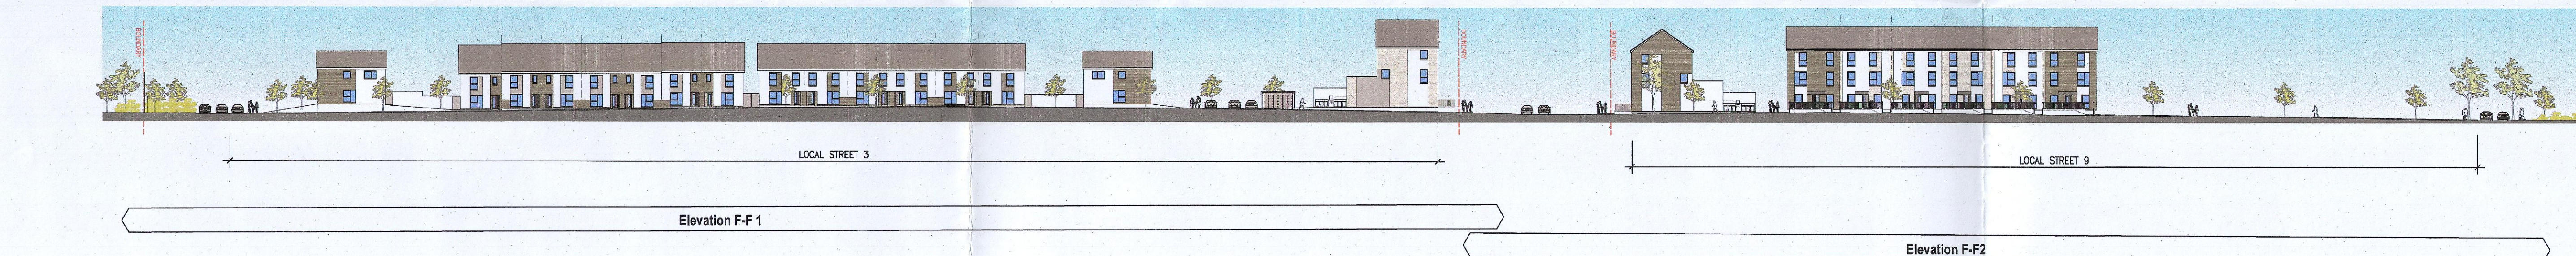

F-F
P-004
1:500 @ AD
Proposed Street Elevation F-F
Local Streets 3 and 9 Elevations looking West



F-F1
P-005
1:200 @ AD
Proposed Street Elevation F-F1



F-F2
P-006
1:200 @ AD
Proposed Street Elevation F-F2

MATERIAL CODE LEGEND

- 01 - BUFF BRICK - STANDARD BOND - LIGHT APPROVED TONE
- 02 - BUFF BRICK - FEATURE BOND - LIGHT APPROVED TONE
- 03 - BUFF BRICK - STANDARD BOND - BROWN APPROVED TONE
- 04 - BUFF BRICK - FEATURE BOND - BROWN APPROVED TONE
- 05 - SELF COLOURED RENDER - LIGHT APPROVED TONE
- 06 - SELF COLOURED RENDER - DARK APPROVED TONE
- 07 - CONCRETE ROOF TILES - DARK APPROVED TONE
- 08 - PRECASTED METALWORK OR UPVC - DARK APPROVED RAL COLOUR
- 09 - PRECASTED METAL SHEETING - DARK APPROVED RAL COLOUR
- 10 - CLEAR GLAZING WITH DARK APPROVED RAL COLOUR FRAMING
- 11 - CRACKED GLAZING WITH DARK APPROVED RAL COLOUR FRAMING

NOTES

- Copyright Reserved
- Work is for the purpose of the design only. Do not scale drawing.
- The contractor is responsible for checking all levels and dimensions on site and shall refer all discrepancies to the architect.
- Where appropriate, for details of structure, mechanical and electrical details, see Engineers drawings.
- Proprietary items shall be fixed in strict accordance with manufacturers instructions.
- Use of proprietary items shall be checked with manufacturer.
- The contractor shall be responsible for the coordination of structure, finishes and services.

REVISIONS

No.	Date	Description	Initials
01	27/07/23	Pre-alignment meeting issue	RF

REVISIONS

No.	Date	Description	Initials
01	27/07/23	Pre-alignment meeting issue	RF

PROJECT INFORMATION

Project	Adamstown Extension - Clonburris SDZ Residential Development
Drawing Title	Contiguous Elevation - E-E & F-F
Drawing No.	6208-P-002
Scale	1:200 @ AD
Rev	01
Drawn	RT
Date	Jul 23