



Area of Works permitted under SDZ 20A-002/1

**Legend:**

**Proposed application boundary**

 PROPOSED AREAS TO BE TAKEN IN CHARGE



 PROPOSED AREAS TO BE TAKEN IN CHARGE BY A MANAGEMENT COMPANY

**THIS DRAWING RELATES TO ORDNANCE SURVEY MAPS O.S. MAP REF: 3260-a,3220-15**

**OS DATUM TO MALIN HEAD**

DIGITALLY REPRODUCED UNDER LICENCE NUMBER: CYAL50177125 © ORDNANCE SURVEY IRELAND / GOVERNMENT OF IRELAND.

**Subject Site Keyplan (NTS)**

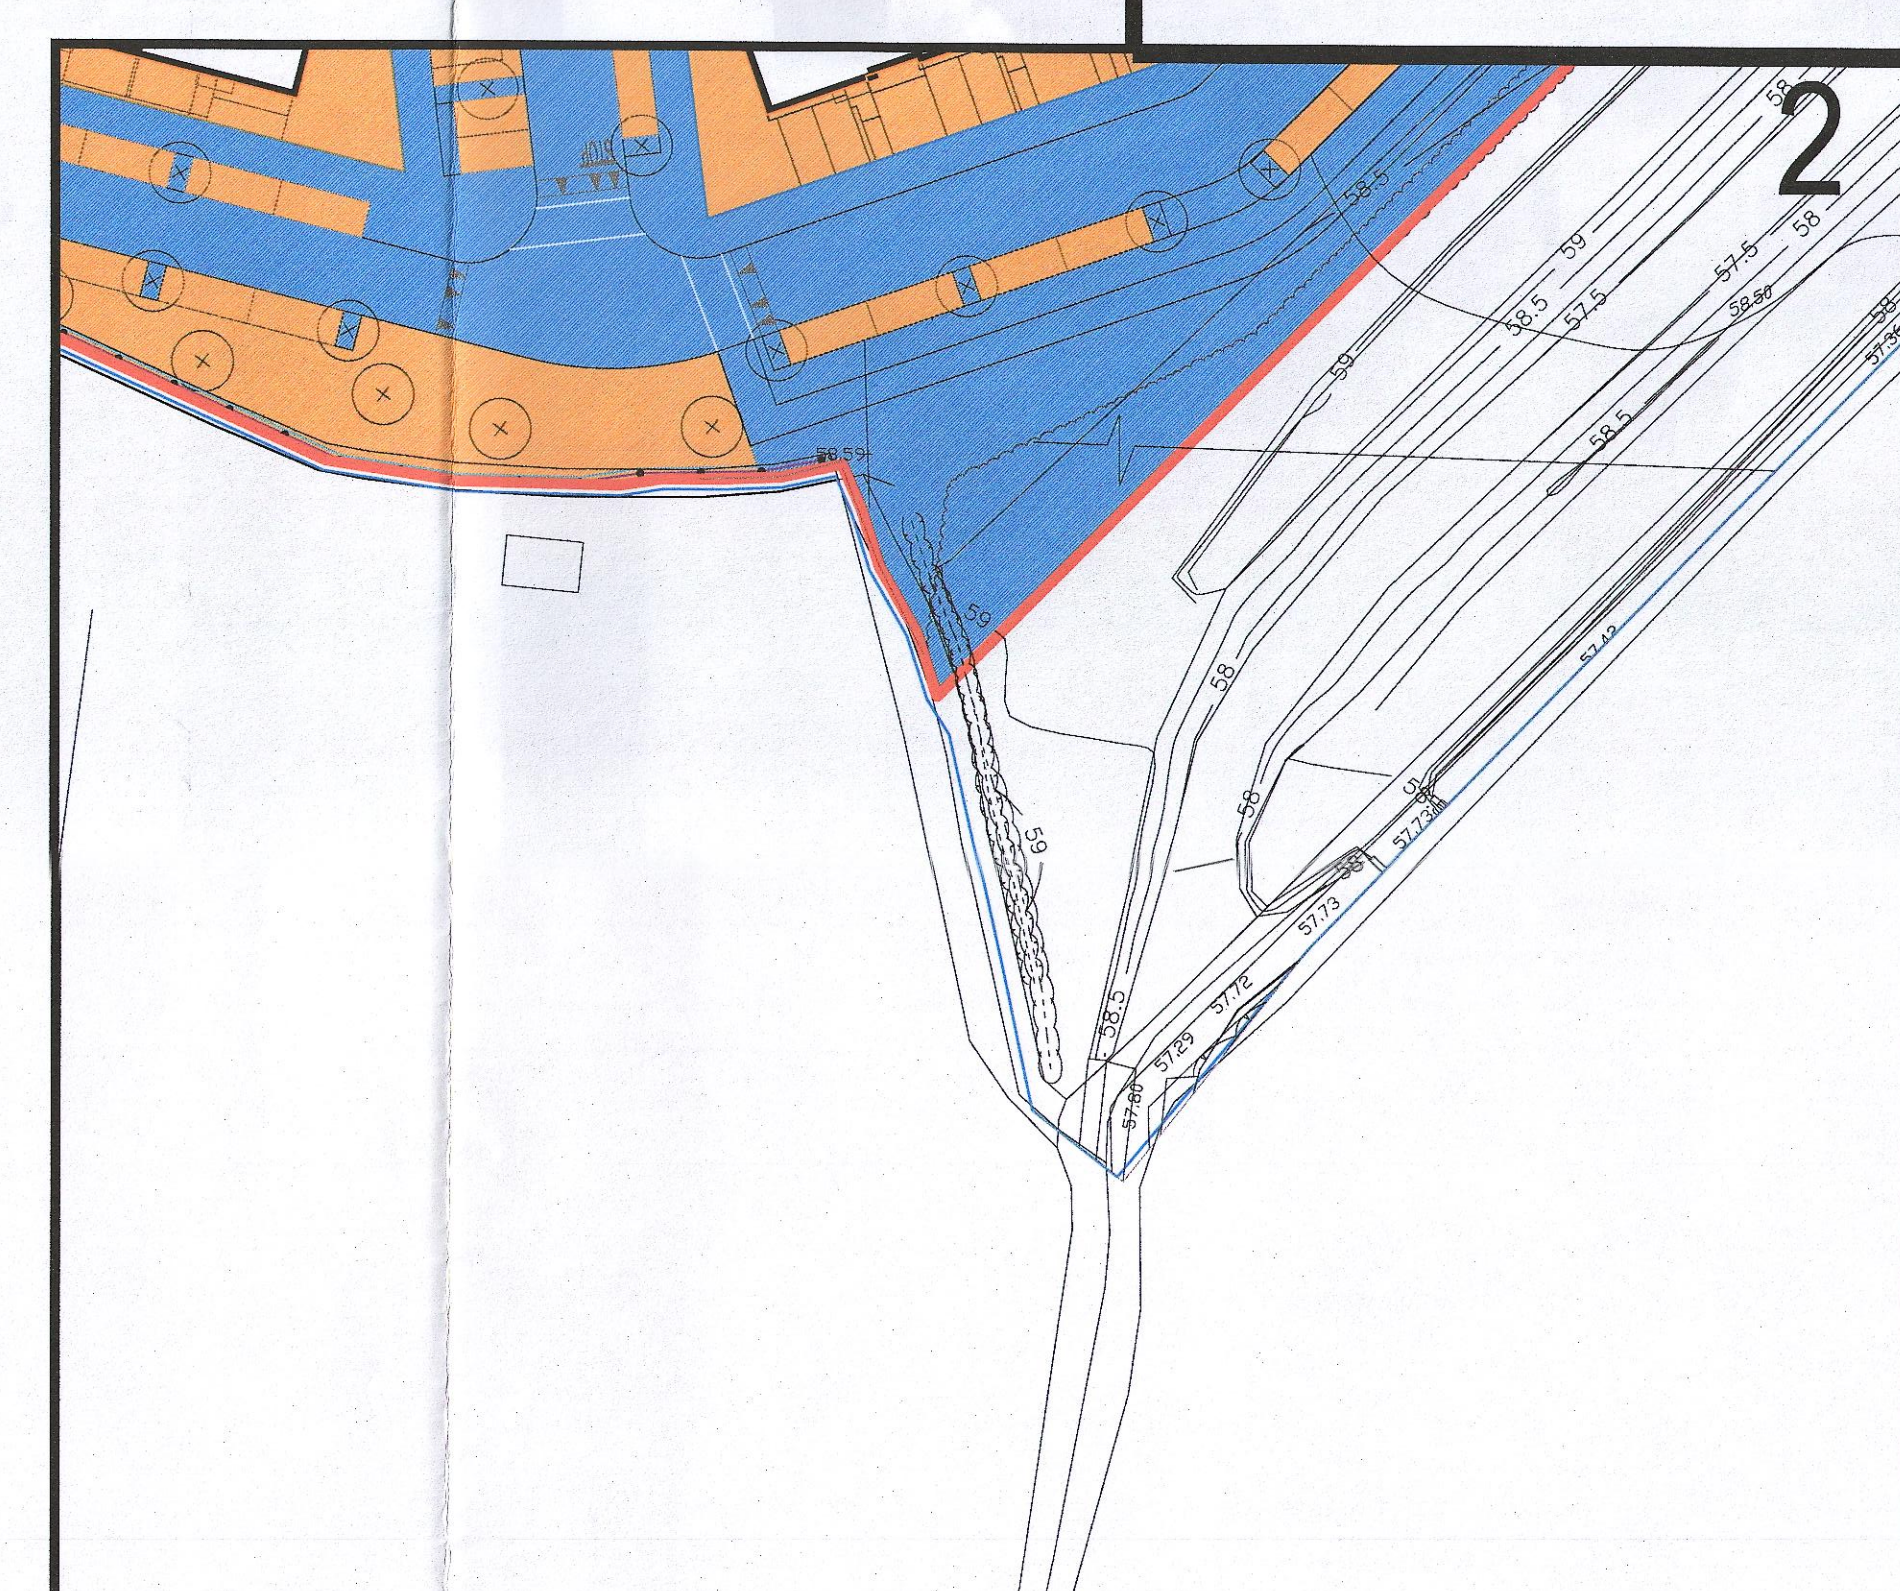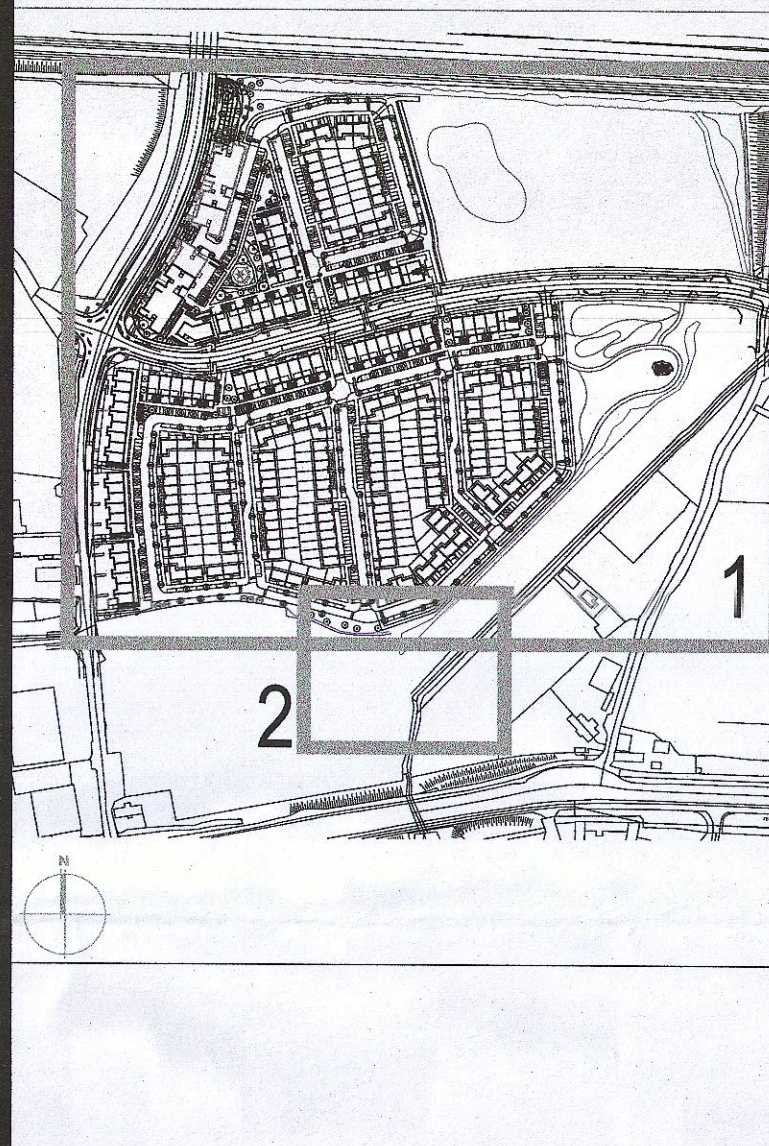

| No. | Date     | Revision             | By |
|-----|----------|----------------------|----|
| 01  | 12/07/23 | Planning Application | RT |

| Discipline           | Author | Checker | Approved |
|----------------------|--------|---------|----------|
| Proposed Application |        |         |          |
| Fire Cert            |        |         |          |
| Accessibility Cert   |        |         |          |
| Planning             |        |         |          |
| Construction         |        |         |          |
| As Built             |        |         |          |
| Information Only     |        |         |          |

**Project:** Adamstown Extension - Clonburris SDZ Residential Development

**Drawing Title:** Proposed Taking in Charge Plan

**Drawing No:** 6268-P-005

**Scale:** 1:500 @ A0

**Rev:** 01

**Drawn:** RT

**Date:** Jan 23

**Project Location:** 6-7 FRANKFORT TERRACE, DUBLIN 2, IRELAND  
 T: +353-1-638-9000 F: +353-1-638-9005  
 www.bkd.ie

**bkd architects**  
 BURKE-KENNEDY-DOYLE

1. Copyright Reserved  
 2. Work to be signed dimensions only. Do not scale drawing.  
 3. The contractor is responsible for checking all work and dimensions on site and shall refer all discrepancies to the Architect.  
 4. Where appropriate, for details of c.s. structure, or mechanical and electrical details, see Engineers drawings.  
 5. Proprietors have read and heed all relevant regulations and manufacturer's instructions.  
 6. Sites of proprietary items shall be checked with manufacturer.  
 7. The applicant shall be responsible for the coordination of structure, fixtures and services.  
 8. The applicant shall be responsible for the coordination of structure, fixtures and services.  
 9. Information Only