




01 Proposed Cargo Bicycle Parking Type 3 - Ground Plan
P-702 1:500A1

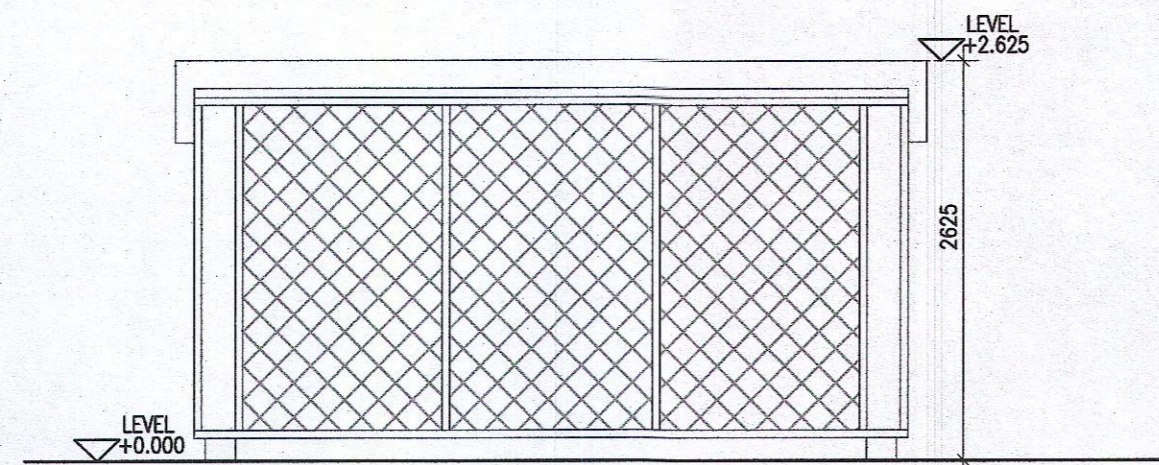


04 Proposed Cargo Bicycle Parking Type 3 - Elevation B
P-702 1:500A1

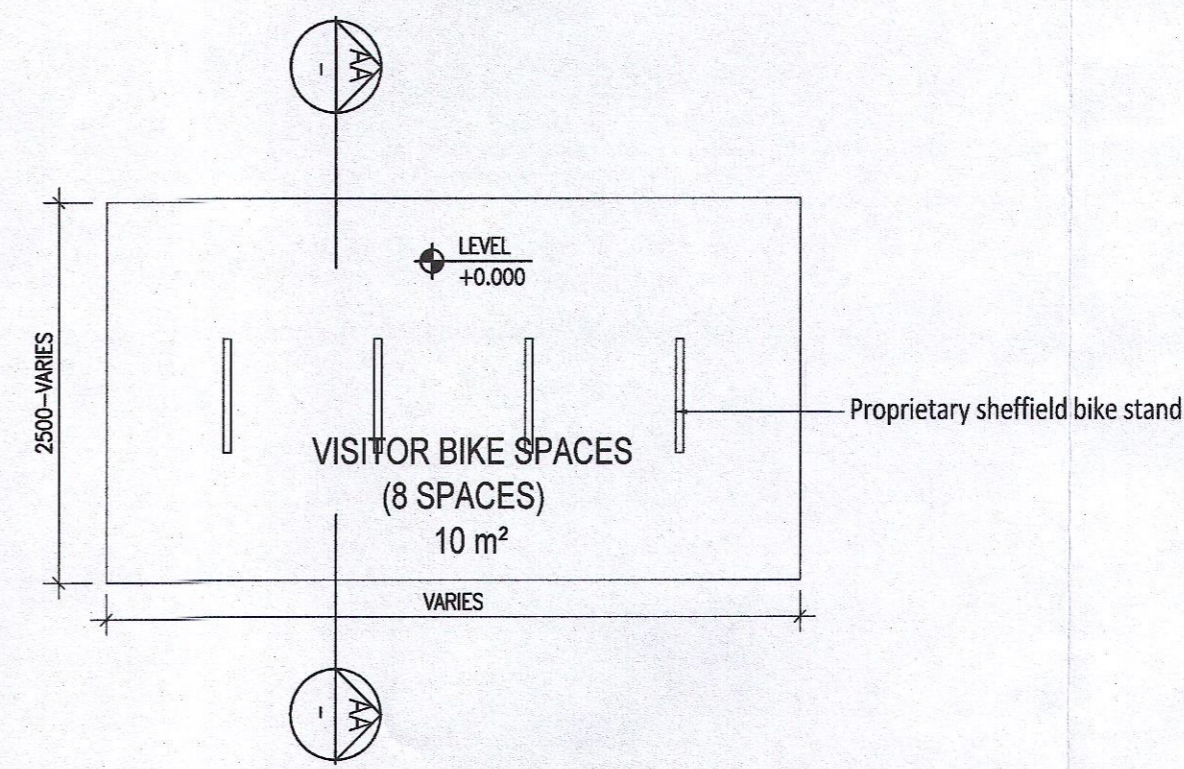


01 Proposed Visitor Bicycle Shelter Type 4 - Ground Plan
P-702 1:500A1

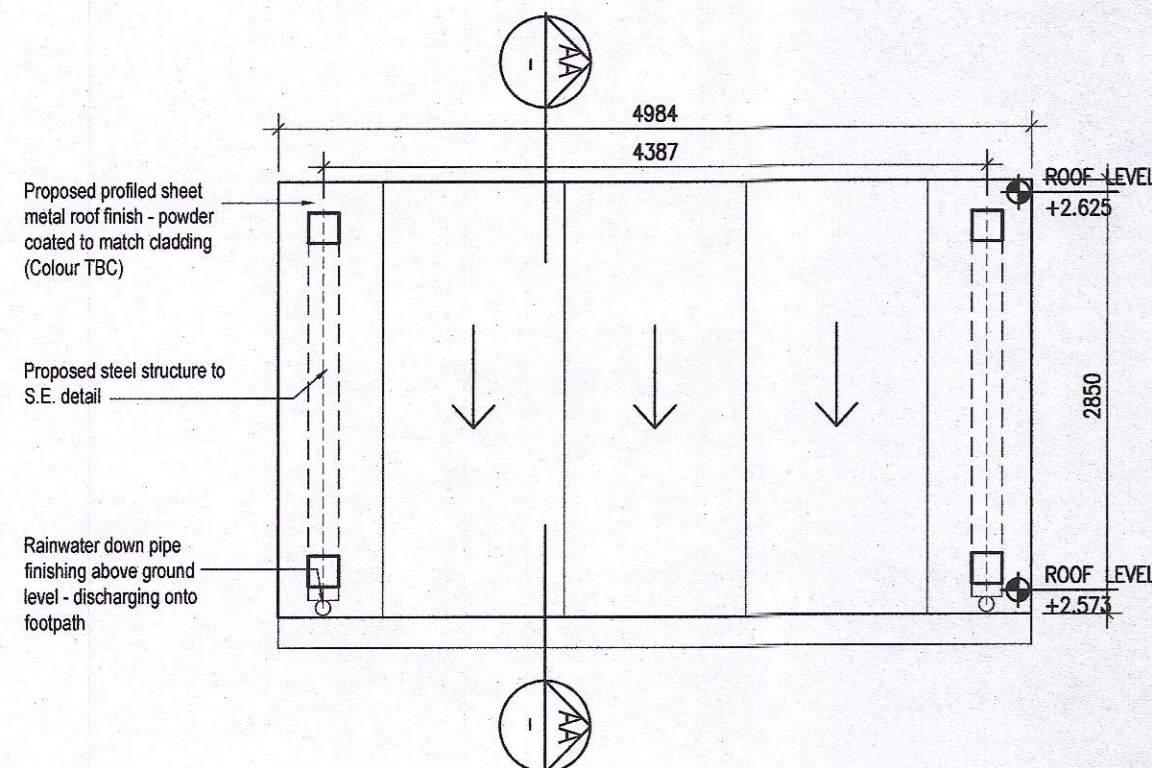


02 Proposed Cargo Bicycle Parking Type 3 - Roof Plan
P-702 1:500A1

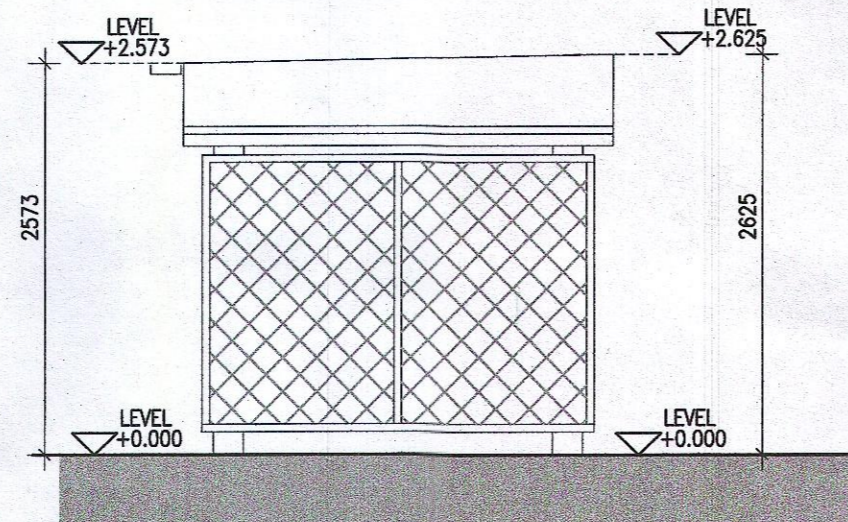


05 Proposed Cargo Bicycle Parking Type 3 - Elevation C
P-702 1:500A1

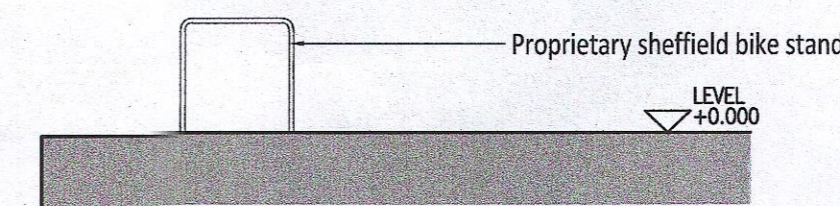


02 Proposed Visitor Bicycle Shelter Type 4 - Section
P-702 1:500A1

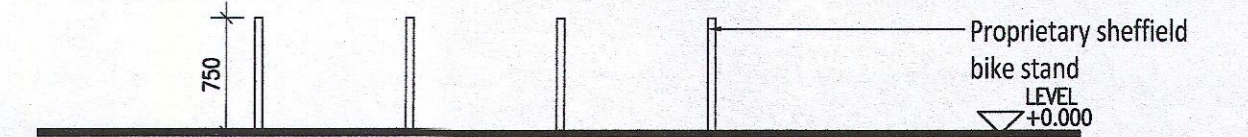


03 Proposed Visitor Bicycle Shelter Type 4 - Elevation
P-702 1:500A1

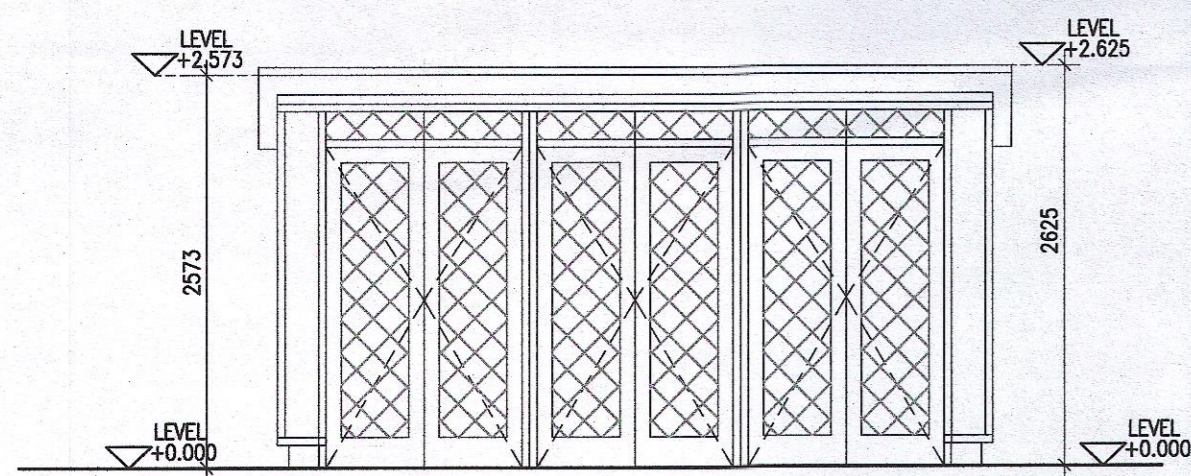


03 Proposed Cargo Bicycle Parking Type 3 - Elevation A
P-702 1:500A1

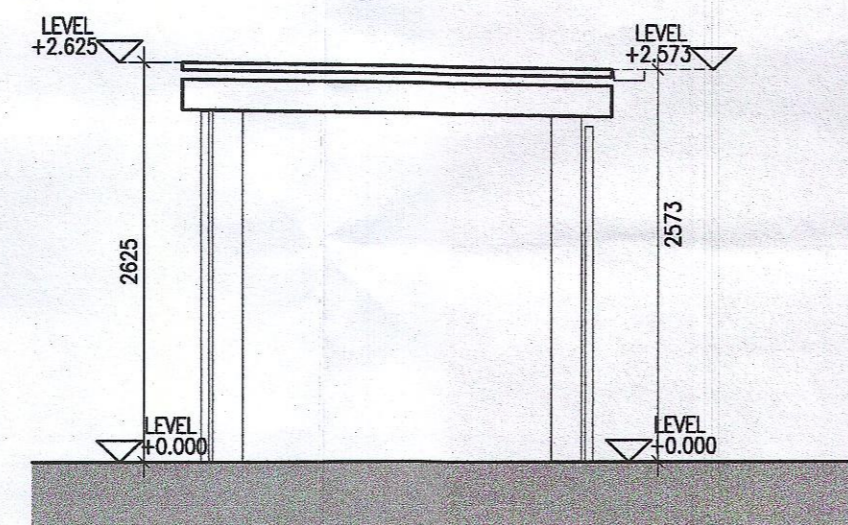


06 Proposed Cargo Bicycle Parking Type 3 - Section A-A
P-702 1:500A1

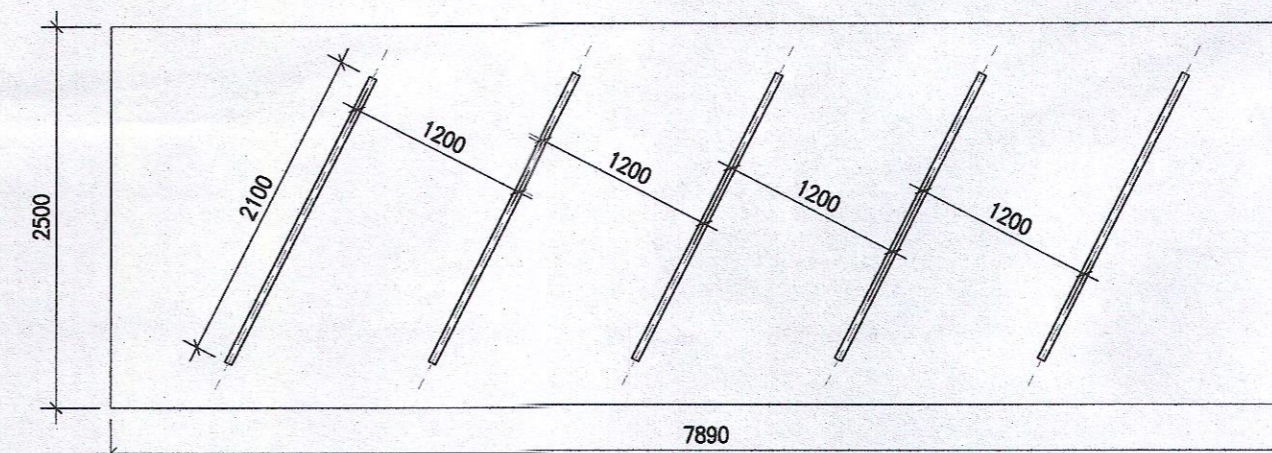


01 Proposed Cargo Parking Type 5 - Ground Plan
P-702 1:500A1

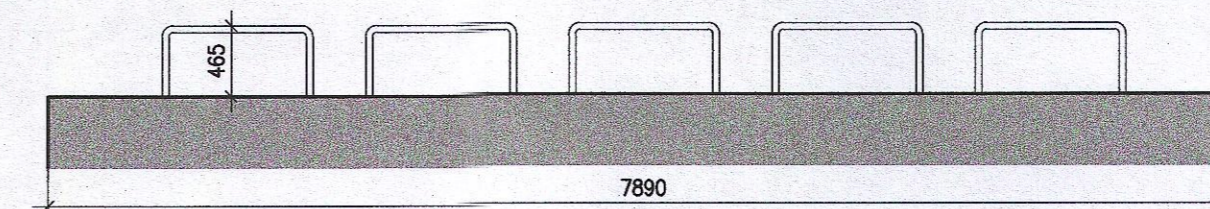

02 Proposed Cargo Parking Type 5 - Front Elevation
P-702 1:500A1

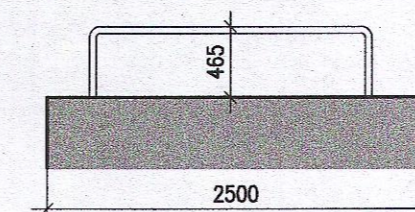

03 Proposed Cargo Parking Type 5 - Side Elevation
P-702 1:500A1

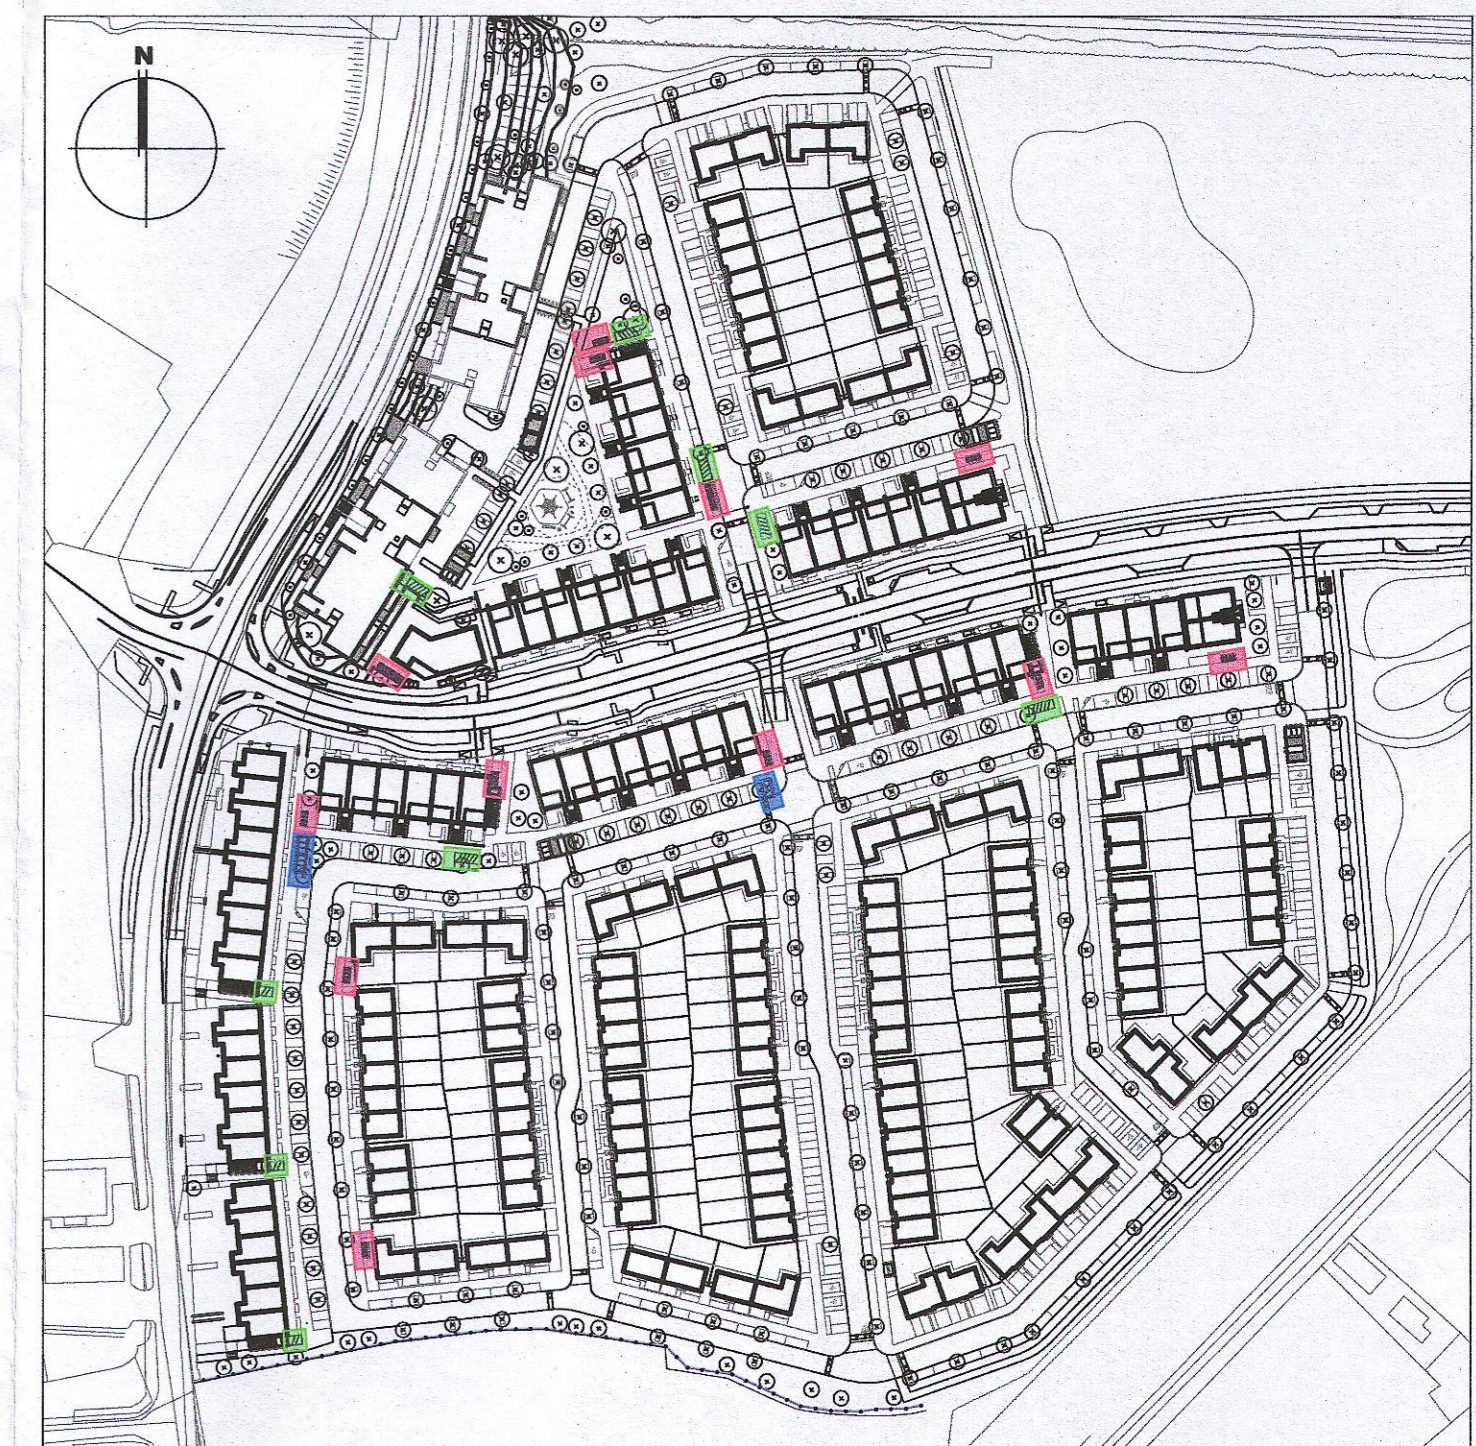

BICYCLE STORES TYPE 3, 4 & 5

Project	Adamstown Extension - Clonburris SDZ Residential Development		6-7 HARPCOURT TERRACE, DUBLIN 2, IRELAND t: +353-1-618 2400 f: +353-1-478 7385 e: architecture@bkd.ie
Drawing Title	Bicycle Store Details Type 3, 4 & 5		www.bkd.ie
Drawing No	6268-P-702		 BURKE-KENNEDY DOYLE
Scale	1:50@A1	Rev 01	

- Notes
- Copyright Reserved
 - Work to figured dimensions only. Do not scale drawing.
 - The contractor is responsible for checking all levels and dimensions on site and shall refer all discrepancies to the Architect.
 - Where appropriate, for details of r.c. structure, or mechanical and electrical details, see Engineers drawings.
 - Proprietary items shall be fixed in strict accordance with manufacturers instructions.
 - Sizes of proprietary items shall be checked with manufacturer.
 - The contractor shall be responsible for the coordination of structure, finishes and services.

Issue Status	
Progress	
Planning Application	
Fire Cert	
Disability Cert	
Tender	
Construction	
As Built	
Information Only	

No	Date	Revision	Initials
01	27/01/23	Planning Application	AM