




01 Proposed Bicycle Parking Type 1 - Ground Plan
P-700 1:500A1

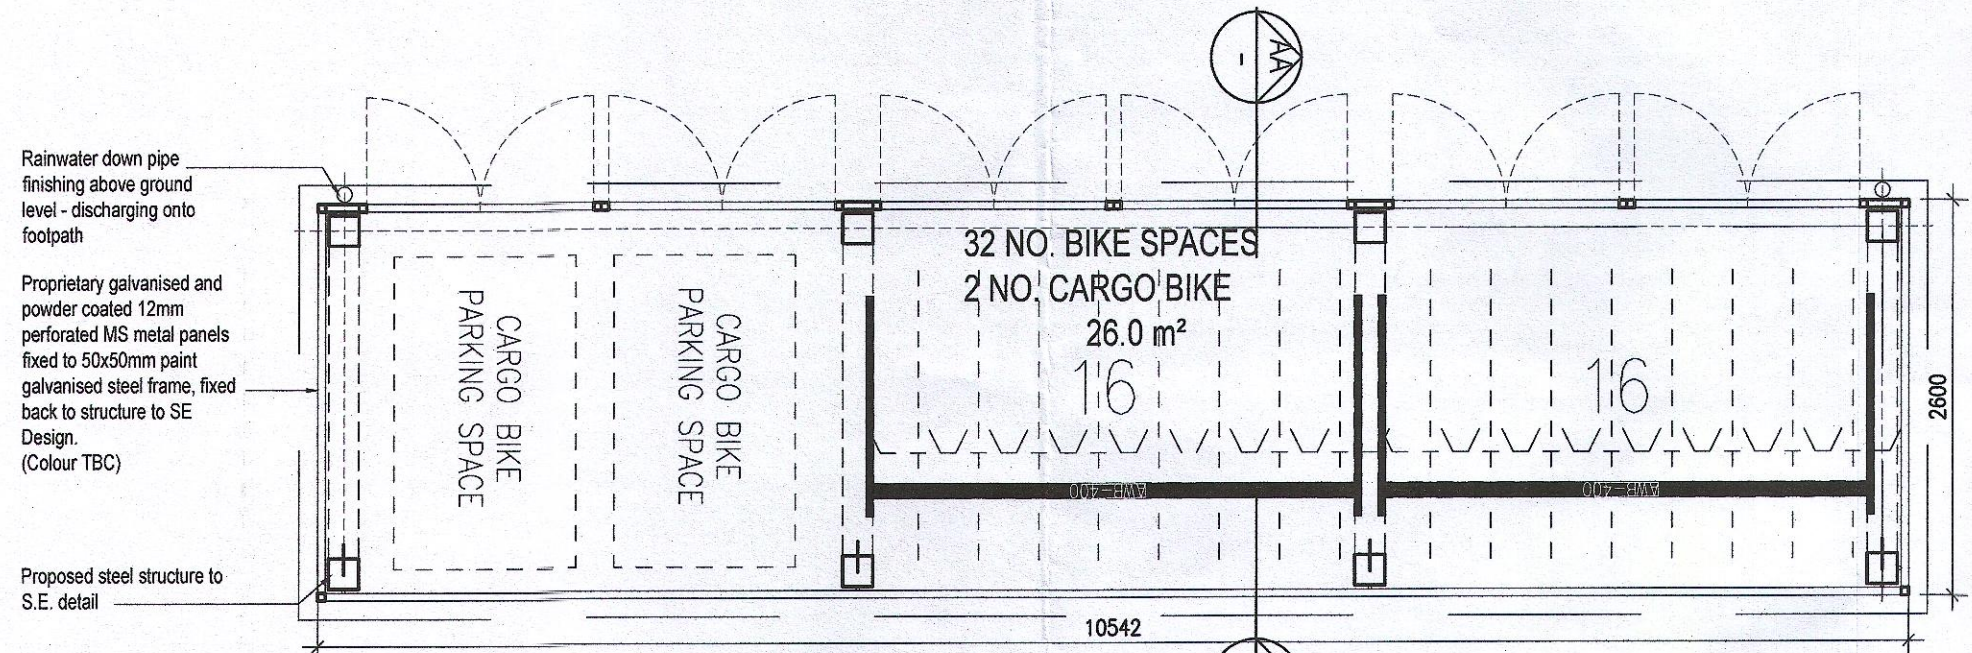


02 Proposed Bicycle Parking Type 1A - Ground Plan
P-700 1:500A1

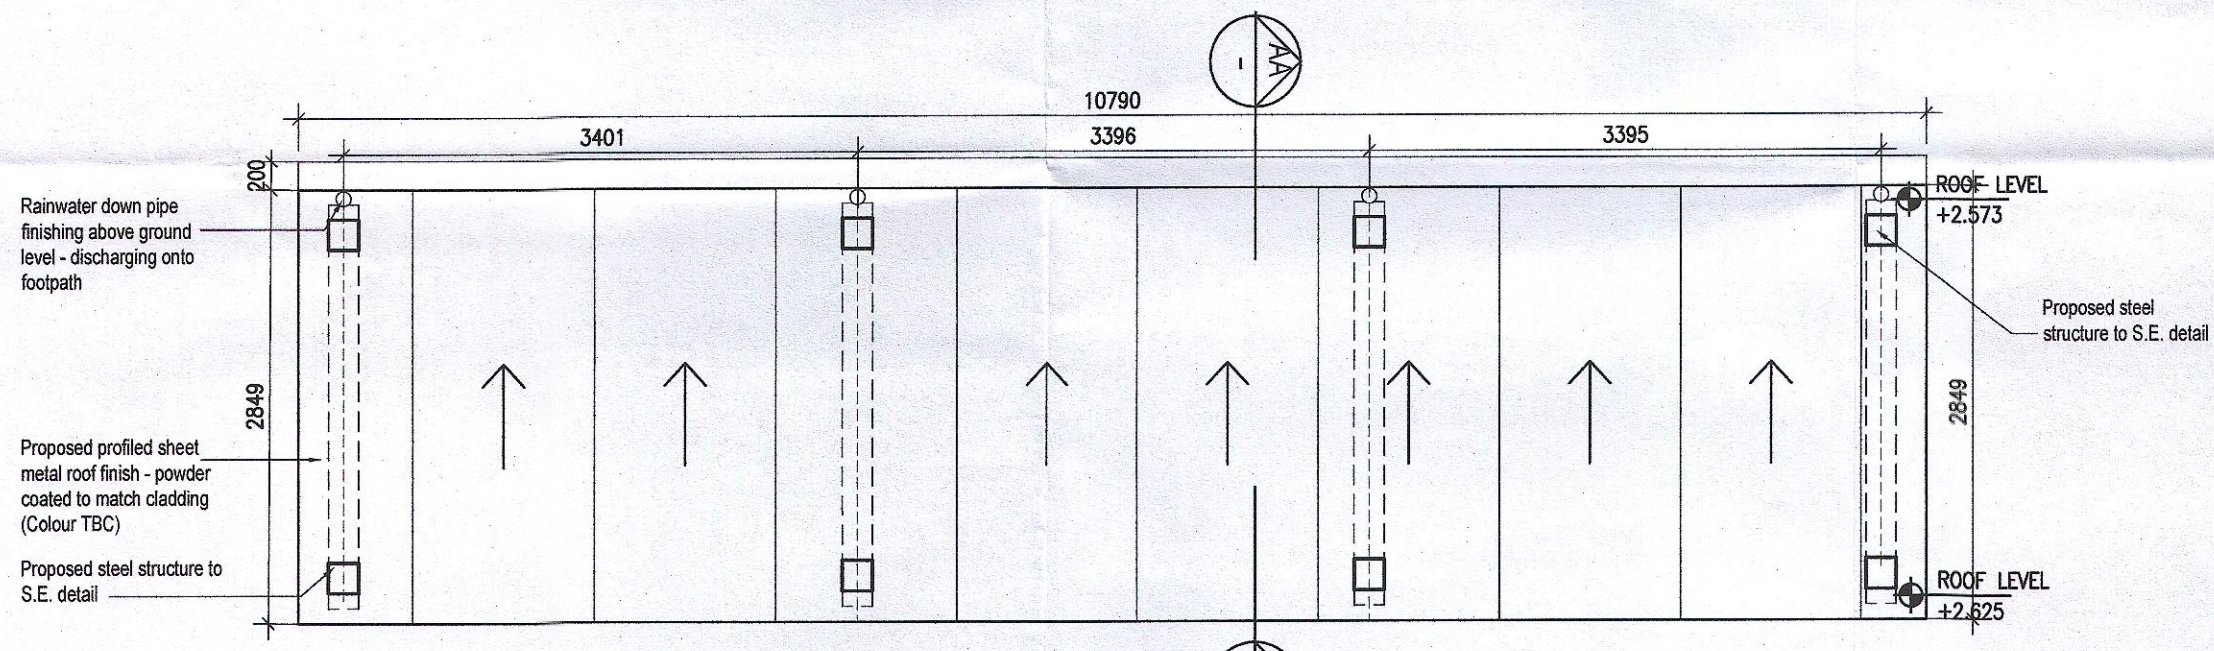


03 Proposed Bicycle Parking Type 1 & 1A - Roof Plan
P-700 1:500A1

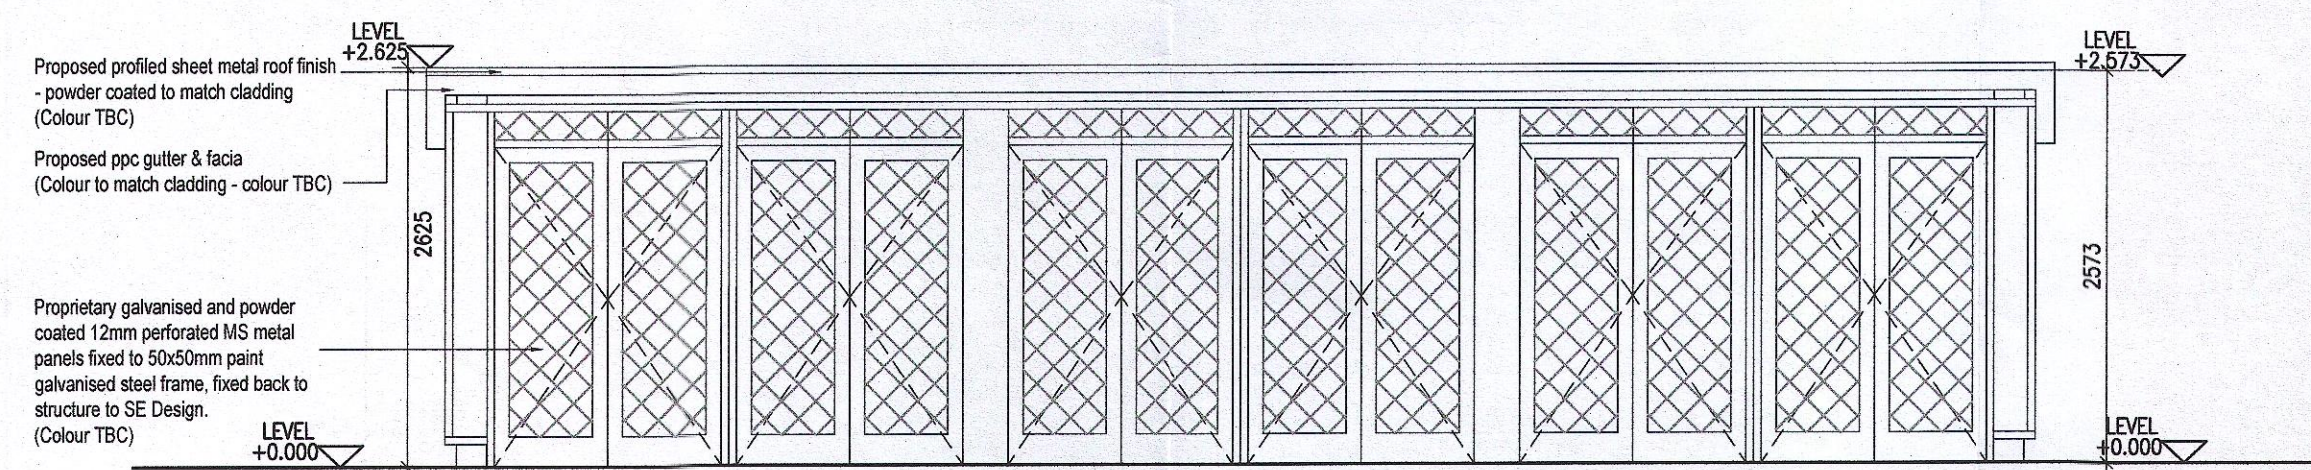

04 Proposed Bicycle Parking Type 1 & 1A - Elevation A
P-700 1:500A1

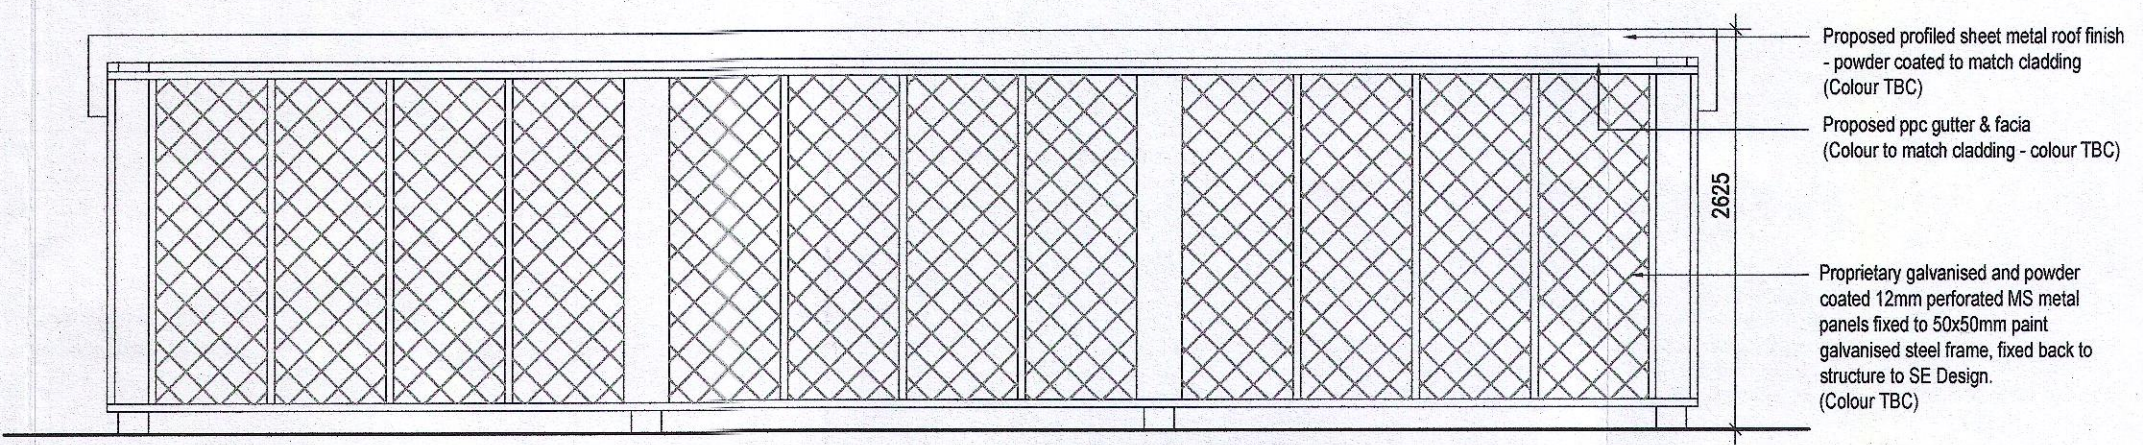


05 Proposed Bicycle Parking Type 1 & 1A - Elevation B
P-700 1:500A1

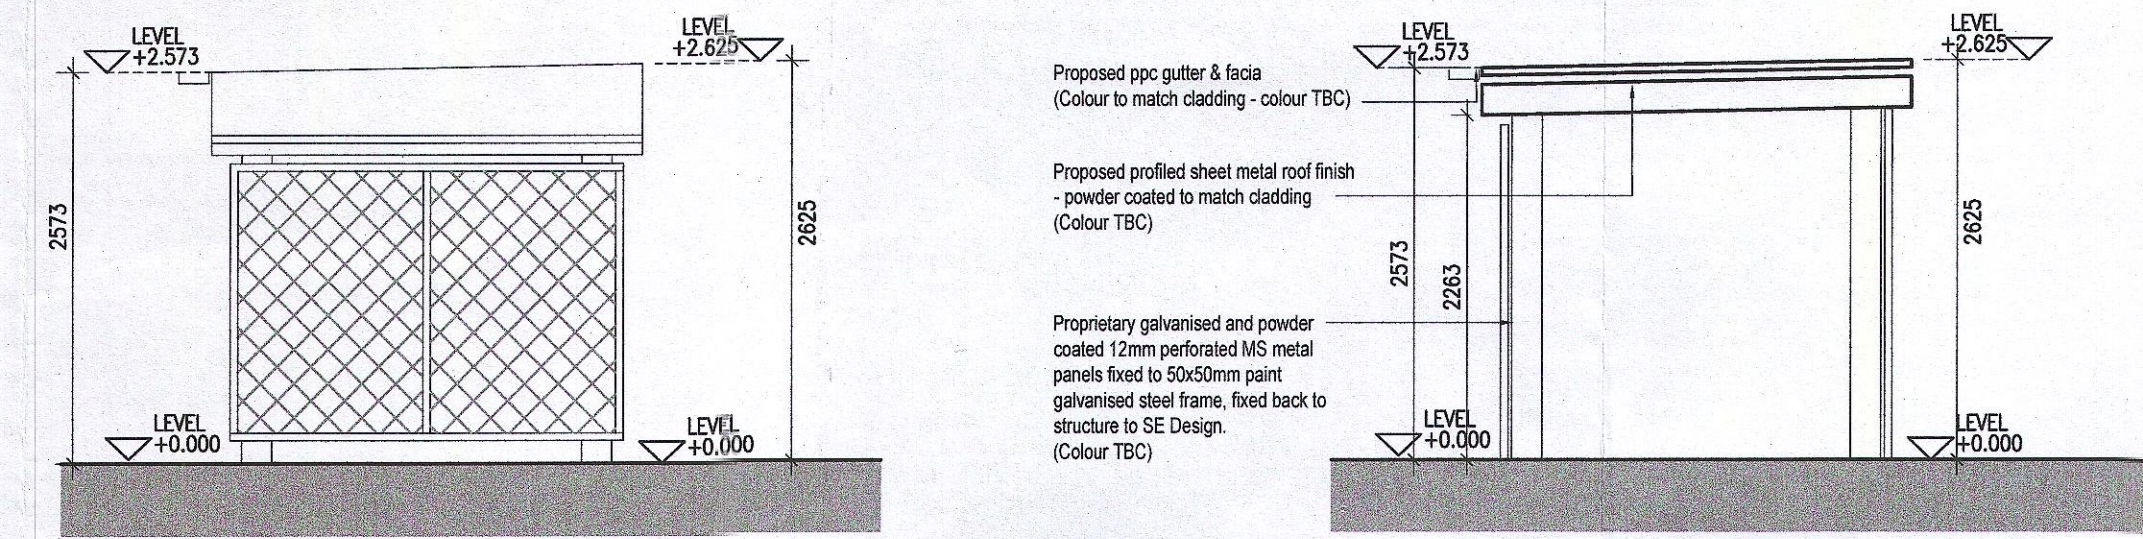

06 Proposed Bicycle Parking Type 1 & 1A - Elevation C
P-700 1:500A1

06 Proposed Bicycle Parking Type 1 & 1A - Section A-A
P-700 1:500A1

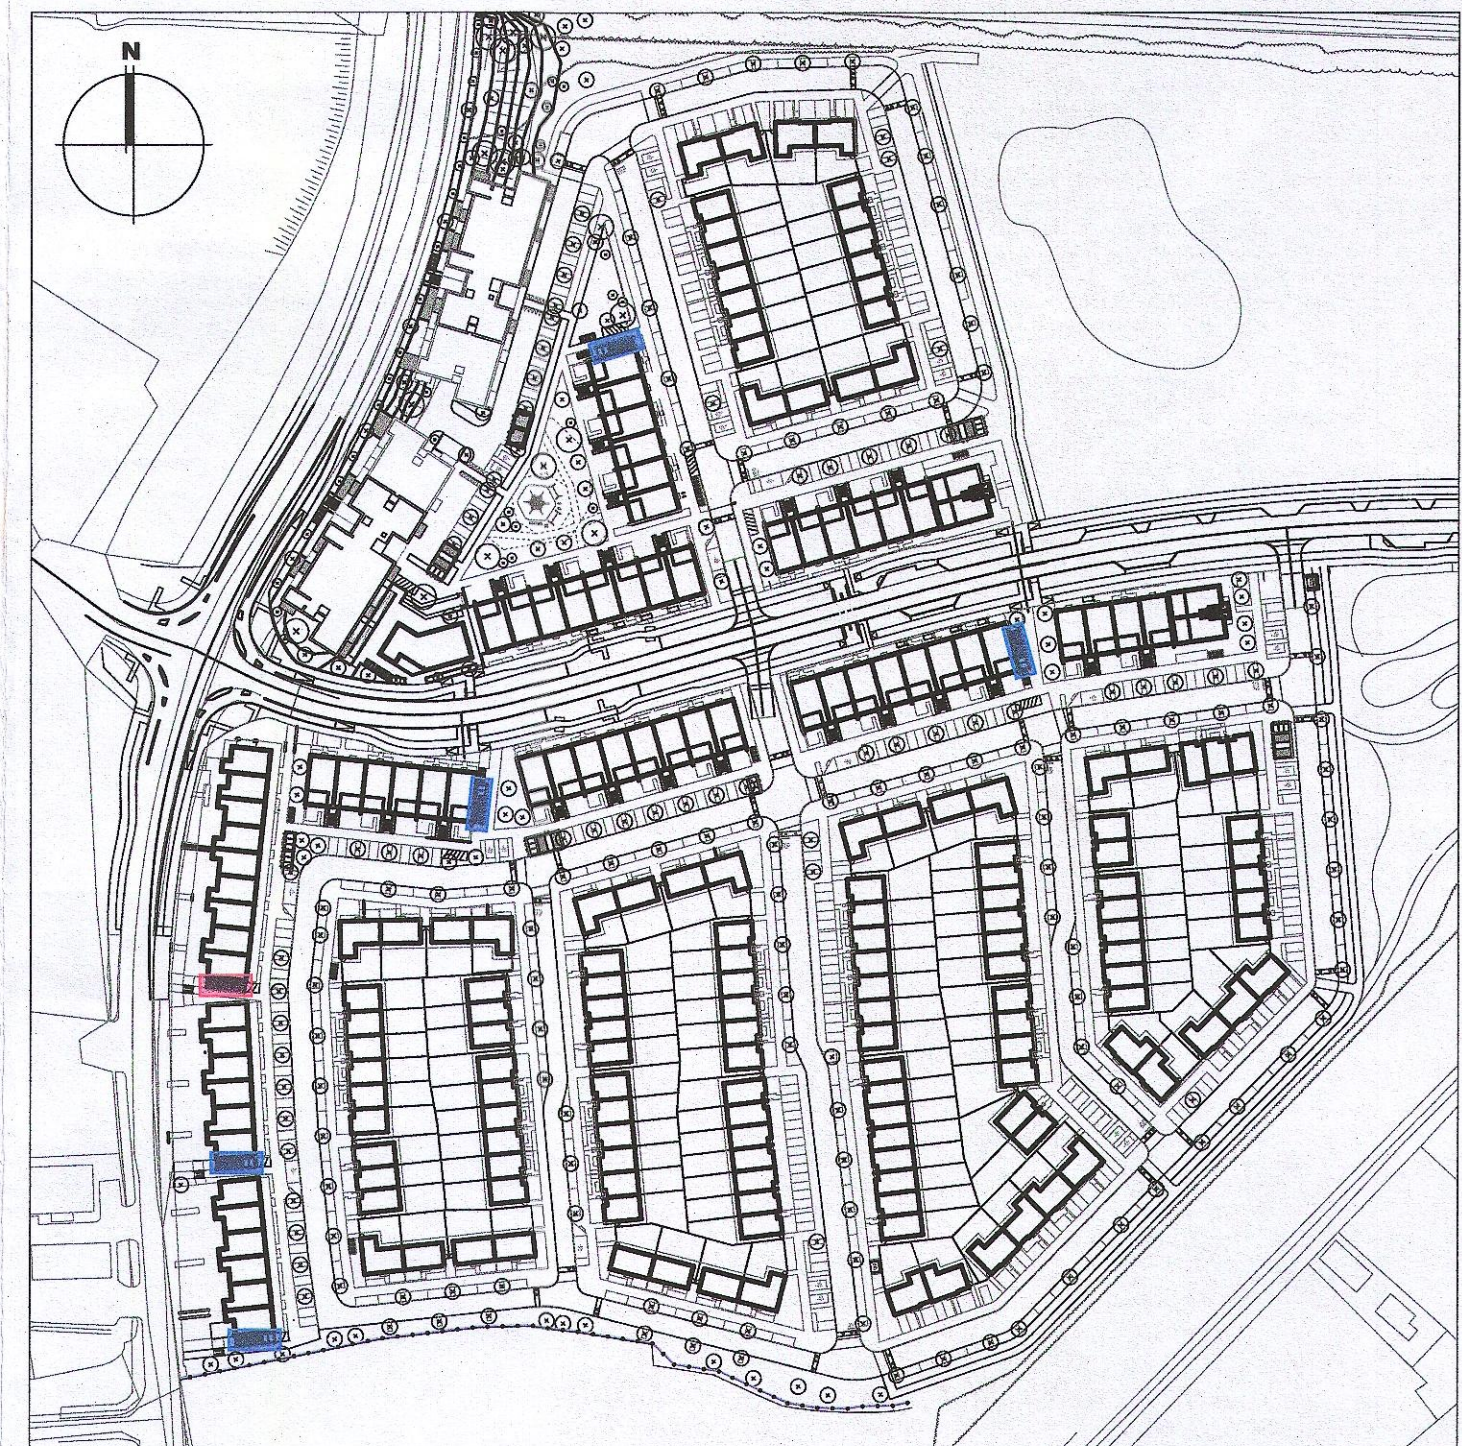

BICYCLE STORES TYPE 1 & TYPE 1A

Notes
 1. Copyright Reserved
 2. Work to figured dimensions only. Do not scale drawing.
 3. The contractor is responsible for checking all levels and dimensions on site and shall refer all discrepancies to the Architect.
 4. Where appropriate, for details of r.c. structure, or mechanical and electrical details, see Engineers drawings.
 5. Proprietary items shall be fixed in strict accordance with manufacturer's instructions.
 6. Sizes of proprietary items shall be checked with manufacturer.
 7. The contractor shall be responsible for the coordination of structure, finishes and services.

Issue Status	No.	Date	Revision	Initials
Progress	01	27/01/23	Planning Application	AM
Planning Application				
Fire Cert				
Disability Cert				
Tender				
Construction				
As Built				
Information Only				

Project: Adamstown Extension - Clonburris SDZ Residential Development
 Drawing Title: Bicycle Store Details Type 1 and 1A
 Drawing No: 6268-P-700
 Scale: 1:50@A1 Rev: 01 Drawn: AM Date: Jan 23

6-7 HARCOURT TERRACE, DUBLIN 2, IRELAND
 T: +353-1-618 2400 F: +353-1-409 7395
 e: info@bkd.ie www.bkd.ie

bkd architects
 BURKE-KENNEDY DOYLE