



**TYPE 4**


Duplex Type:  
J/K

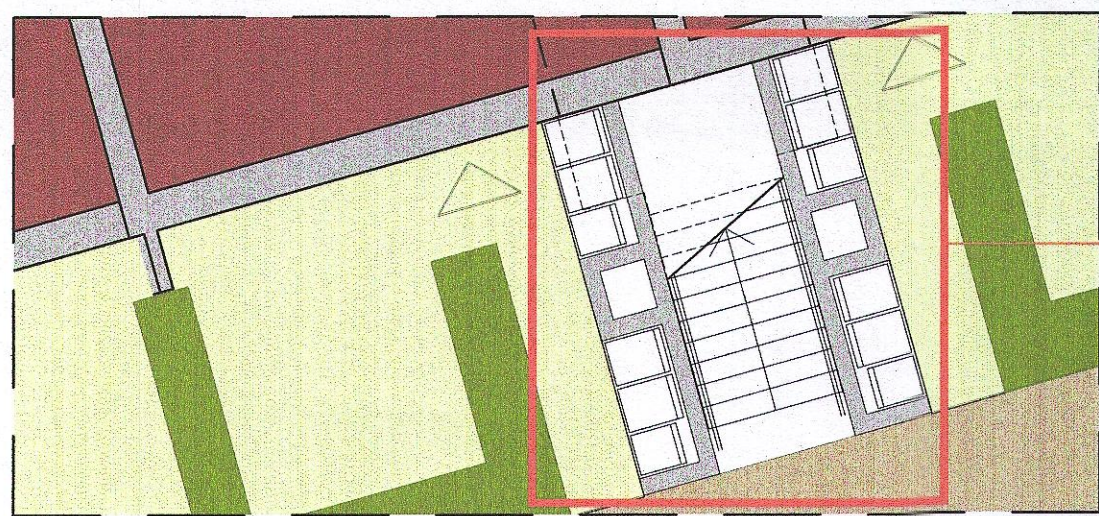


TYPE 4

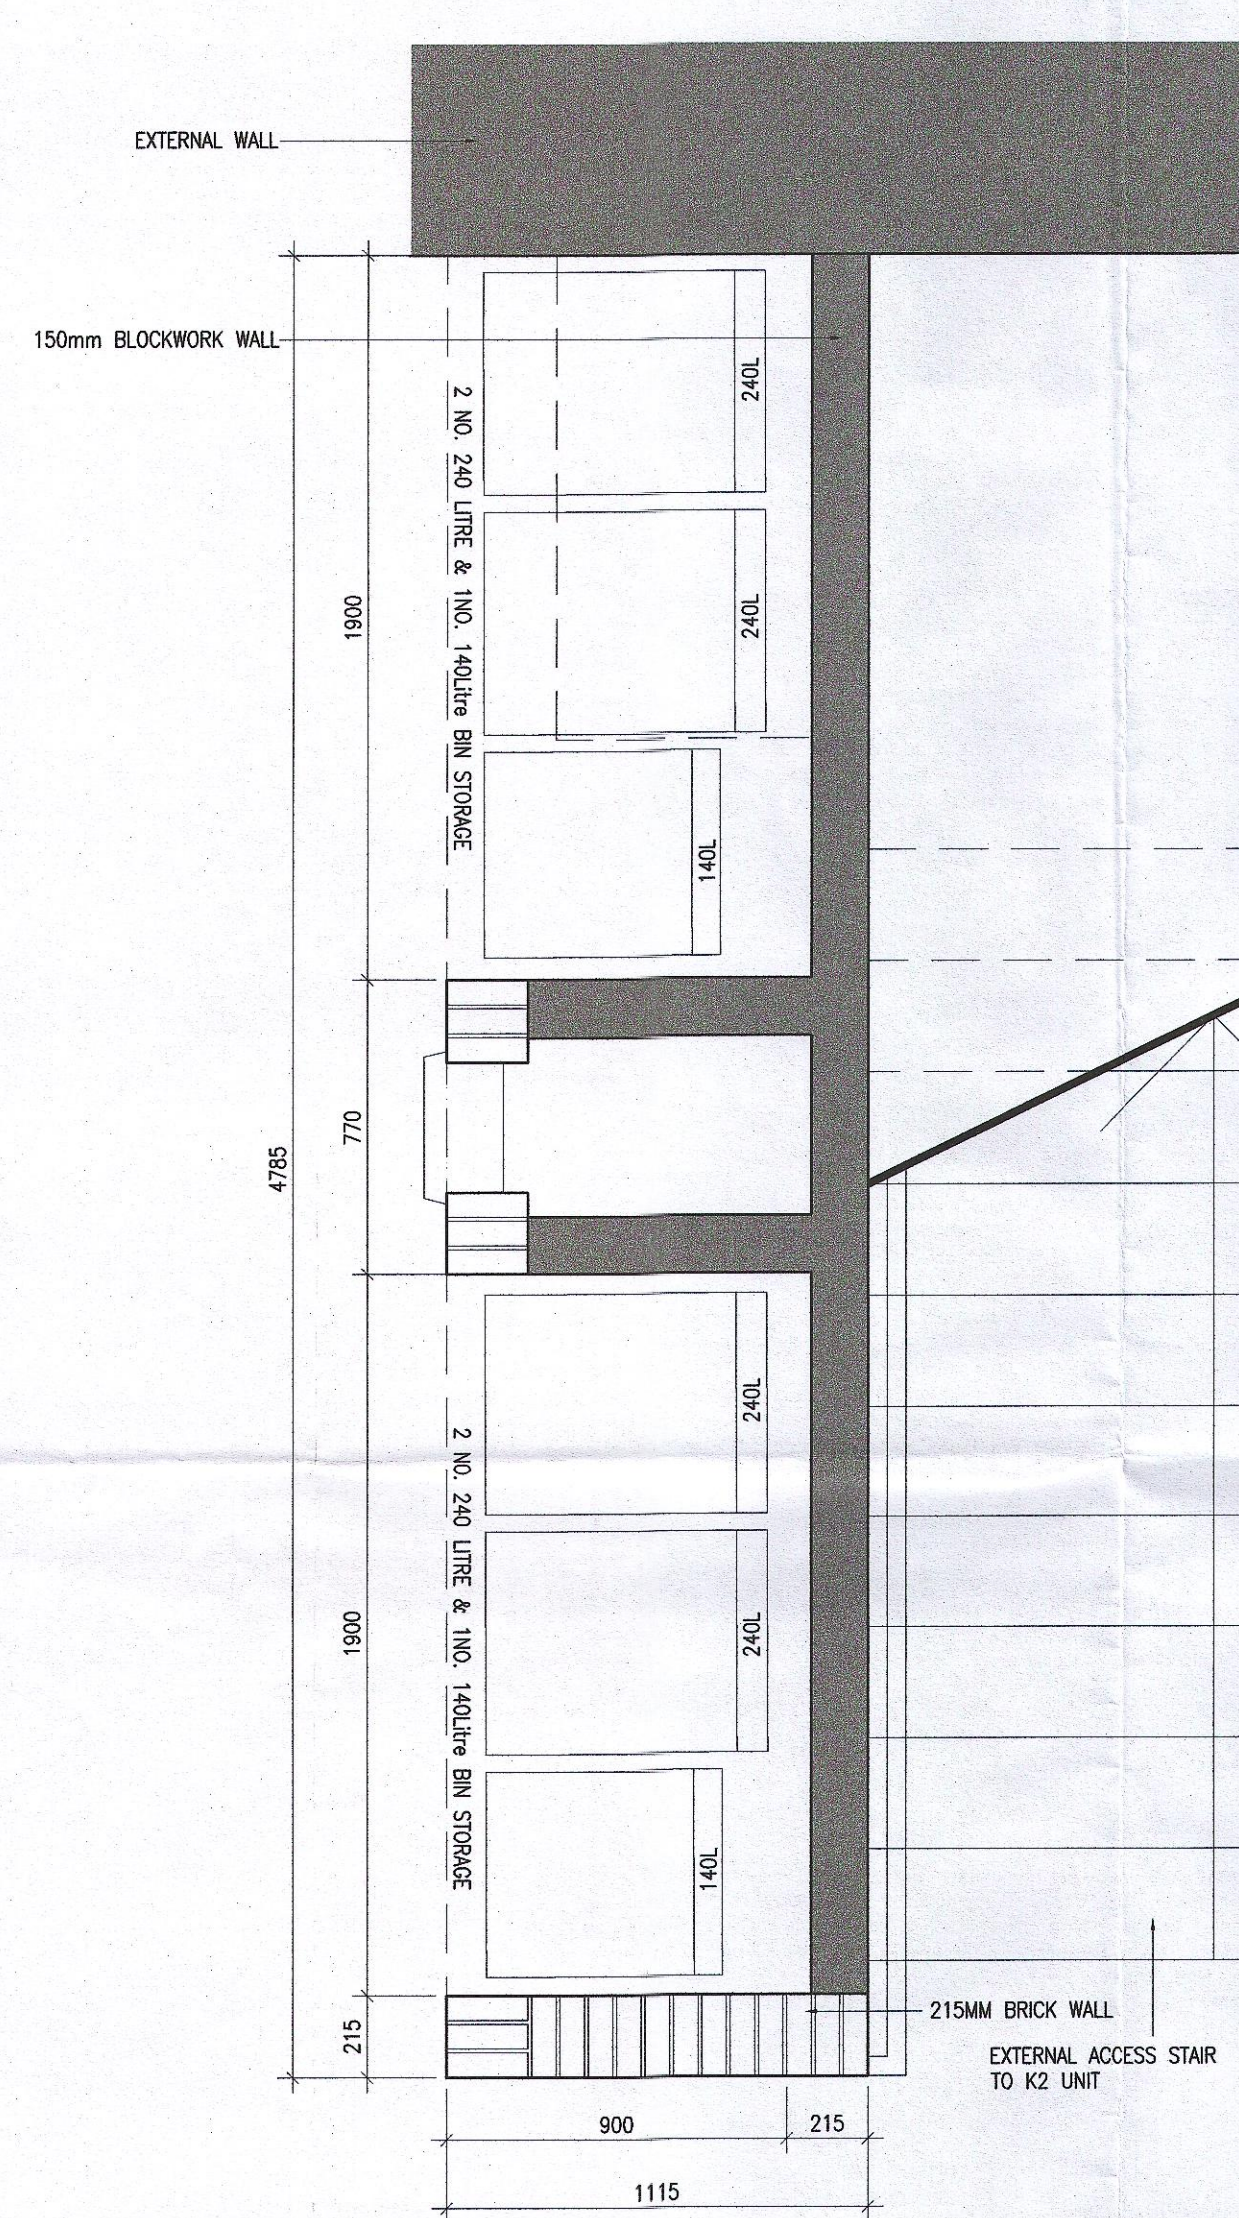

1 Bin store Type 4 Plan  
704 Scale 1:20

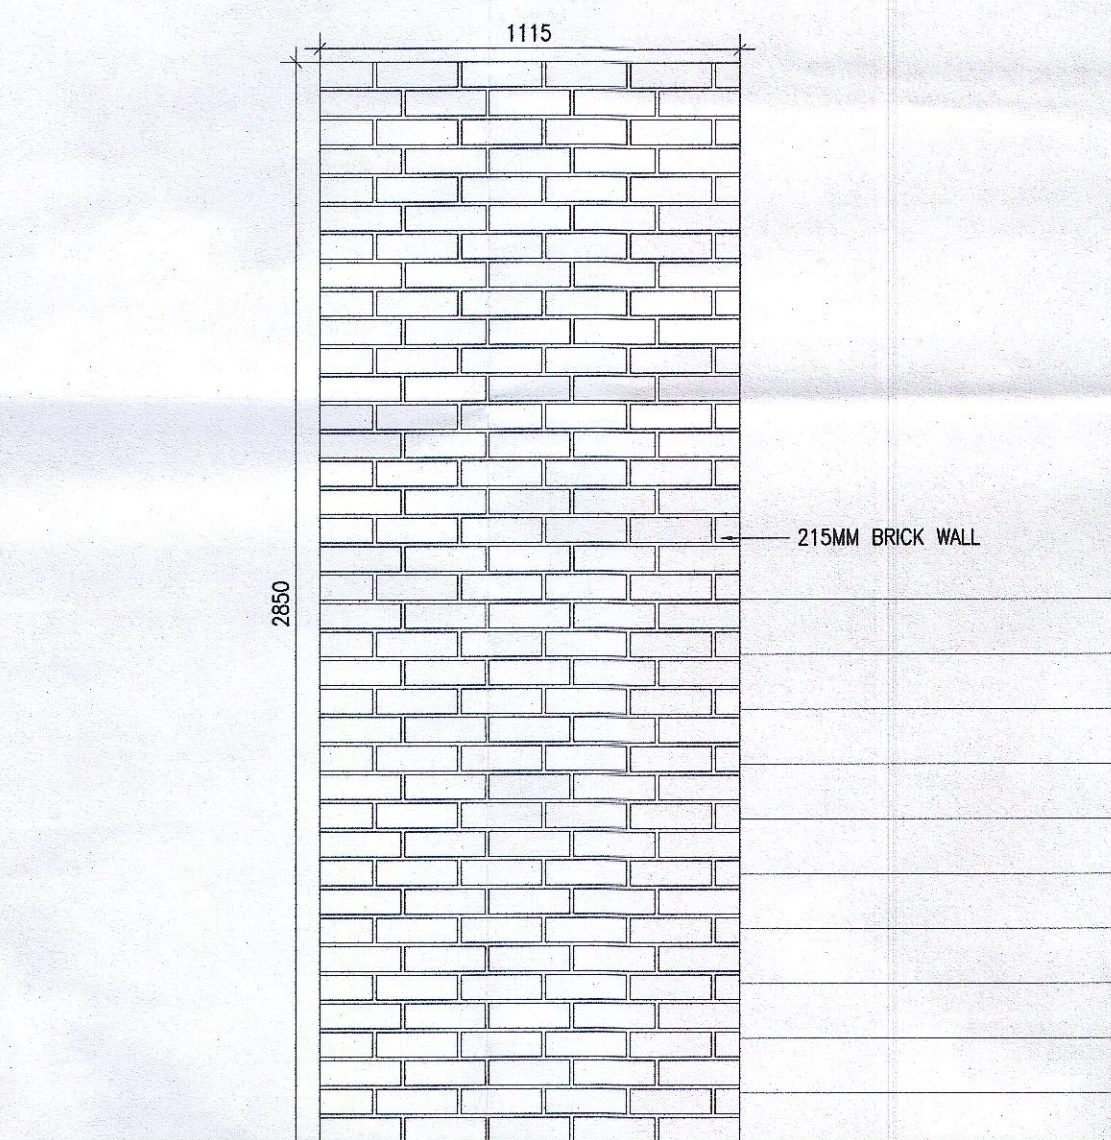

2 Bin store Type 4 Front Elevation  
704 Scale 1:20

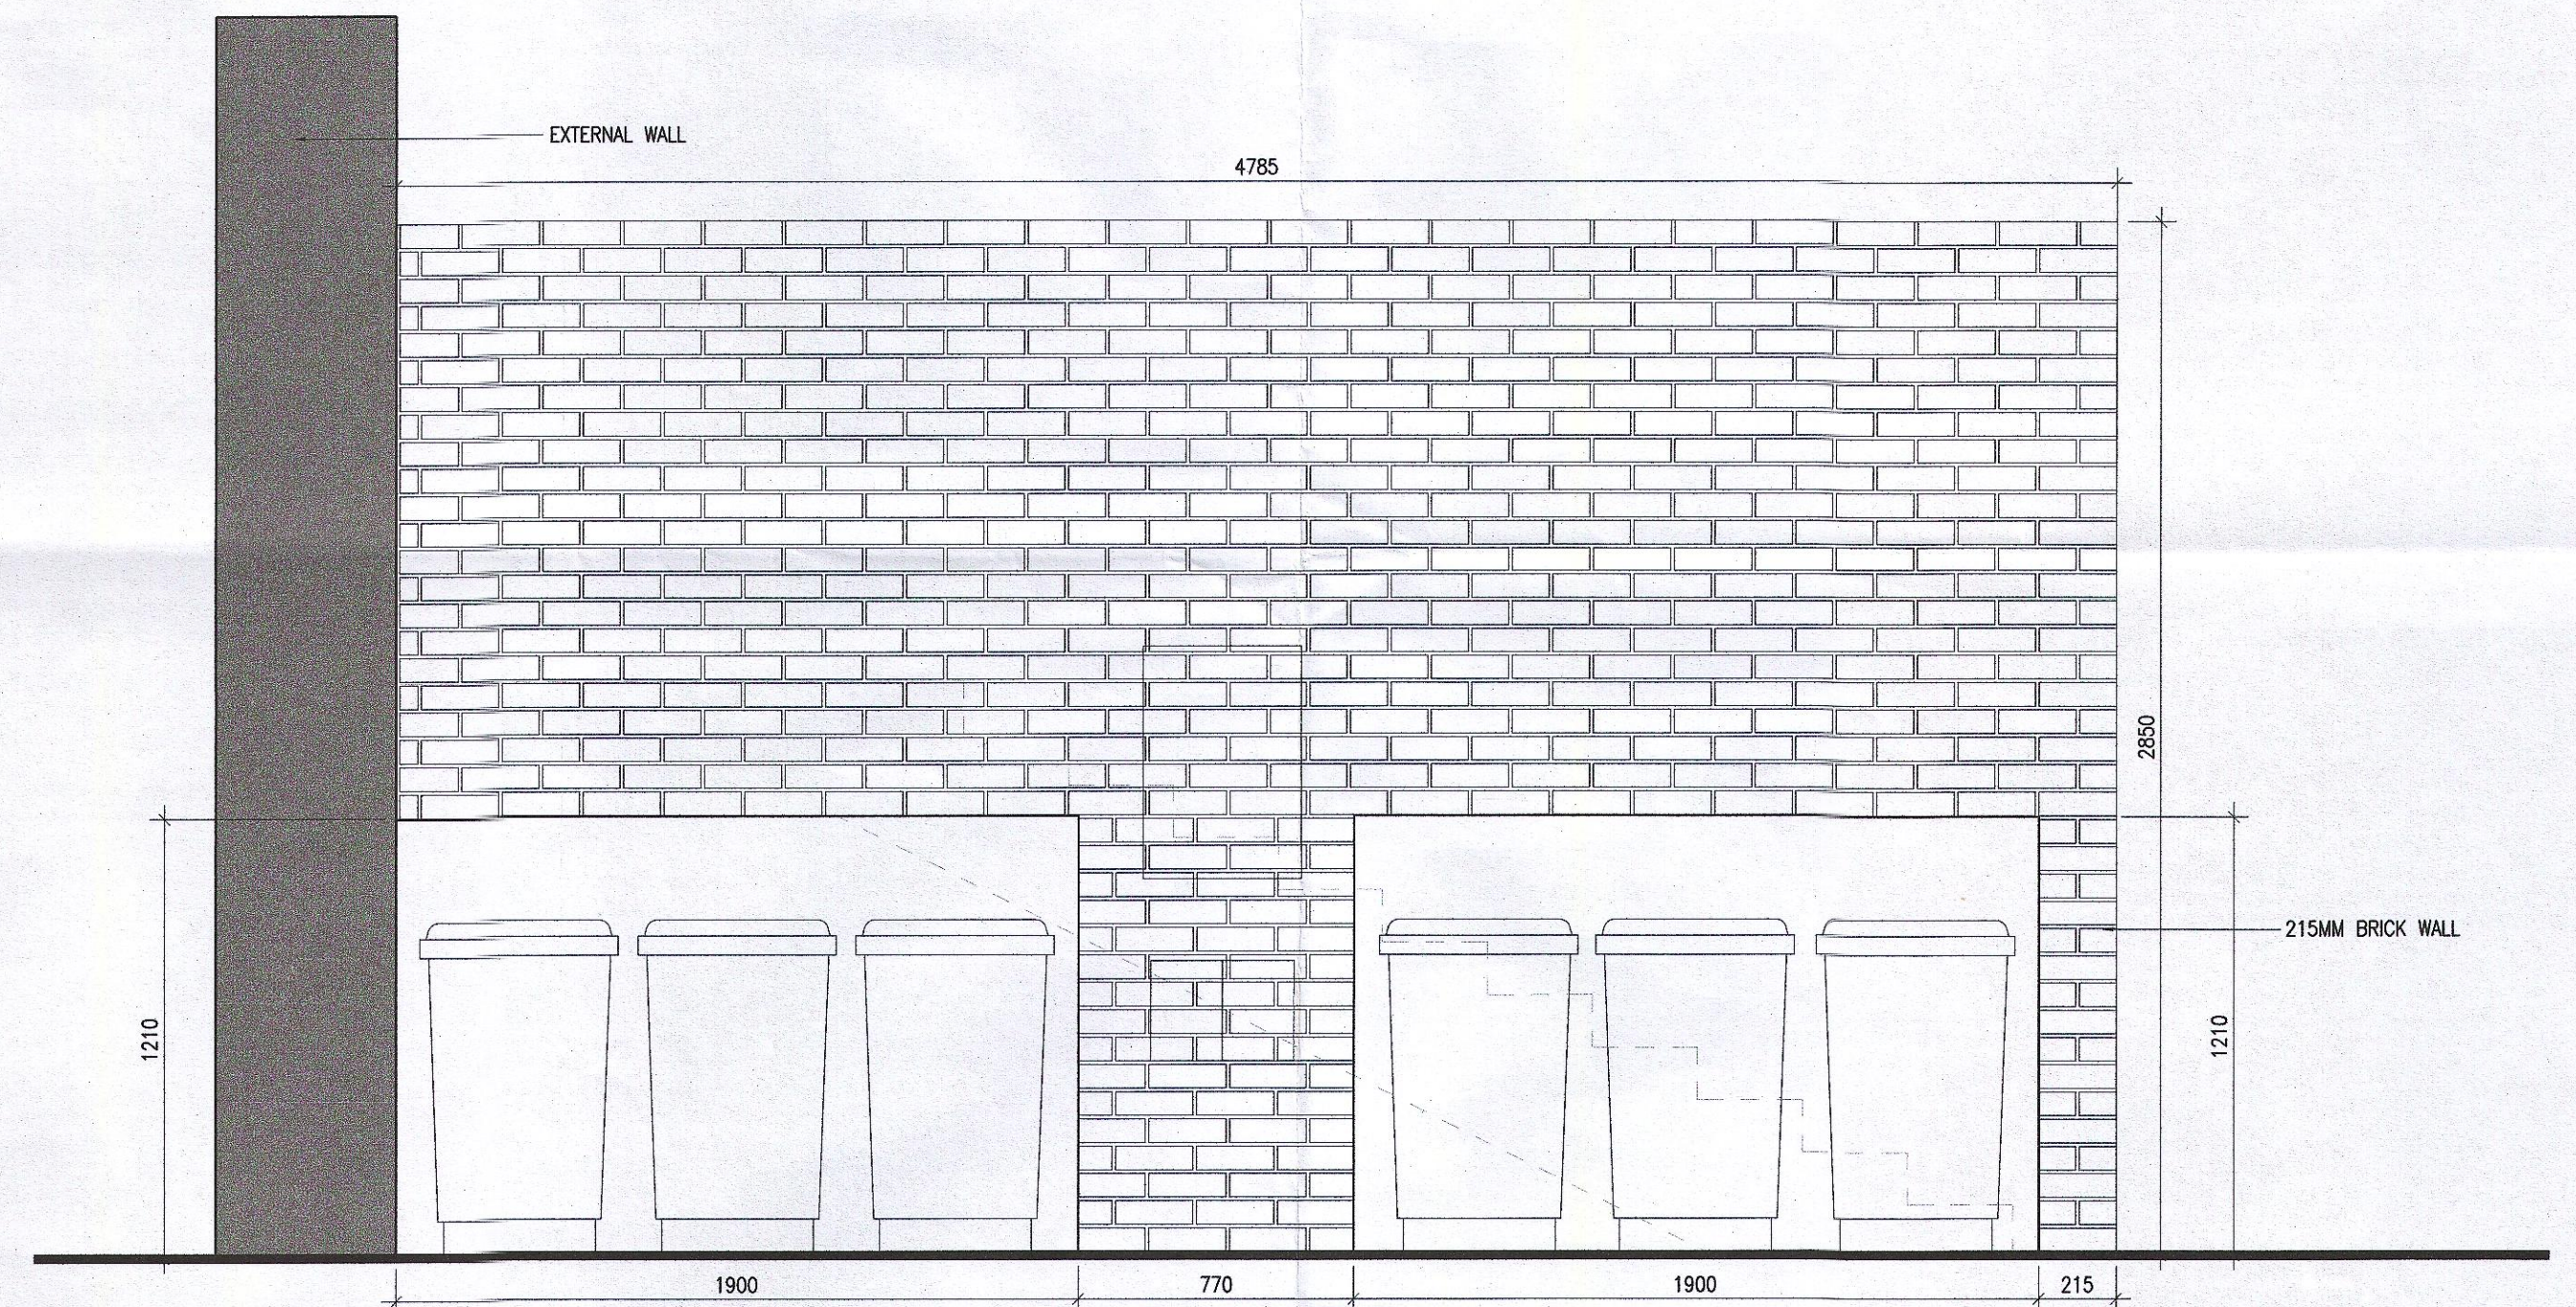

3 Bin store Type 4 Side Elevation  
704 Scale 1:20

- Notes
1. Copyright Reserved
  2. Work to signed dimensions only. Do not scale drawing
  3. The contractor is responsible for checking all levels and dimensions on site and shall refer all discrepancies to the Architect
  4. Where appropriate, for details of r.c. structure, or mechanical and electrical details, see Engineers drawings
  5. Proprietary items shall be fixed in strict accordance with manufacturers instructions.
  6. Sizes of proprietary items shall be checked with manufacturer.
  7. The contractor shall be responsible for the coordination of structure, finishes and services.

Issue Status	
Progress	
Planning Application	■
Fire Cert	
Disability Cert	
Tender	
Construction	
As Built	
Information Only	

No.	Date	Revision	Initials
01	27/01/23	Planning Application	RT

Project	Adamstown Extension - Clonburris SDZ Residential Development			6-7 HARCOURT TERRACE, DUBLIN 2, IRELAND T +353-1-916 2400 F +353-1-478 7865 e architecture@bkd.ie www.bkd.ie
Drawing Title	Bin store Details Type 4			
Drawing No	6268-P-704			
Scale	1:20@A1	Rev	01	Drawn RT Date Jan' 23