

REVISION SCHEDULE				
REV. NO.	REV. DESCRIPTION	REV. DATE	DRAWN	CHECKED
P01	ISSUED FOR PLANNING	16/06/2022	CG	JMM
P02	IRISH WATER APPLICATION	21/09/2022	CG	JMM
P03	ISSUED FOR PLANNING	30/11/2022	JOB	JMM
P04	ISSUED FOR PLANNING	07/12/2022	JOB	JMM
P05	ISSUED FOR PLANNING	27/01/2023	JM	JMM


DRAINAGE LEGEND

- FOUL SEWER (EXISTING)
- FOUL SEWER (NEW)
- FOUL SEWER (SLUNG FROM GROUND FLOOR SLAB)
- SURFACE WATER SEWER (EXISTING)
- SURFACE WATER SEWER (NEW)
- SURFACE WATER (SLUNG FROM GROUND FLOOR SLAB)
- GREY WATER SEWER (EXISTING)
- GREY WATER SEWER (NEW)
- FOUL SEWER RISING MAIN
- SURFACE WATER RISING MAIN
- GREY WATER RISING MAIN
- EXISTING SEWER TO BE DECOMMISSIONED
- EXISTING WATER MAIN
- PROPOSED WATER MAIN
- PROPOSED FLOOD PIPES
- FSMH (NEW FOUL SEWER MANHOLE)
- SWMH (NEW SURFACE WATER MANHOLE)
- FIRE HYDRANT

NEW SW SEWER NETWORK:
150Ø UPVC PIPES AT 1:150 FALLS TYPICALLY

NEW FSSEWER NETWORK:
150Ø UPVC PIPES AT 1:100 FALLS TYPICALLY

SEWER NETWORK TO BE INSTALLED IN ACCORDANCE WITH INVERT LEVELS AS SHOWN.

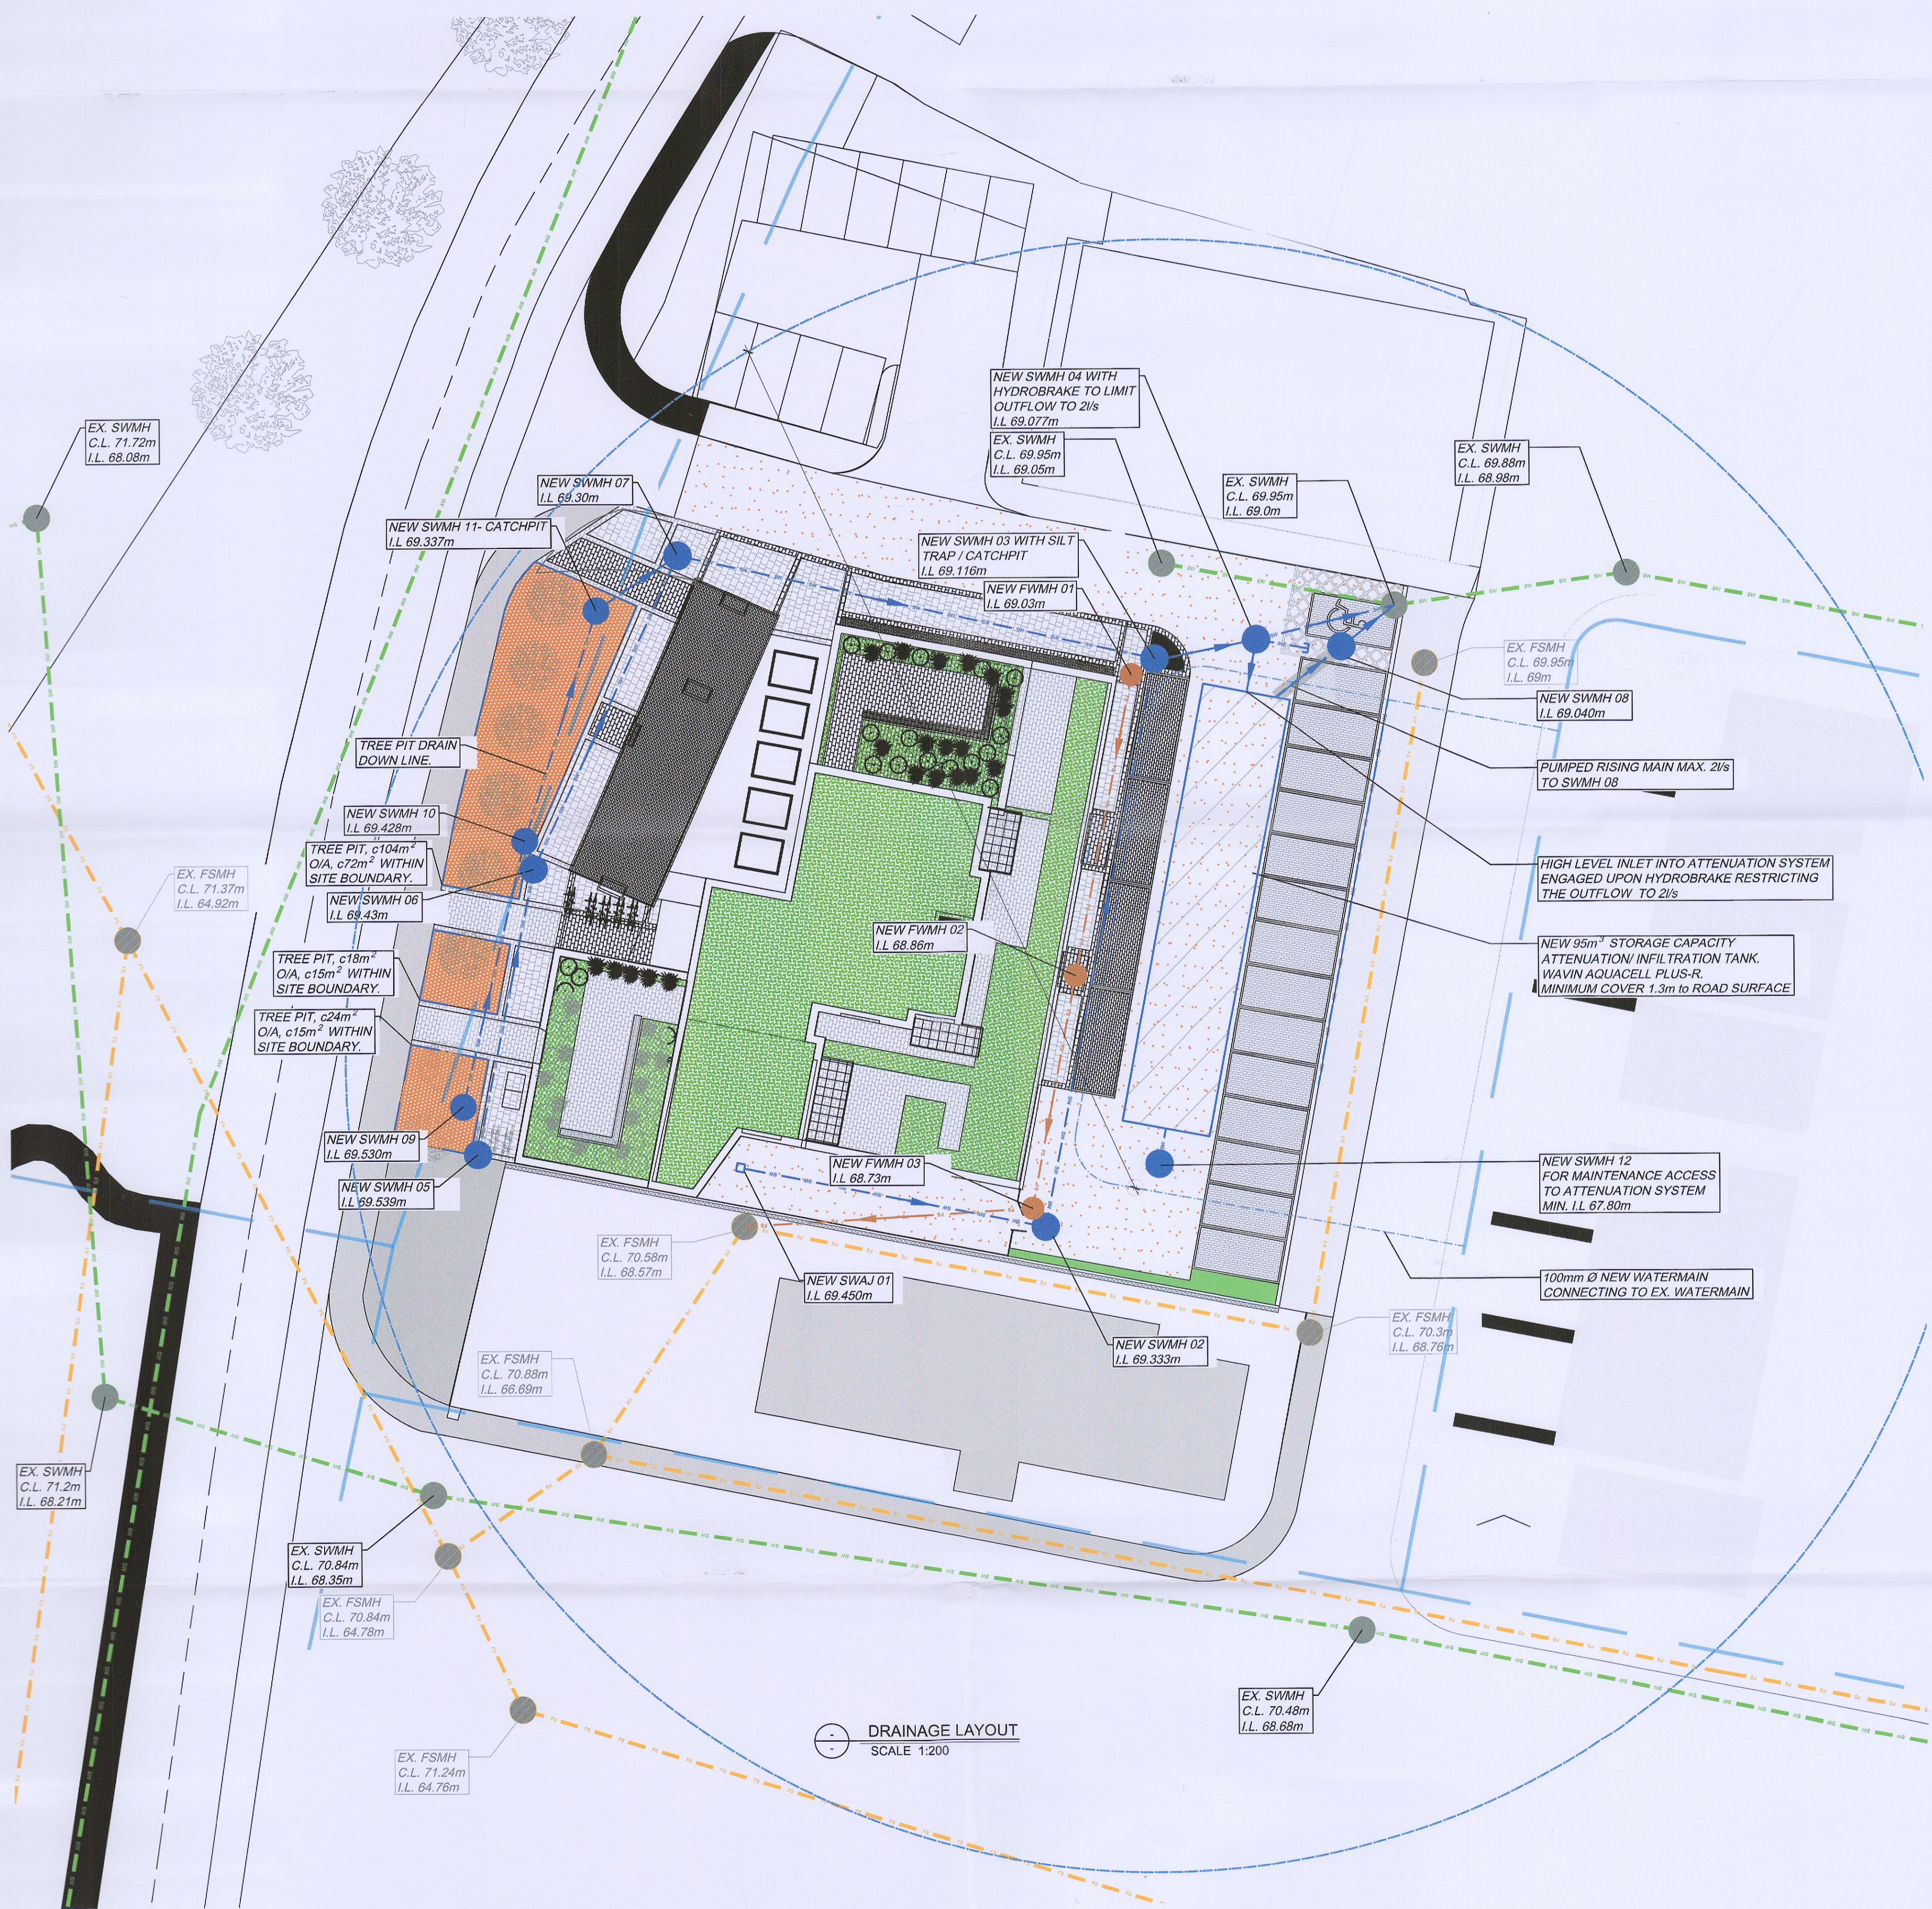

DRAINAGE LAYOUT
SCALE 1:200

Drawing Stage: PLANNING	Project Details:	Drawn by:	Checked by:	Approved by:	Date:		Behan House, 10 Lower Mount Street, Dublin 2, D02 HT71 Tel: +353 (0)1 661 1100 e-mail: info@cora.ie Web: www.cora.ie					
	Site Address:	CG	JMM	JMM	16/06/2022		CORR CONSULTING ENGINEERS	Project Number: 21816				
	Client:	Project Name: CUCKOO'S NEST			Scale: 1:200			Project Number: 21816	Drawing No: 101			
Architect:	Drawing Title: PROPOSED DRAINAGE LAYOUT PLAN			Project: 21816	Originator: CORA	Zone: ZZ	Level: 00	Type: DR	Discipline: C	Stage: 03	Revision: P05	
M&E Designer:	Contractor:											