






03 Elevation 03 - Road 5, 8 & 9
P021 Not To Scale

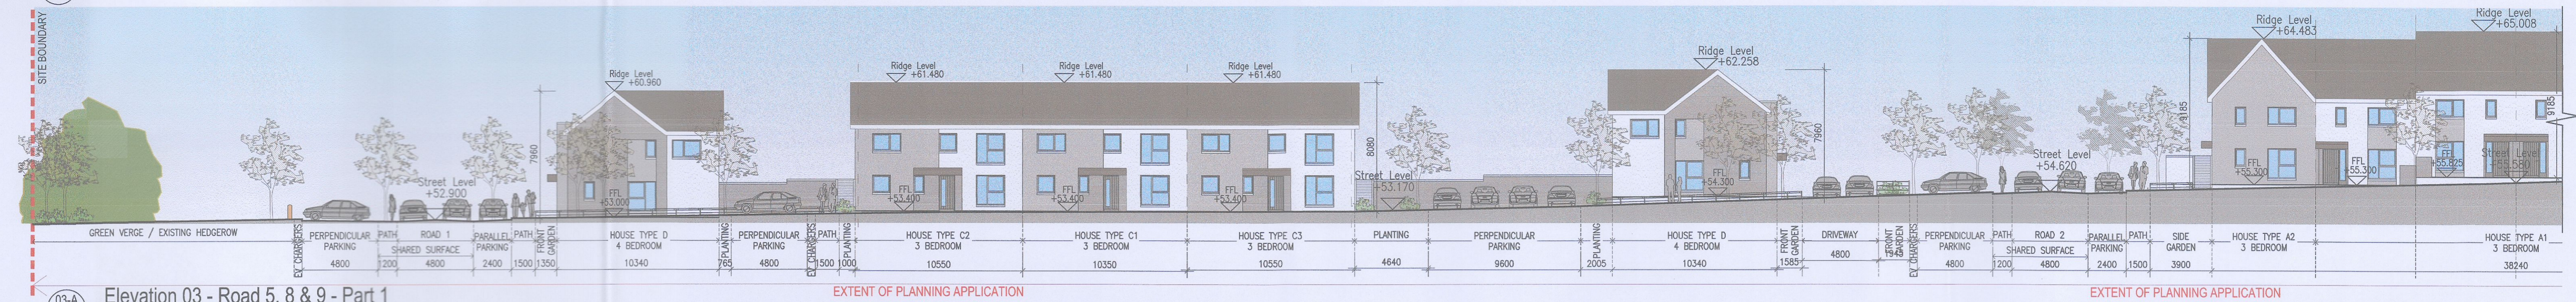

03-A Elevation 03 - Road 5, 8 & 9 - Part 1
P021 1:200 @ A1

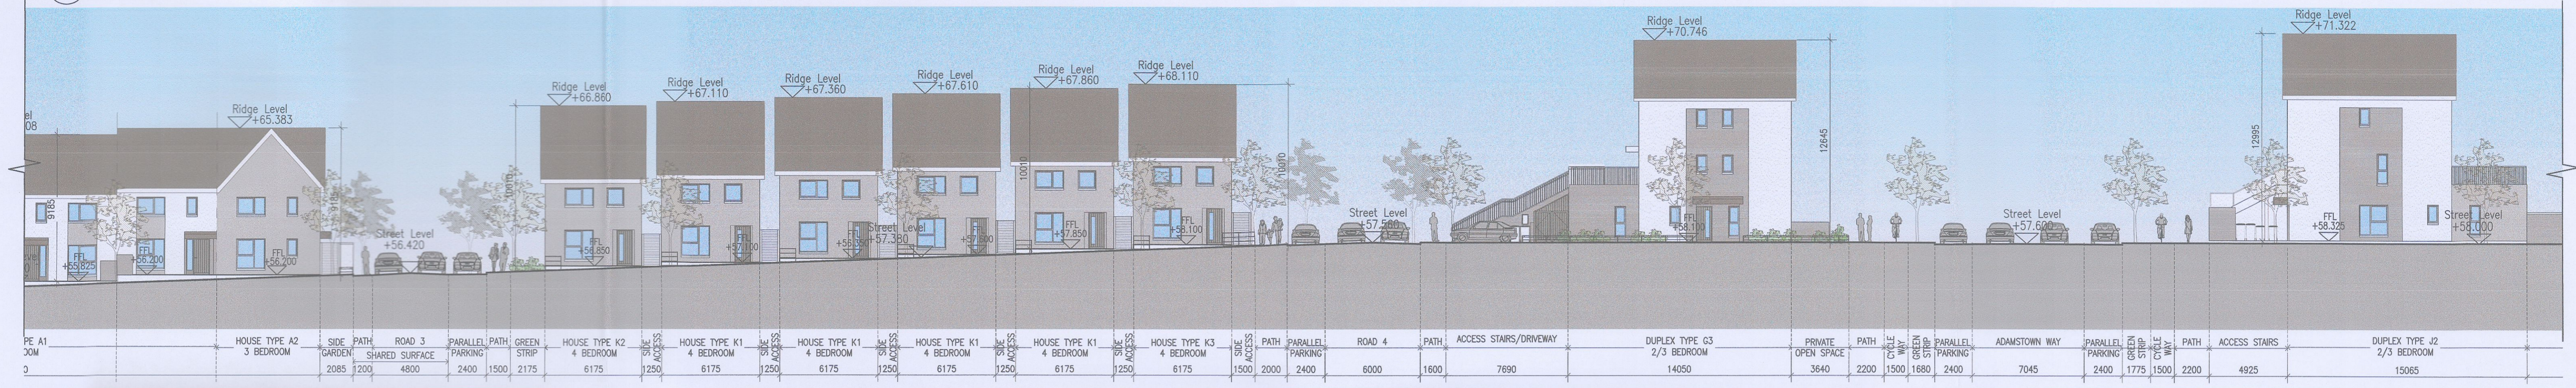

03-B Elevation 03 - Road 5, 8 & 9 - Part 2
P021 1:200 @ A1

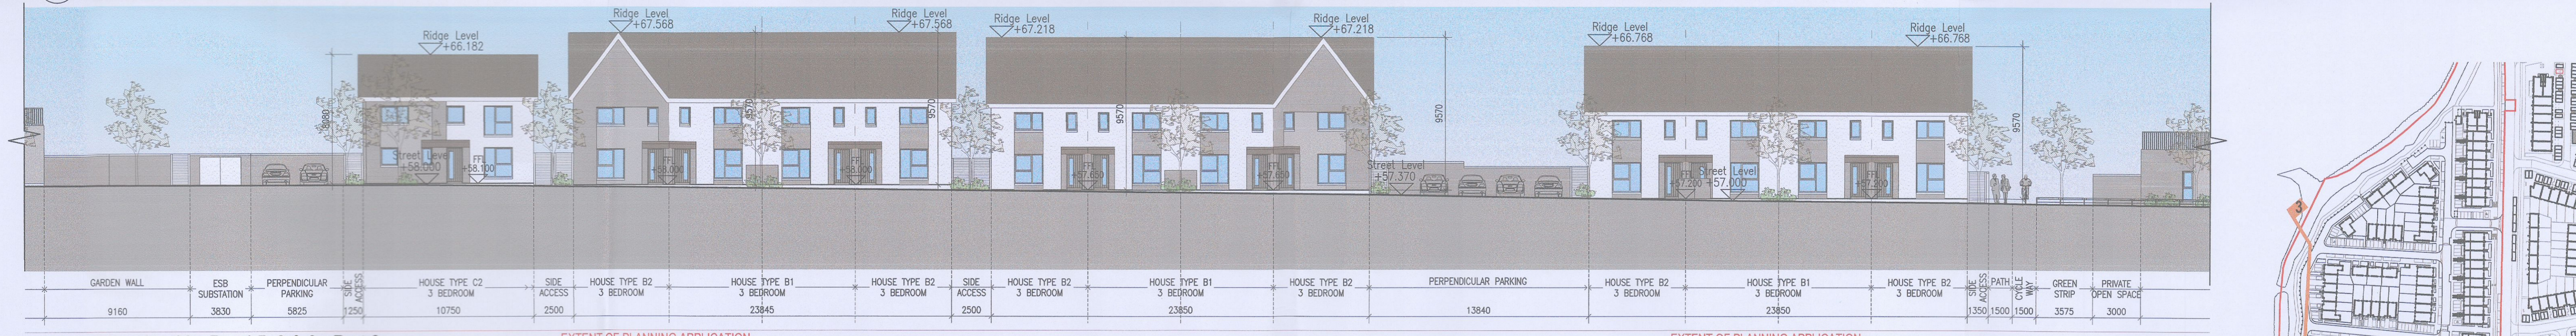


03-C Elevation 03 - Road 5, 8 & 9 - Part 3
P021 1:200 @ A1



03-D Elevation 03 - Road 5, 8 & 9 - Part 4
P021 1:200 @ A1

02 Elevation 02 - Road 9
P021 1:200 @ A1

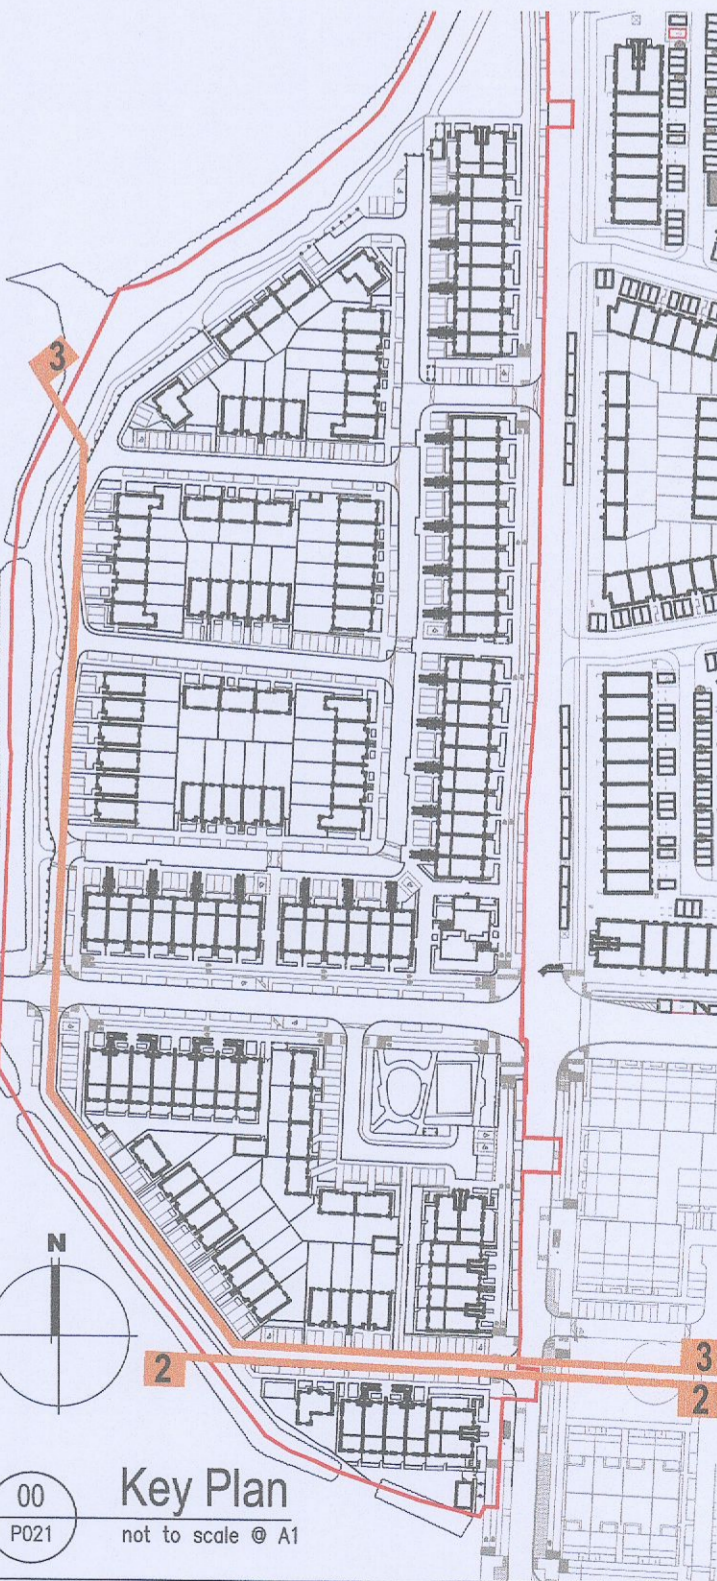

FOR MATERIAL REFERENCES PLEASE REFER TO UNIT TYPE DRAWINGS

- 1. Copyright Reserved
- 2. Work to figured dimensions only. Do not scale drawing.
- 3. The contractor is responsible for checking all levels and dimensions on site and shall refer all discrepancies to the Architect.
- 4. Where appropriate, for details of c. structure, or mechanical and electrical details, see Engineers drawings.
- 5. Proprietary items shall be fixed in strict accordance with manufacturers instructions.
- 6. Sizes of proprietary items shall be checked with manufacturer.
- 7. The contractor shall be responsible for the coordination of structure, finishes and services.

Issue Status	Progress
Planning Application	■
Fire Cert	
Disability Cert	
Tender	
Construction	
As Built	
Information Only	

No.	Date	Revision	Initials	Project
01	14.10.2022	ISSUED FOR PLANNING	JN	Aderrig Phase 3 Adamstown SDZ Residential Development
02	16.03.2023	ISSUED FOR PLANNING RPI	ED	

Drawing Title: Contiguous Street Elevation Sheet 2 of 9
 Drawing No: 6259A-P-021
 Scale: 1:200 @ A1 Rev: 02 Drawn: JN; ED Date: MAR 2023

bkdarchitects
 BURKE-KENNEDY DOYLE

6-7 HARCOURT TERRACE, DUBLIN 2, IRELAND
 T: +353-1-616 2400 F: +353-1-616 7265
 www.bkd.ie