

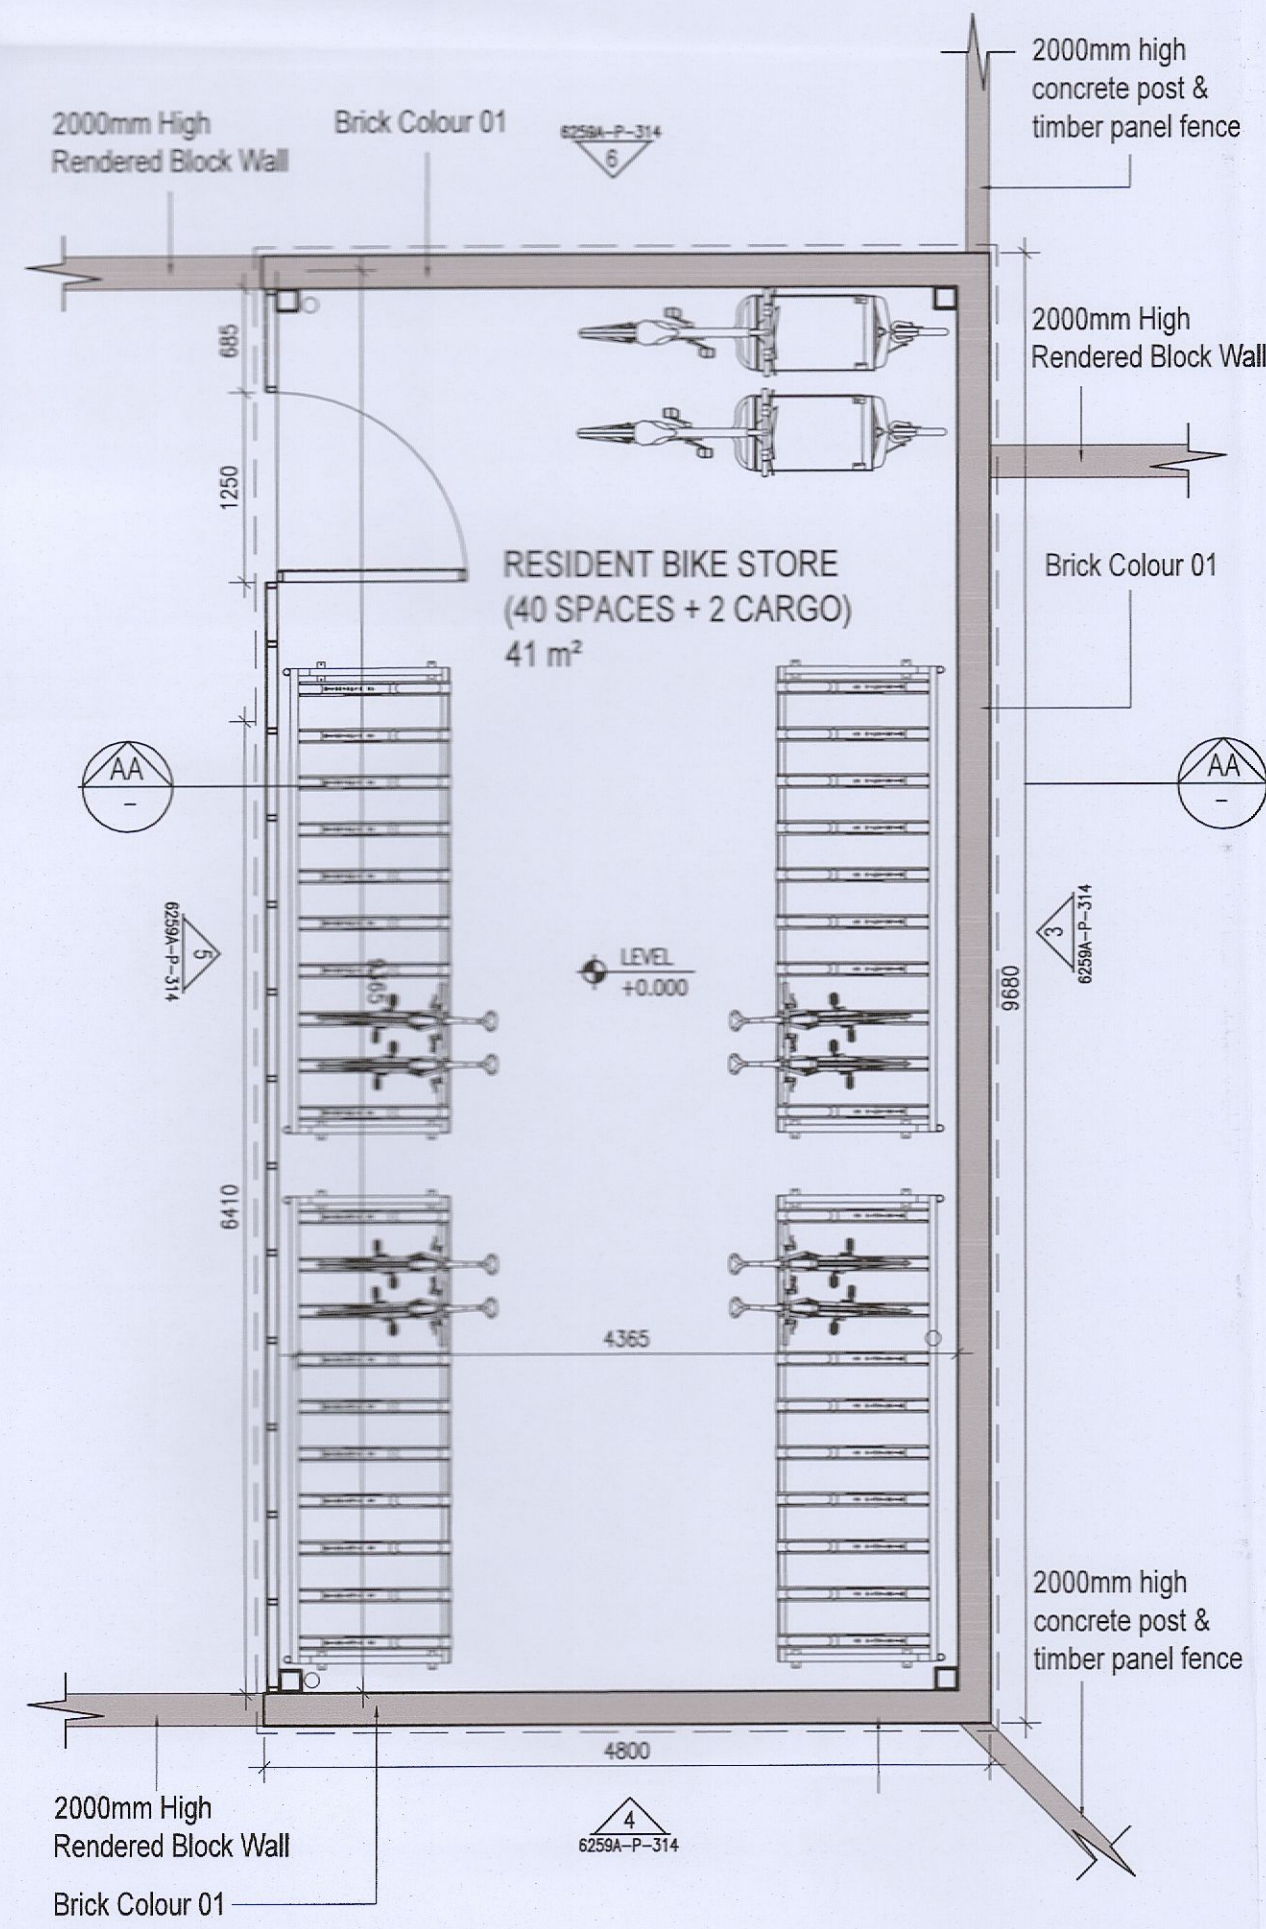
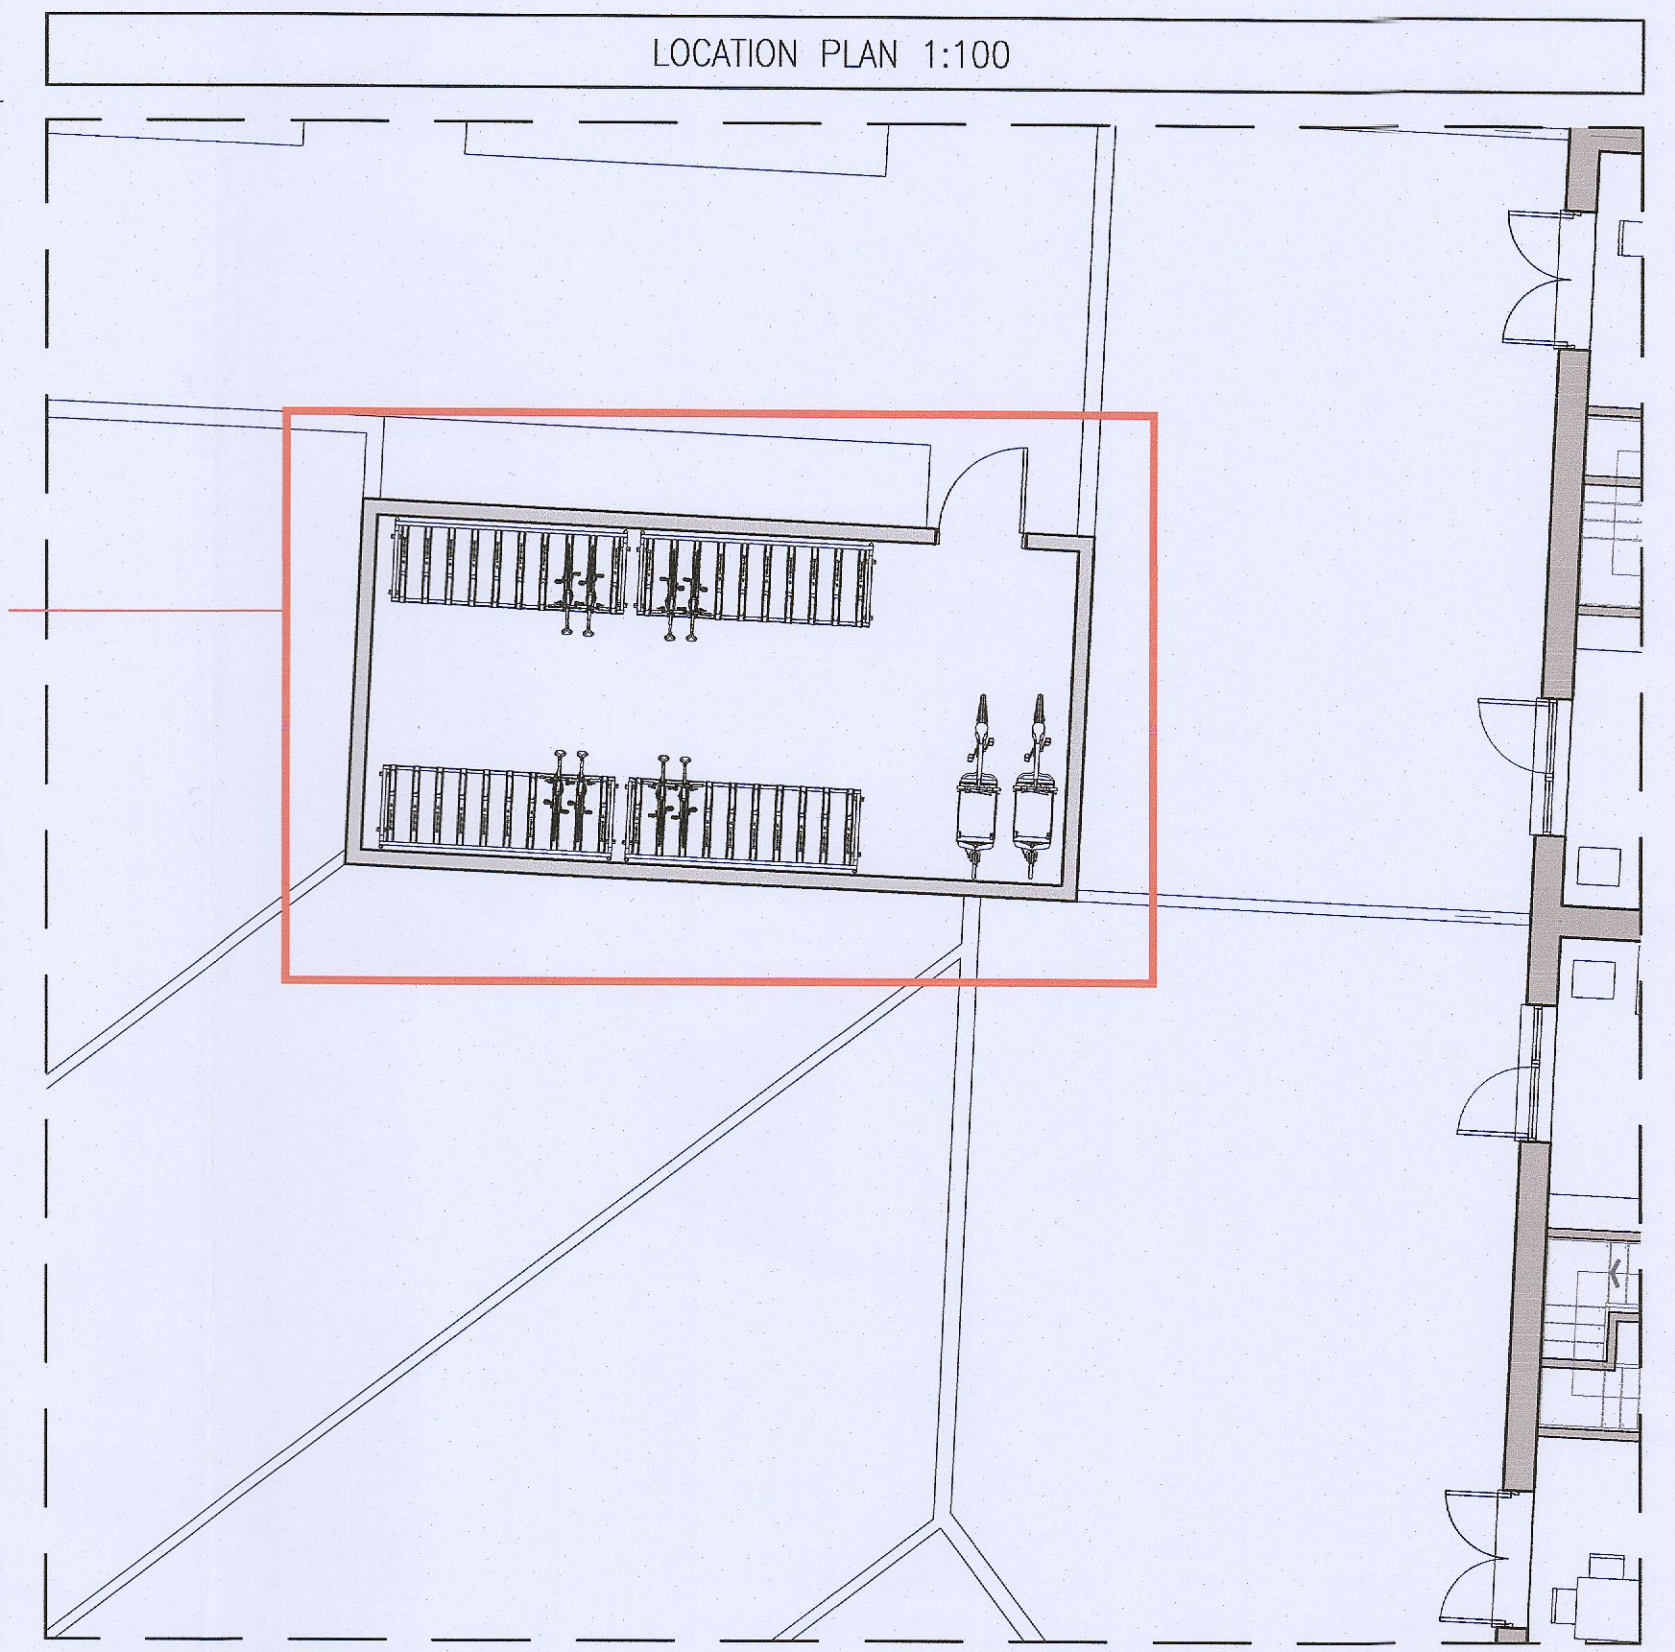



TYPE 3
Communal Bike Store

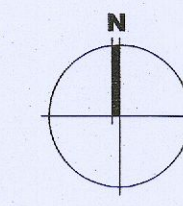


1 Bike Store Type 3 Plan
Scale 1:50

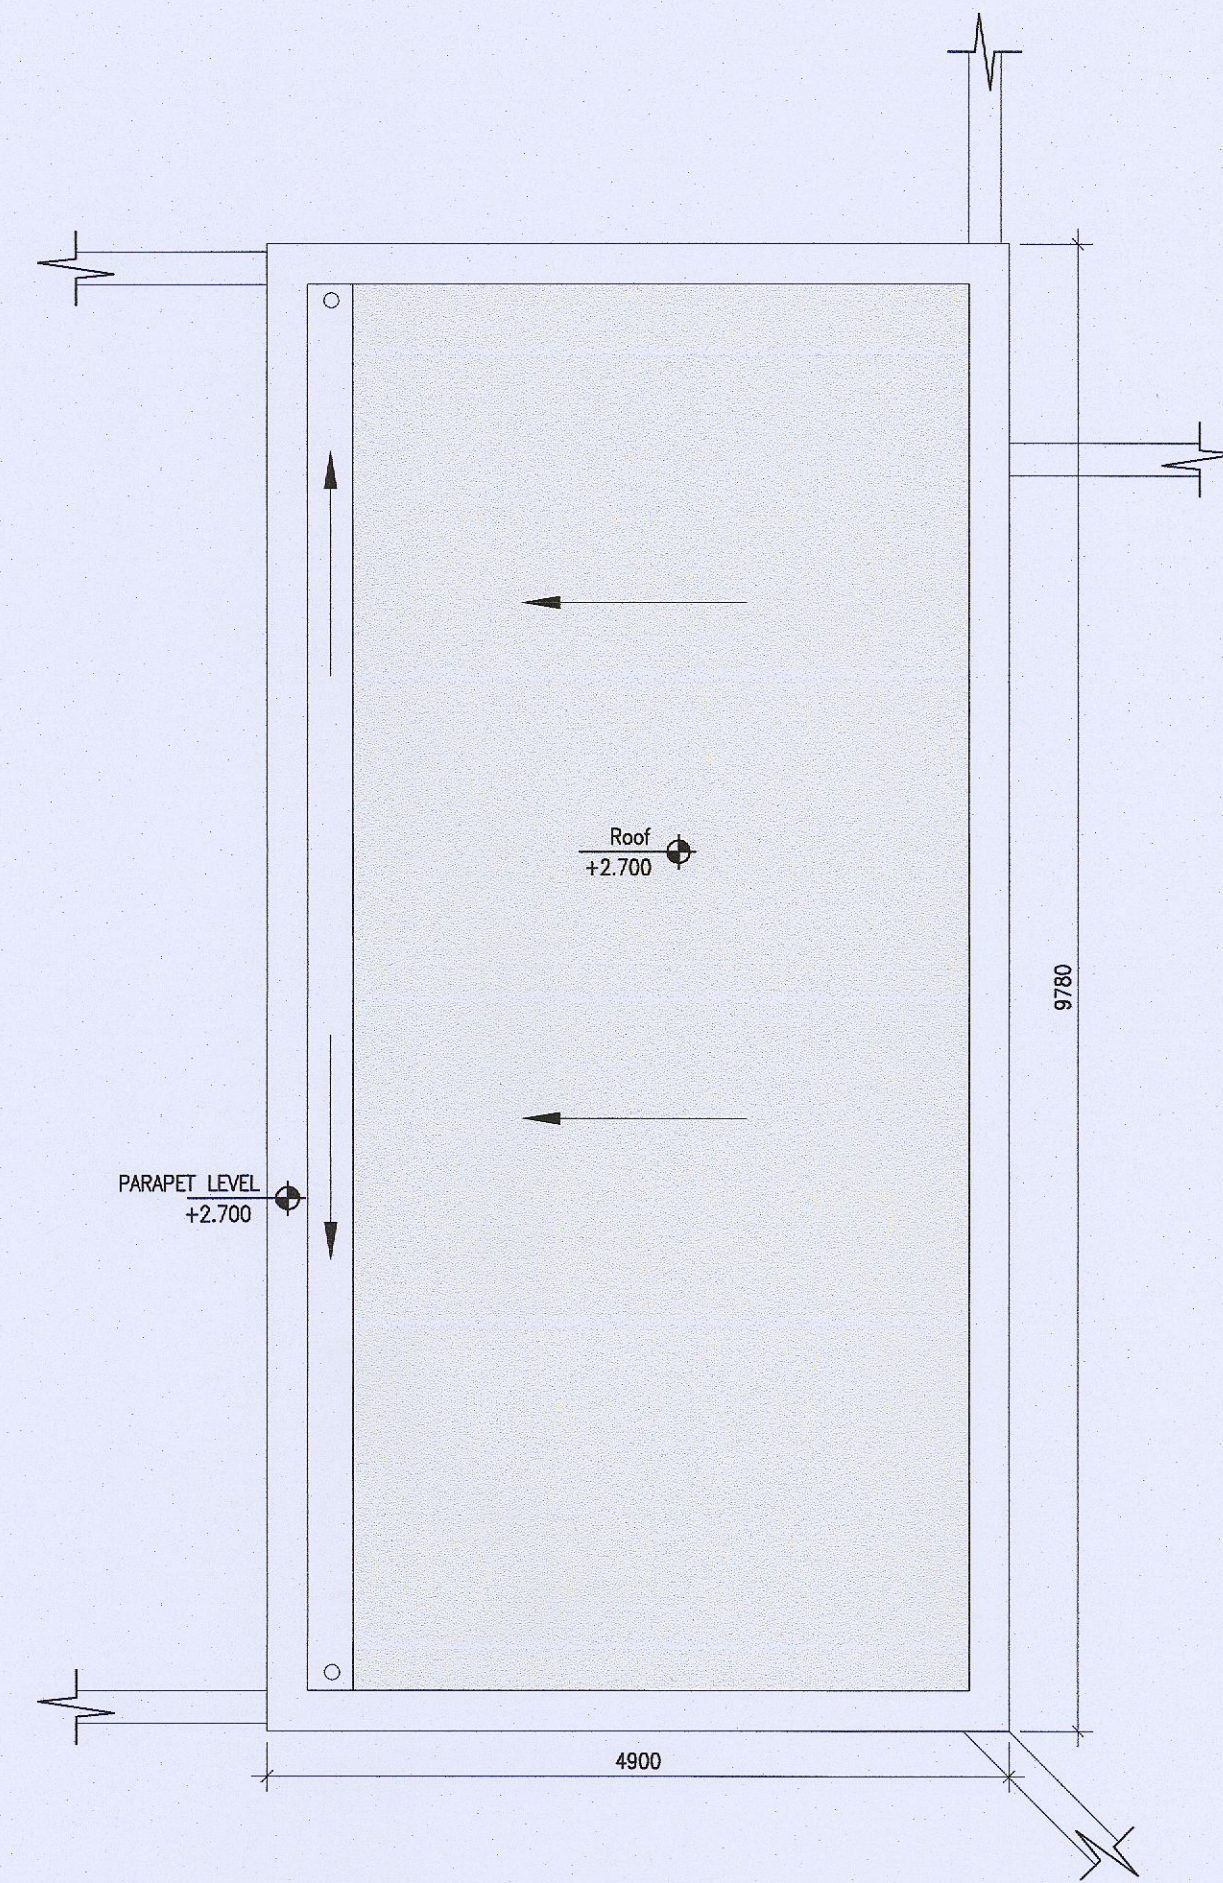


2 Bike Store Type 3 Roof Plan
Scale 1:50

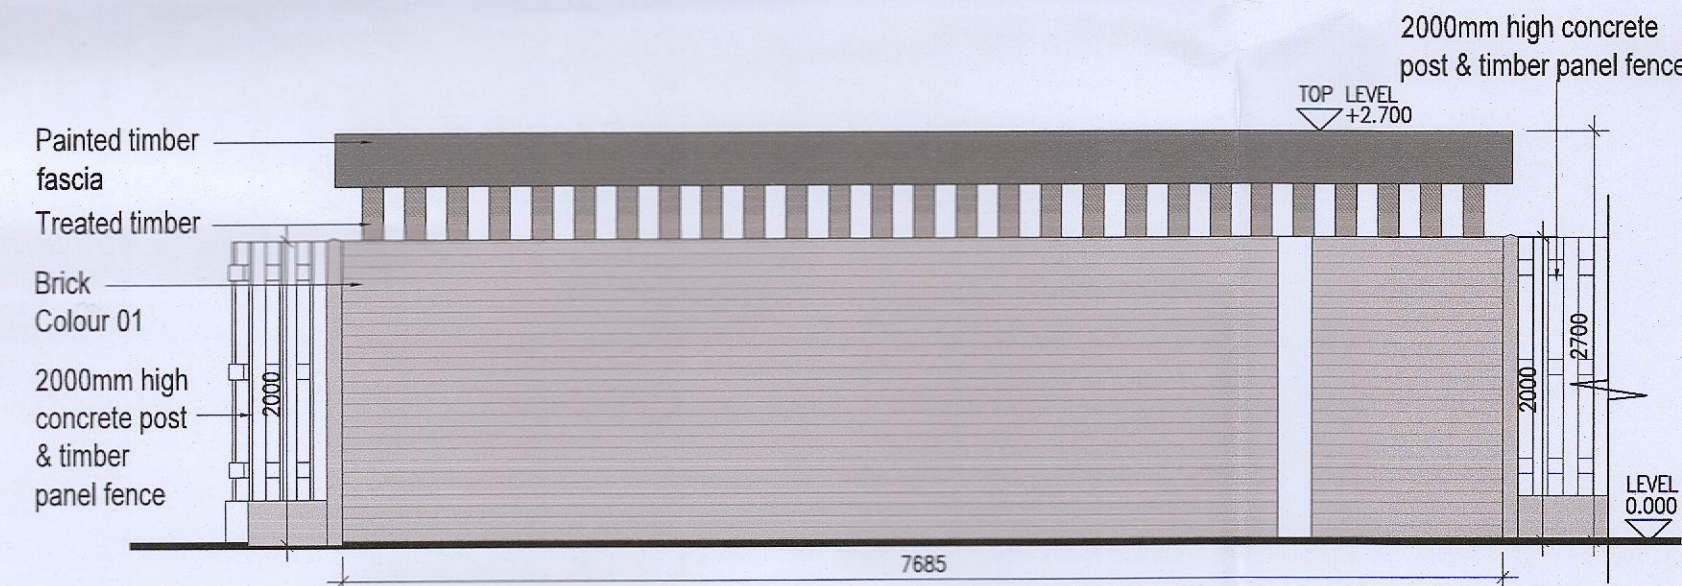


3 Bike Store Type 3 Rear Elevation
Scale 1:50

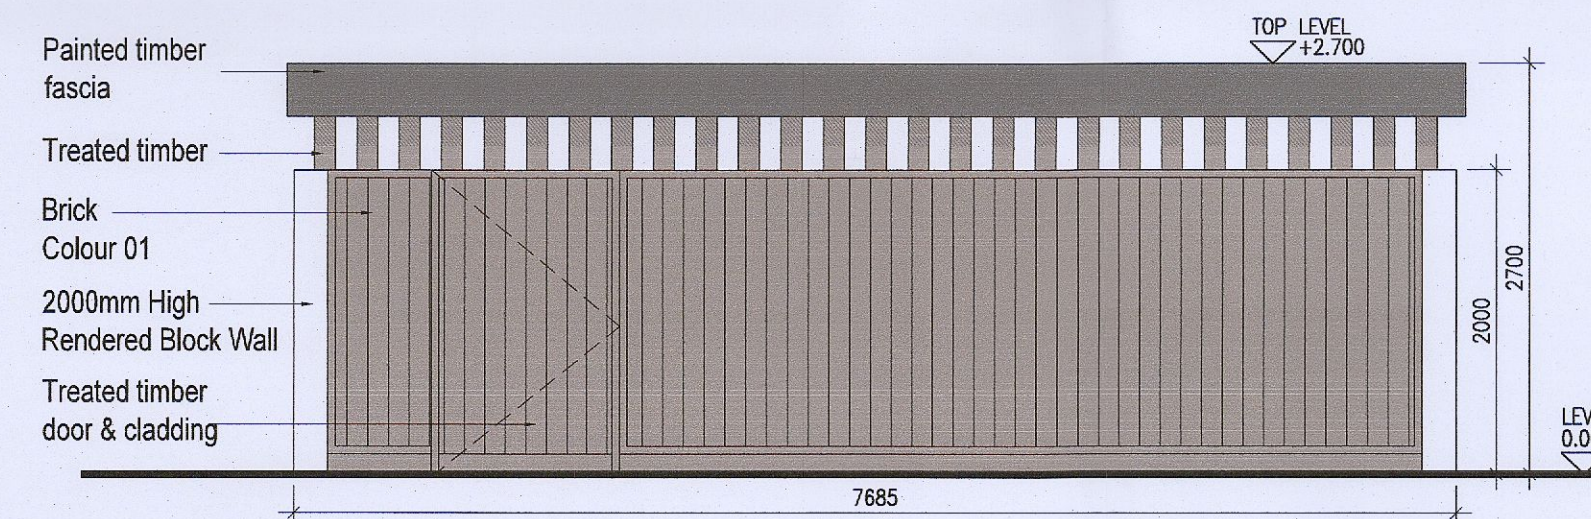


5 Bike Store Type 3 Front Elevation
Scale 1:50

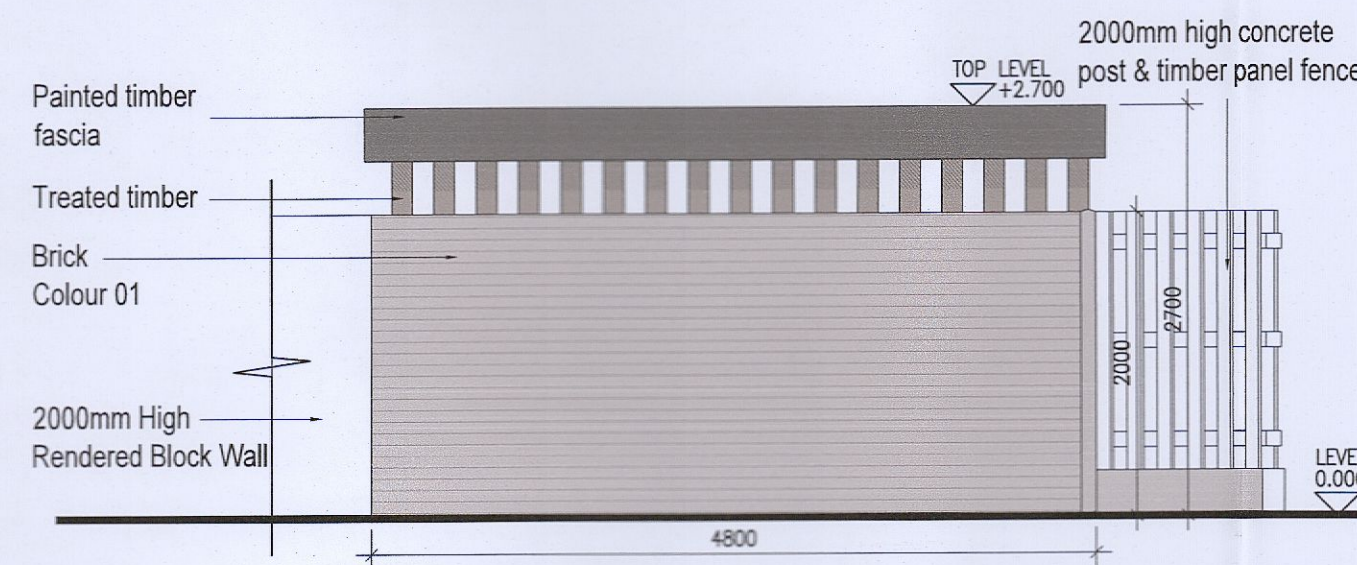

4 Bike Store Type 3 Side Elevation 01
Scale 1:50

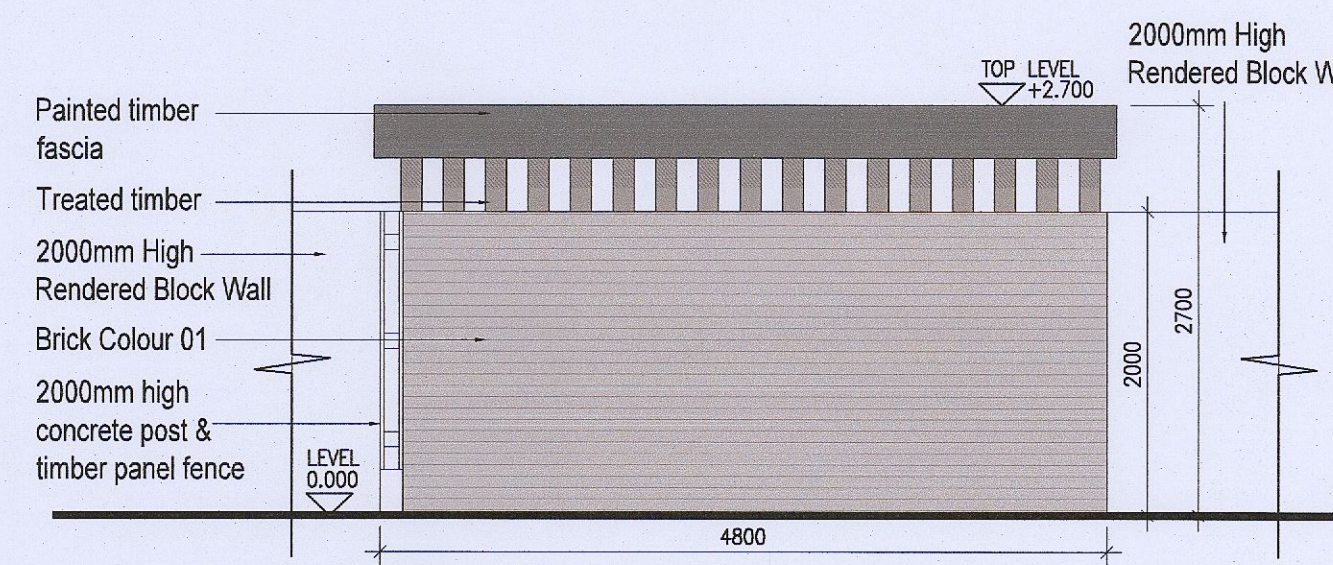

6 Bike Store Type 3 Side Elevation 02
Scale 1:50

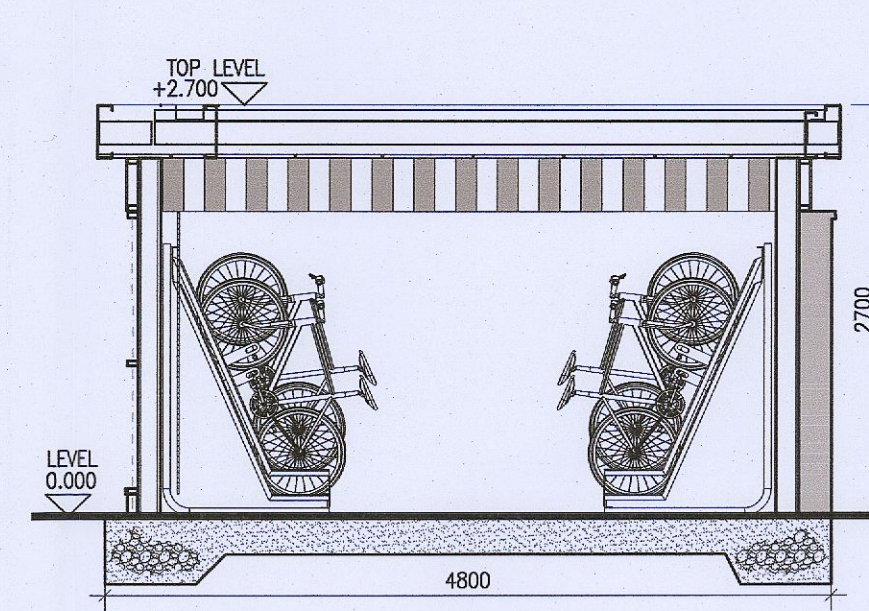

7 Bike Store Type 3 Section AA
Scale 1:50

Notes
1. Copyright Reserved
2. Work to figured dimensions only. Do not scale drawing.
3. The contractor is responsible for checking all levels and dimensions on site and shall refer all discrepancies to the Architect.
4. Where appropriate, for details of c. structure, or mechanical and electrical details, see Engineers drawings.
5. Proprietary items shall be fixed in strict accordance with manufacturers instructions.
6. Sizes of proprietary items shall be checked with manufacturer.
7. The contractor shall be responsible for the coordination of structure, finishes and services.

Issue Status	Initials
Progress	
Planning Application	
Fire Cert	
Disability Cert	
Tender	
Construction	
As Built	
Information Only	

No	Date	Revision	Initials
01	10.10.2022	ISSUED FOR PLANNING	AM
02	09.03.2023	ISSUED FOR PLANNING RFI	ED

Project	Aderrig Phase 3, Adamstown SDZ Residential Development
Drawing Title	Bike Store Details Type 3
Drawing No	6259A-P-312
Scale	1:50 @A1
Rev	02
Drawn	EPS, ED
Date	MAR 2023

6-7 HARCOURT TERRACE, DUBLIN 2, IRELAND
t +353-1-618 2000 f +353-1-678 7555
e architecture@bkd.ie
www.bkd.ie

bkdarchitects
BURKE-KENNEDY DOYLE