


Proposed Block Plan & Drainage Layout
SCALE 1:200

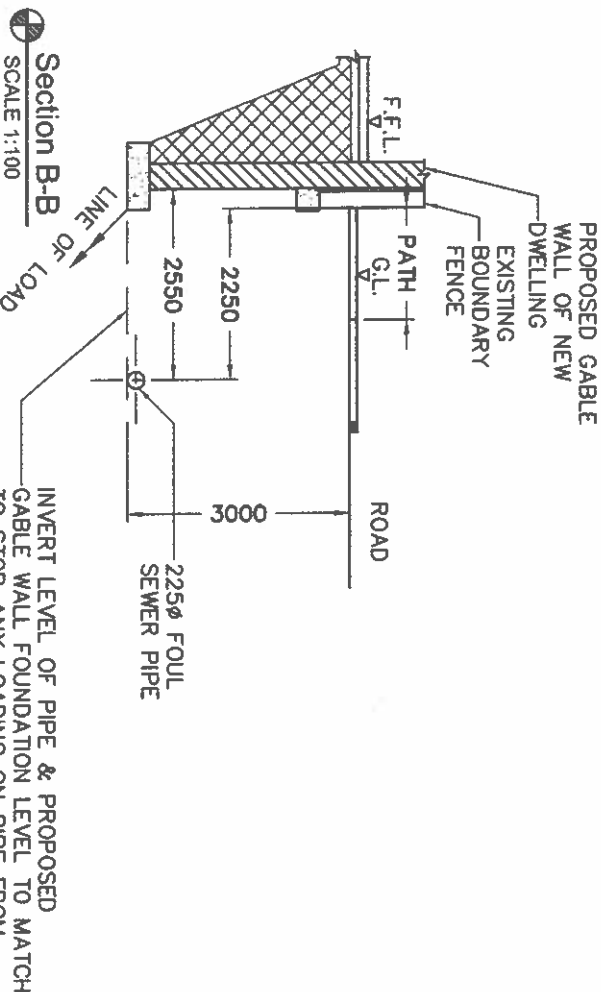

DRAINAGE LEGEND

- PROPOSED 150Ø UPVC SURFACE WATER PIPE
- PROPOSED 150Ø UPVC FOUL SEWER PIPE
- EXISTING SURFACE WATER PIPE
- EXISTING FOUL SEWER PIPE

ISSUED FOR COMPLIANCE WITH PART 2 OF CONDITIONS
'REMOVAL OF SIDE ACCESS GATE' ON PLANNING PERMISSION
REF: SD22B/0519

P1	SIDE ACCESS GATE REMOVED FROM SIDE BOUNDARY WALL	ND	March 2023
P	ISSUED FOR PLANNING	ND	DEC' 2022
REV:	REVISION TITLE:	DRN: CHD: DATE:	

AA Architecture

4 CARRIGMORE CLOSE, AYLESBURY,
Dublin 24 - Ph: 01 4148358

CLIENT: PAUL & REBECCA CONNOR

JOB TITLE: PROPOSED WORKS AT 114A TEMPLEOGUE
WOOD, TEMPLEOGUE, DUBLIN 6W

TITLE: PROPOSED BLOCK PLAN,
DRAINAGE LAYOUT & SECTION

SCALE:	INITIALS:	DATE:
1:200	ND	NOV' 2022
JOB No: S284	DRAWING No: 003	REV: P1

NOTES:

This drawing is to be read in conjunction with all relevant Engineers drawings.
Do not scale use figured dimensions ONLY.
All dimensions in millimeters unless otherwise stated.
All dimensions to be checked on site.
All building works to comply with current building regulations & in accordance with Homebond Standards.

THIS DRAWING IS ISSUED FOR PLANNING PERMISSION ONLY, AND IS NOT A CONSTRUCTION DRAWING