 


CATCHMENT CHARACTERISTICS			
SURFACE TYPE	GROSS AREA (ha)	RUNOFF CO-EFFICIENT	IMPERMEABLE AREA (ha)
ROOFS	0.508	0.95	0.482
GREEN ROOFS	0.098	0.80	0.079
HARD SURFACING (ROADS, FOOTPATHS)	0.941	1.00	0.941
PERMEABLE PAVING	0.204	0.70	0.143
PUBLIC OPEN SPACE (SOFT LANDSCAPING)	1.699	0.10	0.170
TOTAL	3.450		1.815

ON ORIGINAL




© COPYRIGHT OF THIS DRAWING IS RESOLVED BY DBFL CONSULTING ENGINEERS. NO PART SHALL BE REPRODUCED OR TRANSMITTED WITHOUT THEIR WRITTEN PERMISSION.

NO CHANGES OF WHATSOEVER NATURE ARE TO BE MADE TO ANY DETAILS SET OUT OR CONTAINED IN ANY DBFL SPECIFICATIONS OR DRAWINGS UNLESS THE EXPRESS CONSENT HAS BEEN OBTAINED IN ADVANCE, IN WRITING, FROM DBFL.

NOTES:

LEGEND

- SITE BOUNDARY
- HARD LANDSCAPING (ROADS, FOOTPATHS)
- PERMEABLE PAVING
- PUBLIC OPEN SPACE (SOFT LANDSCAPING)
- GREEN ROOFS
- ROOFS
- PROPOSED SWALE. REFER TO DRAINAGE LAYOUT DRAWING CLB-T3-94-SW-DTM-DR-DBFL-CE-1311 FOR DETAILS

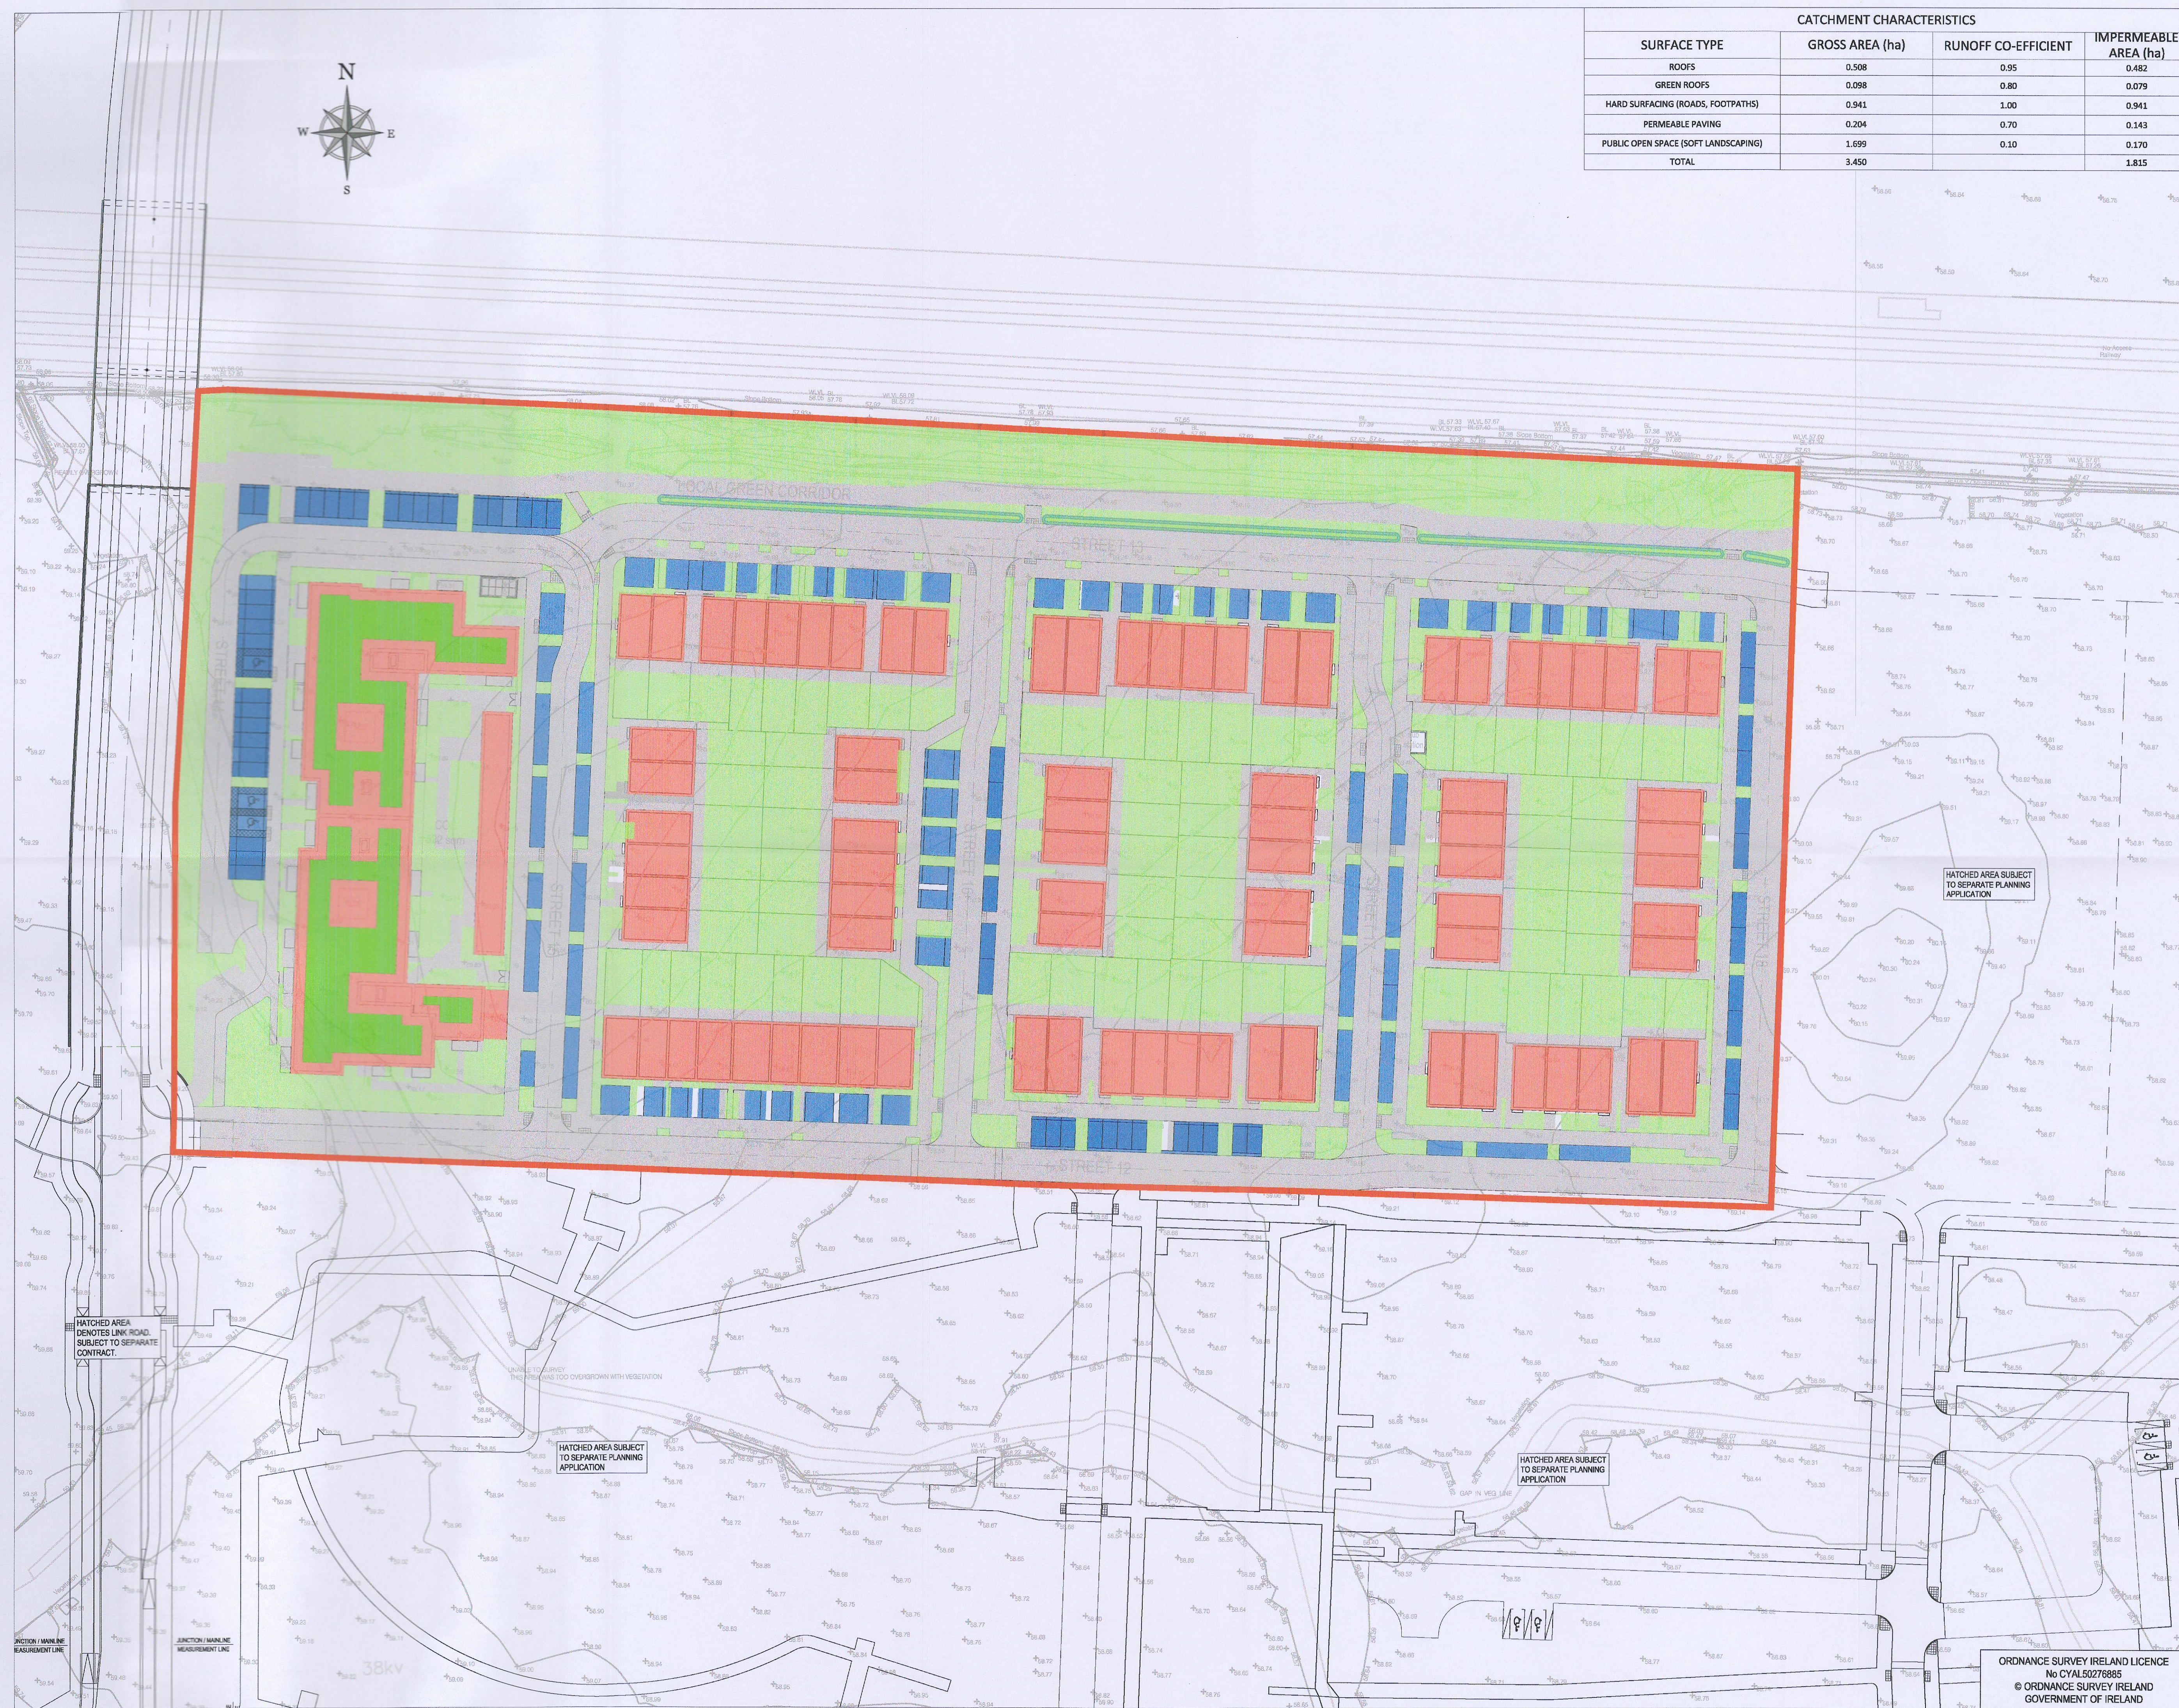

HATCHED AREA SUBJECT TO SEPARATE PLANNING APPLICATION

HATCHED AREA DENOTES LINK ROAD. SUBJECT TO SEPARATE CONTRACT.

HATCHED AREA SUBJECT TO SEPARATE PLANNING APPLICATION

HATCHED AREA SUBJECT TO SEPARATE PLANNING APPLICATION

rev	date	description	by	chkd.
4	12-04-23	ISSUED FOR PLANNING	RMC	DCB
3	25-11-22	ISSUED FOR PLANNING	DKE	DCB
2	04-11-22	ISSUED FOR PLANNING	DKE	DCB
1	21-10-22	FINAL PLANNING DRAFT	BS	DCB
0	10-10-22	ISSUED FOR PLANNING	BS	DCB

STATUS CODES
purpose acceptance
P1 - INFORMATION S - ISSUED

DBFL Consulting Engineers
Civil, Structural & Transportation Engineering
www.dbfl.ie

DUBLIN OFFICE: Grand Canal, Upper Ormond Quay, Dublin 7, D07 W0X4
PHONE: +353 1 627 6007
CORK OFFICE: 14 South Mall, Cork, T12 C191
PHONE: +353 21 334038

WATERFORD OFFICE: Suite 8b The Arkun, Maritime Gate, Canada Street, Waterford, X91 W028
PHONE: +353 51 309 500

project ref.
CLONBURRIS TILE 3
drawing title
SURFACE WATER CATCHMENT PLAN
client
CAIRN HOMES PROPERTIES LTD

designed by	author	scale	sheet size
DCB	BS	1:500	A1
drawing no.	revision		
CLB-T3-94-SW-DTM-DR-DBFL-CE-1321	4		

ORDNANCE SURVEY IRELAND LICENCE
No CYAL50276885
© ORDNANCE SURVEY IRELAND
GOVERNMENT OF IRELAND