


- DRAWINGS NOTES:**
1. LIGHTING TO BE SUPPLIED VIA A SOLAR TIME CLOCK WITHIN EACH PUBLIC LIGHTING MINI PILLAR.
 2. A MAXIMUM OF 6No. LUMINAIRES PER CIRCUIT & 4No. CIRCUITS PER PUBLIC LIGHTING MINI PILLAR.
 3. LIGHT POLES HEIGHT AS PER THE LEGEND DESCRIPTION BELOW WITH A 1 METRE OUTREACH BRACKET & SETBACK 1 METRE FROM KERB.
 4. ALL COLUMNS TO BE FINISHED TO BE AT LEAST 1 METRE CLEAR OF ALL OVERHEAD HIGH VOLTAGE POWER LINES.
 5. FOR SCHEDULES OF EQUIPMENT SEE SPECIFICATION.
 6. THE COMPLETE INSTALLATION TO BE CO-ORDINATED WITH ALL OTHER SERVICES.


- LEGEND OF SYMBOLS:**
- B1 COLUMN 6M POLE MOUNTED ROAD LIGHT WITH 1M OUTREACH
MODEL: LUMINISTREET GEN2 MINI BGP292 2550_8500_40LED_5-25 CLO L90 730_8.50 FLUX KLM
 - A1 COLUMN 8M POLE MOUNTED ROAD LIGHT WITH 1M OUTREACH
MODEL: LUMINISTREET GEN2 MINI BGP292 2550_8500_40LED_5-25 CLO L90 730_8.50 FLUX KLM
 - C1 DECORATIVE POST-TOP LANTERN WITH SYMMETRIC DISTRIBUTION
MODEL: AVF 18150-740 RS CL BPS CL1 CON ANT T60
 - 600x600mm CABLE DRAW PIT/MANHOLE
 - PUBLIC LIGHTING MINI PILLAR
 - PUBLIC LIGHTING DUCT

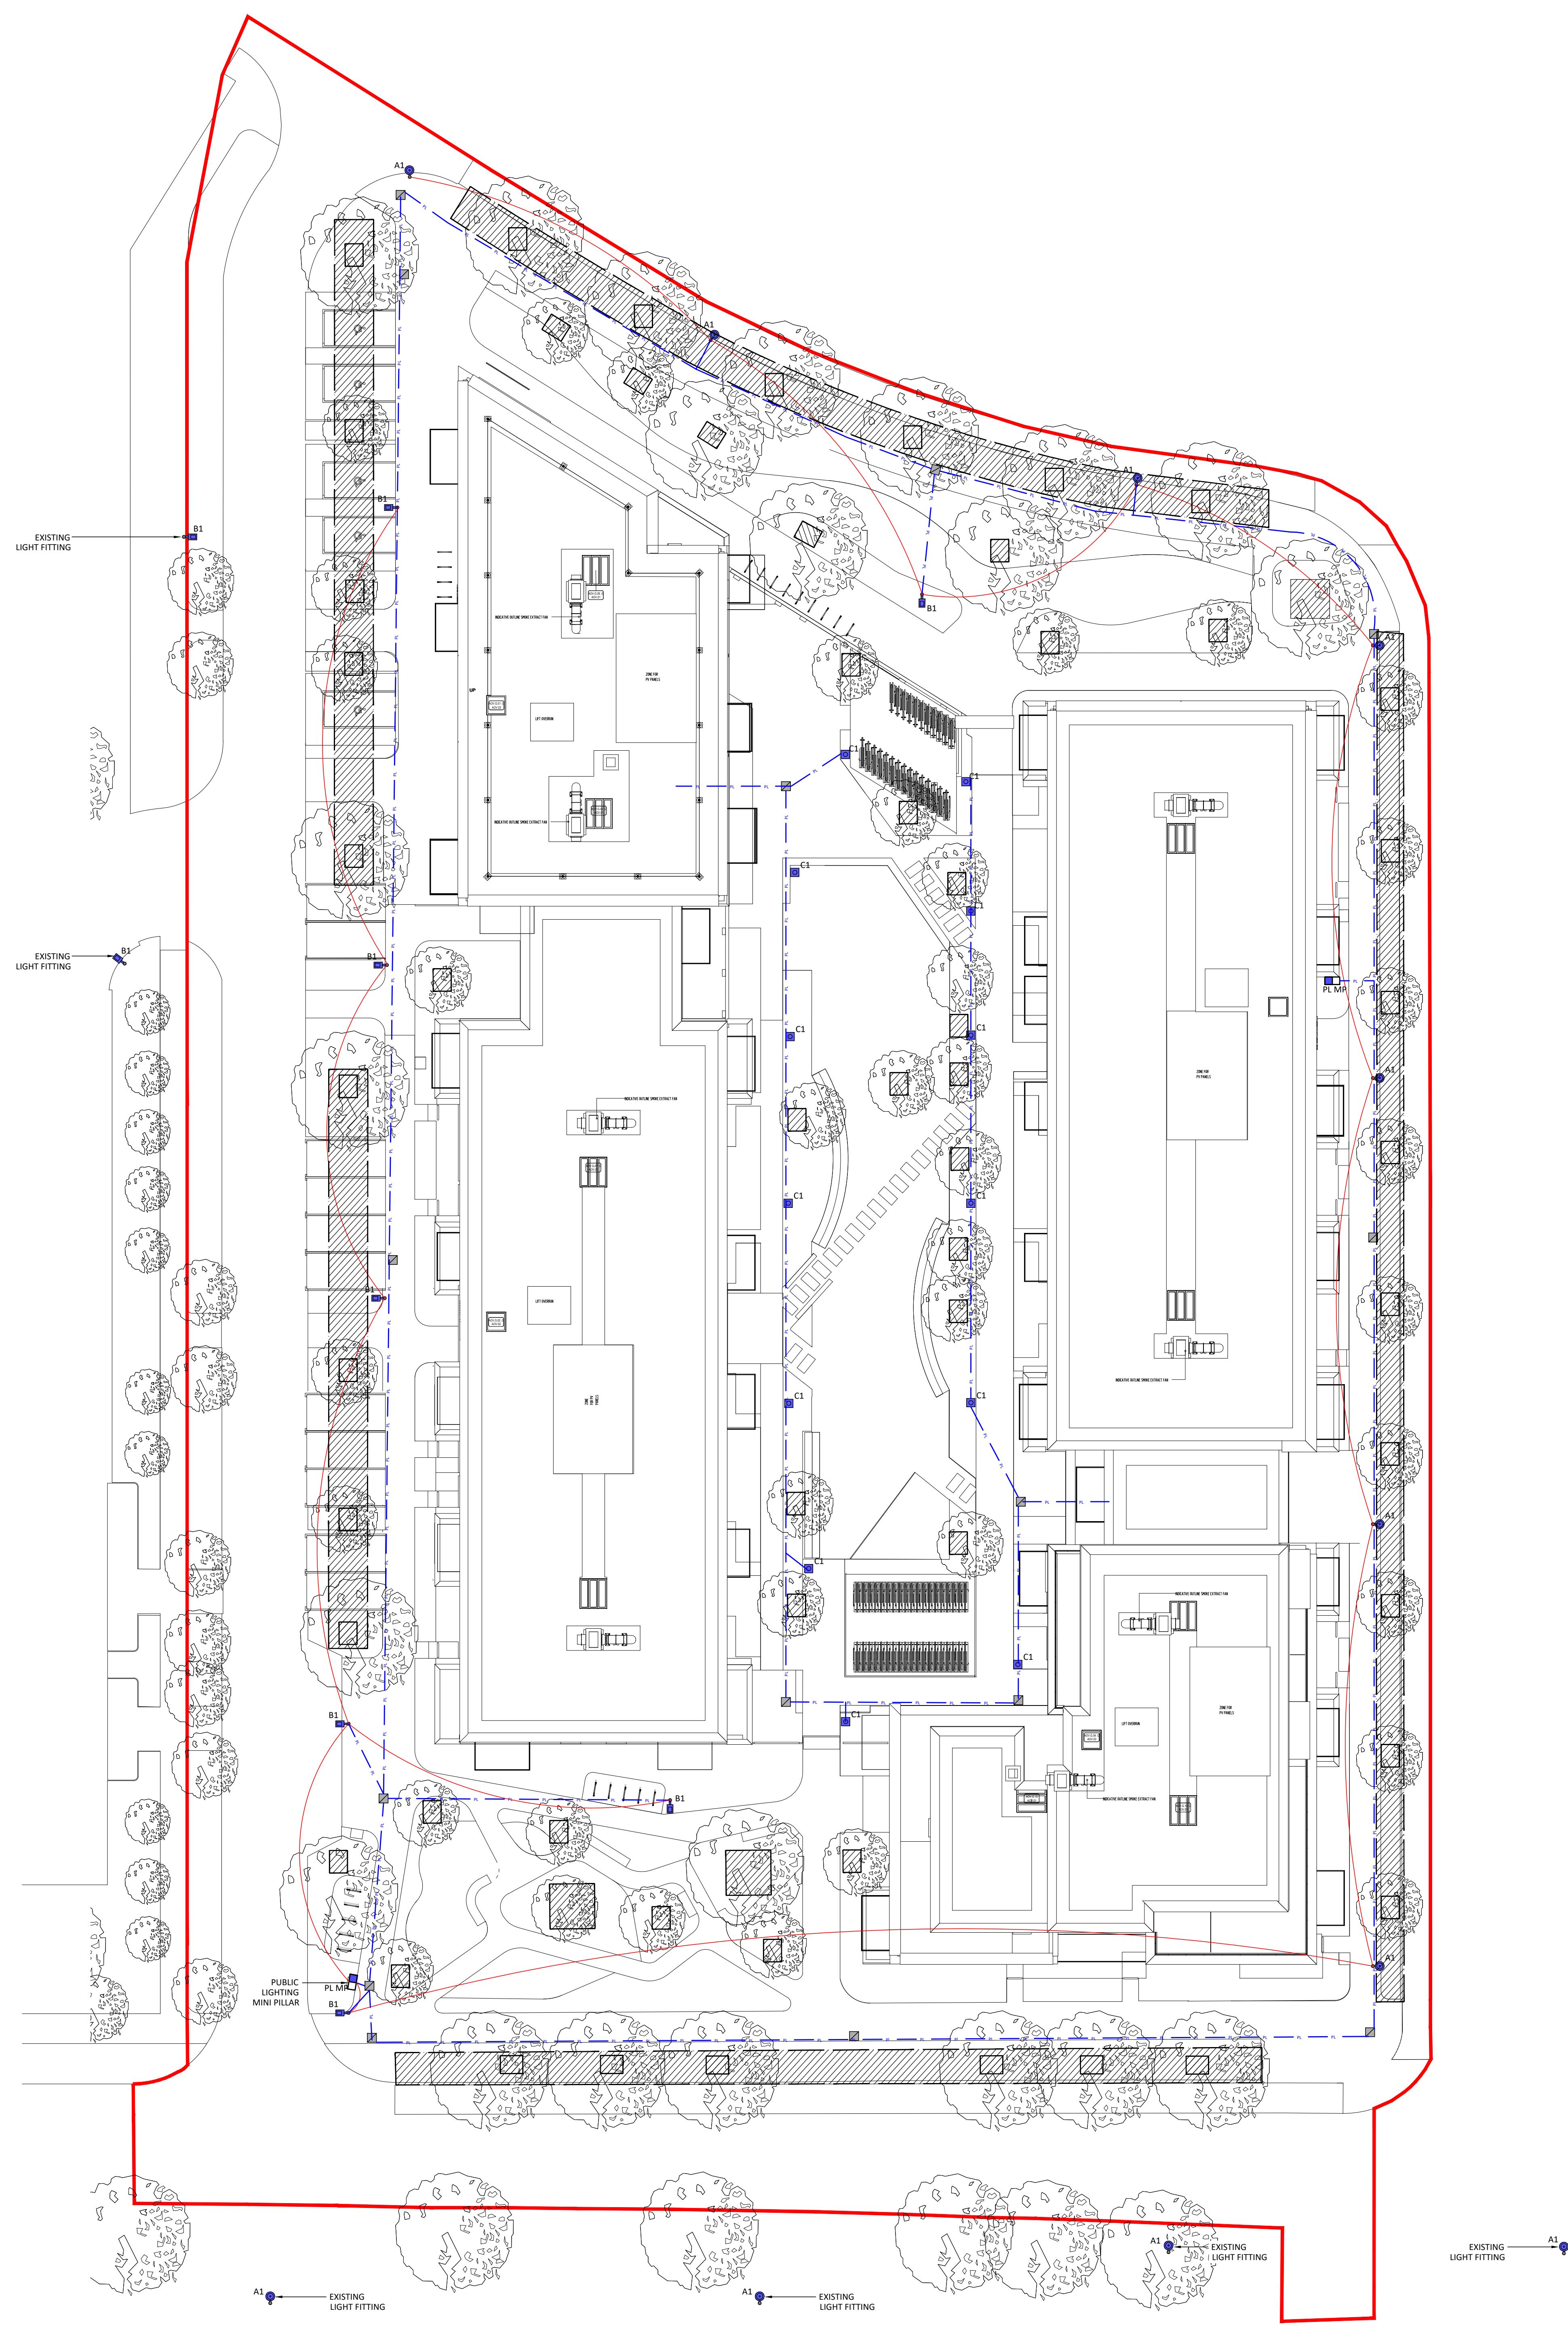

- FOR SETTING OUT REFER TO ARCHITECT'S DRAWINGS.
- THIS DRAWING TO BE READ IN CONJUNCTION WITH ALL OTHER ARCHITECTURAL AND ENGINEERING DRAWINGS AND ALL OTHER RELEVANT DRAWINGS AND SPECIFICATIONS.
- DO NOT SCALE THIS DRAWING. USE FIGURED DIMENSIONS ONLY.
- NO PART OF THIS DOCUMENT MAY BE REPRODUCED OR TRANSMITTED IN ANY FORM OR STORED IN ANY RETRIEVAL SYSTEM OF ANY NATURE WITHOUT THE WRITTEN PERMISSION OF O'CONNOR SUTTON CROWN AS COPYRIGHT HOLDER EXCEPT AS AGREED FOR USE ON THE PROJECT FOR WHICH THE DOCUMENT WAS ORIGINALLY ISSUED.

Rev No.	Date	Revision Note	Drn by	Chkd by
C01	14.10.22	SUITABLE FOR CONSTRUCTION.	E.F.	C.K.
C02	09.05.23	REVISED LEGEND	B.O.B.	E.O.

Rev No.	Date	Revision Note	Drn by	Chkd by

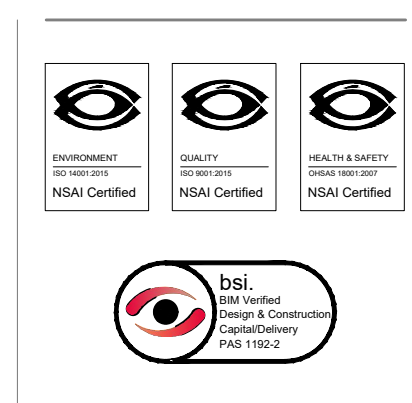

Head Office,
9 Prussia Street,
Dublin 7,
D07 K757

TEL +353 (0)1 8682000

e: contactus@ocsc.ie
w: www.ocsc.ie

Dublin | London | Belfast | Galway | Cork | Birmingham



Client: QUINTAIN IRELAND LTD.
Project: ADAMSTOWN STATION
Co. DUBLIN

Title: ELECTRICAL
SITE LIGHTING LAYOUT - BLOCK G
LEVEL 00 - GROUND FLOOR PLAN

Code | Originator | Zone | Level | Type | Role | Number | Status | Revision
Q066 | OCSC | BG | XX | DR | E | 0001 | A1 | C02

Date: 03.11.21 Scale: 1:200 @ A0 Drn by: E.F. Chkd by: C.K. Apprd by: E.O.