


NOTES

1. THIS DRAWING IS TO BE READ IN CONJUNCTION WITH ALL RELEVANT ARCHITECTS AND ENGINEERS DRAWINGS AND SPECIFICATIONS.
2. ALL DIMENSIONS ARE IN MILLIMETRES AND ARE TO BE CHECKED ON SITE.
3. ALL LEVELS ARE IN METRES AND REFER TO ORDNANCE DATUM MALIN HEAD.
4. DO NOT SCALE, USED FIGURED DIMENSIONS ONLY.


LEGEND

- BOUNDARY OUTLINED IN RED
- EXISTING SURFACE WATER DRAINAGE
- EXISTING FOUL WATER DRAINAGE
- EXISTING WATERMAIN
- PROPOSED SURFACE WATER DRAINAGE
- PROPOSED FOUL WATER DRAINAGE
- PROPOSED WATERMAIN

KEYPLAN

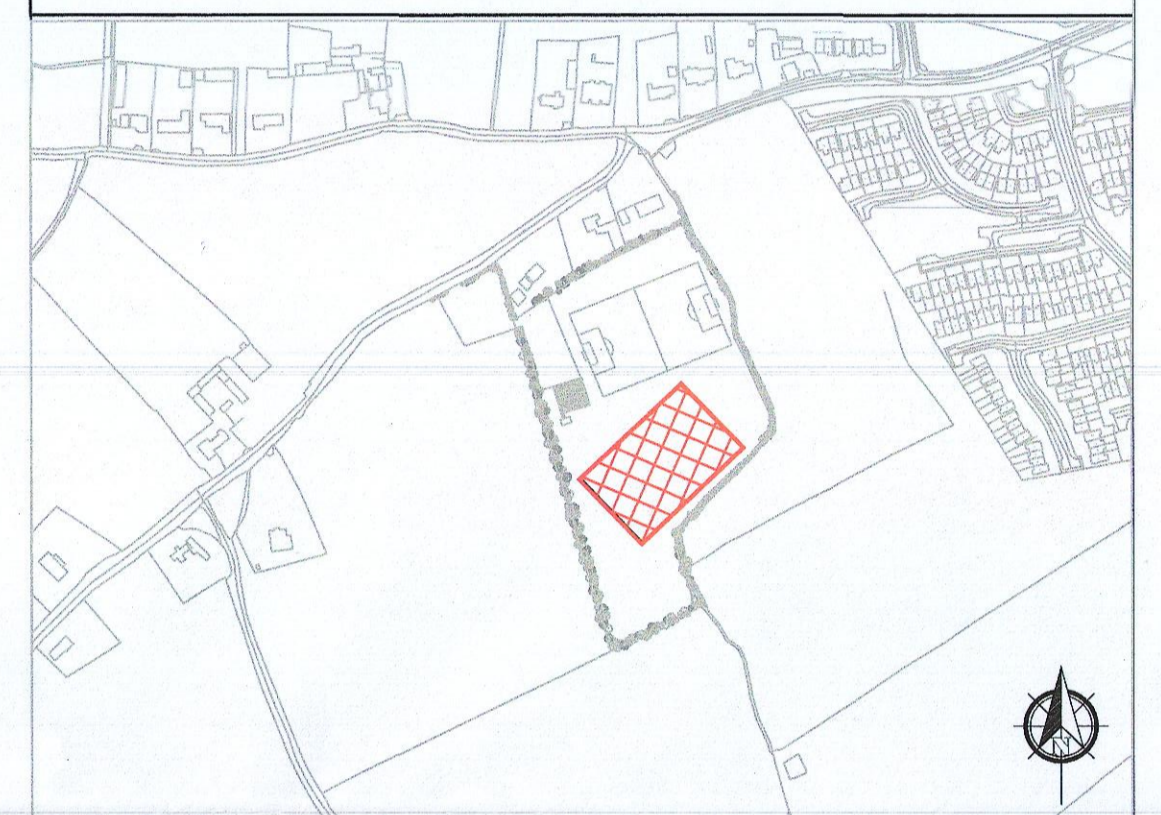

PROPOSED DRAINAGE LAYOUT  
SCALE 1:500

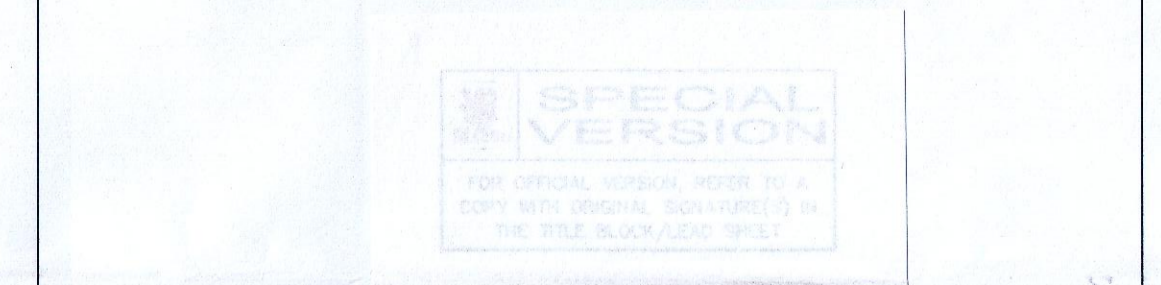

C	REISSUED FOR PLANNING	SM	PE	MK	MK	18/09/23
B	ISSUED FOR PLANNING	PE	SM	MK	MK	25/11/22
A	ISSUED FOR CLIENT COMMENTS	SM	SM	MK	MK	25/11/22
ISSUE	DESCRIPTION	DRN	ORIG	AUTH	APP	DATE



CLIENT TALLAGHT TOWN AFC

**MACEO** Design & Management Limited  
 81 Main Street, Applemood Village,  
 Swords,  
 Co. Dublin, K67 W30  
 Ireland.  
 Tel: +353 -1- 8957818  
 Fax: +353 -1- 8957819  
 E-mail: postmaster@maceo.ie

PROJECT PROPOSED NEW ASTRO PARK DEVELOPMENT AT CAROLAN PARK TALLAGHT, Co. DUBLIN

TITLE PROPOSED DRAINAGE LAYOUT

PROJECT No.	22020	CLIENT DRG. No.	
SCALE	1:500	DRG. No.	22020-30-DR-0101

THIS DRAWING IS COPYRIGHT © ALL RIGHTS RESERVED. NO PART OF THIS DRAWING MAY BE REPRODUCED, STORED IN A RETRIEVAL SYSTEM OR TRANSMITTED IN ANY FORM OR BY ANY MEANS WITHOUT THE PRIOR WRITTEN PERMISSION FROM MACEO DESIGN & MANAGEMENT LIMITED