



Proposed Street Elevation E-E
 1:500 @ A0
 Local Streets 3 and 9 Elevations looking East



Proposed Street Elevation E-E1
 1:200 @ A0

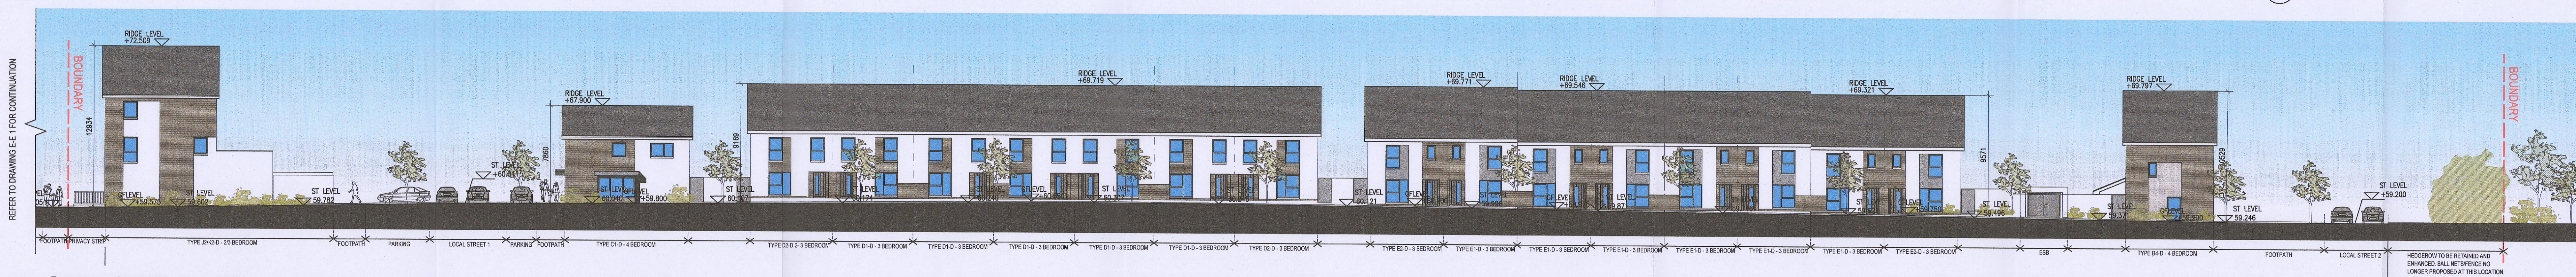

Proposed Street Elevation E-E2
 1:200 @ A0

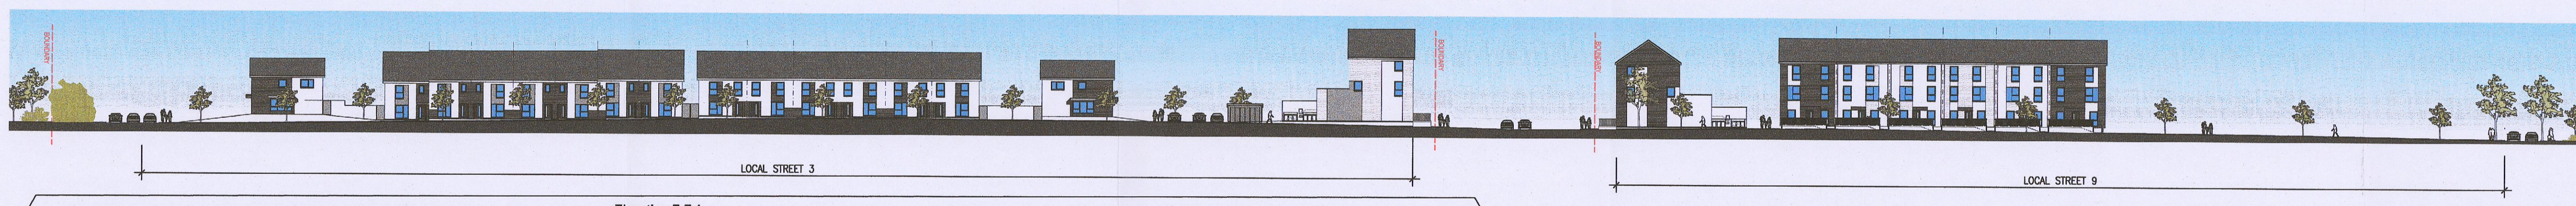


Proposed Street Elevation F-F
 1:500 @ A0
 Local Streets 3 and 9 Elevations looking West



Proposed Street Elevation F-F1
 1:200 @ A0



Proposed Street Elevation F-F2
 1:200 @ A0

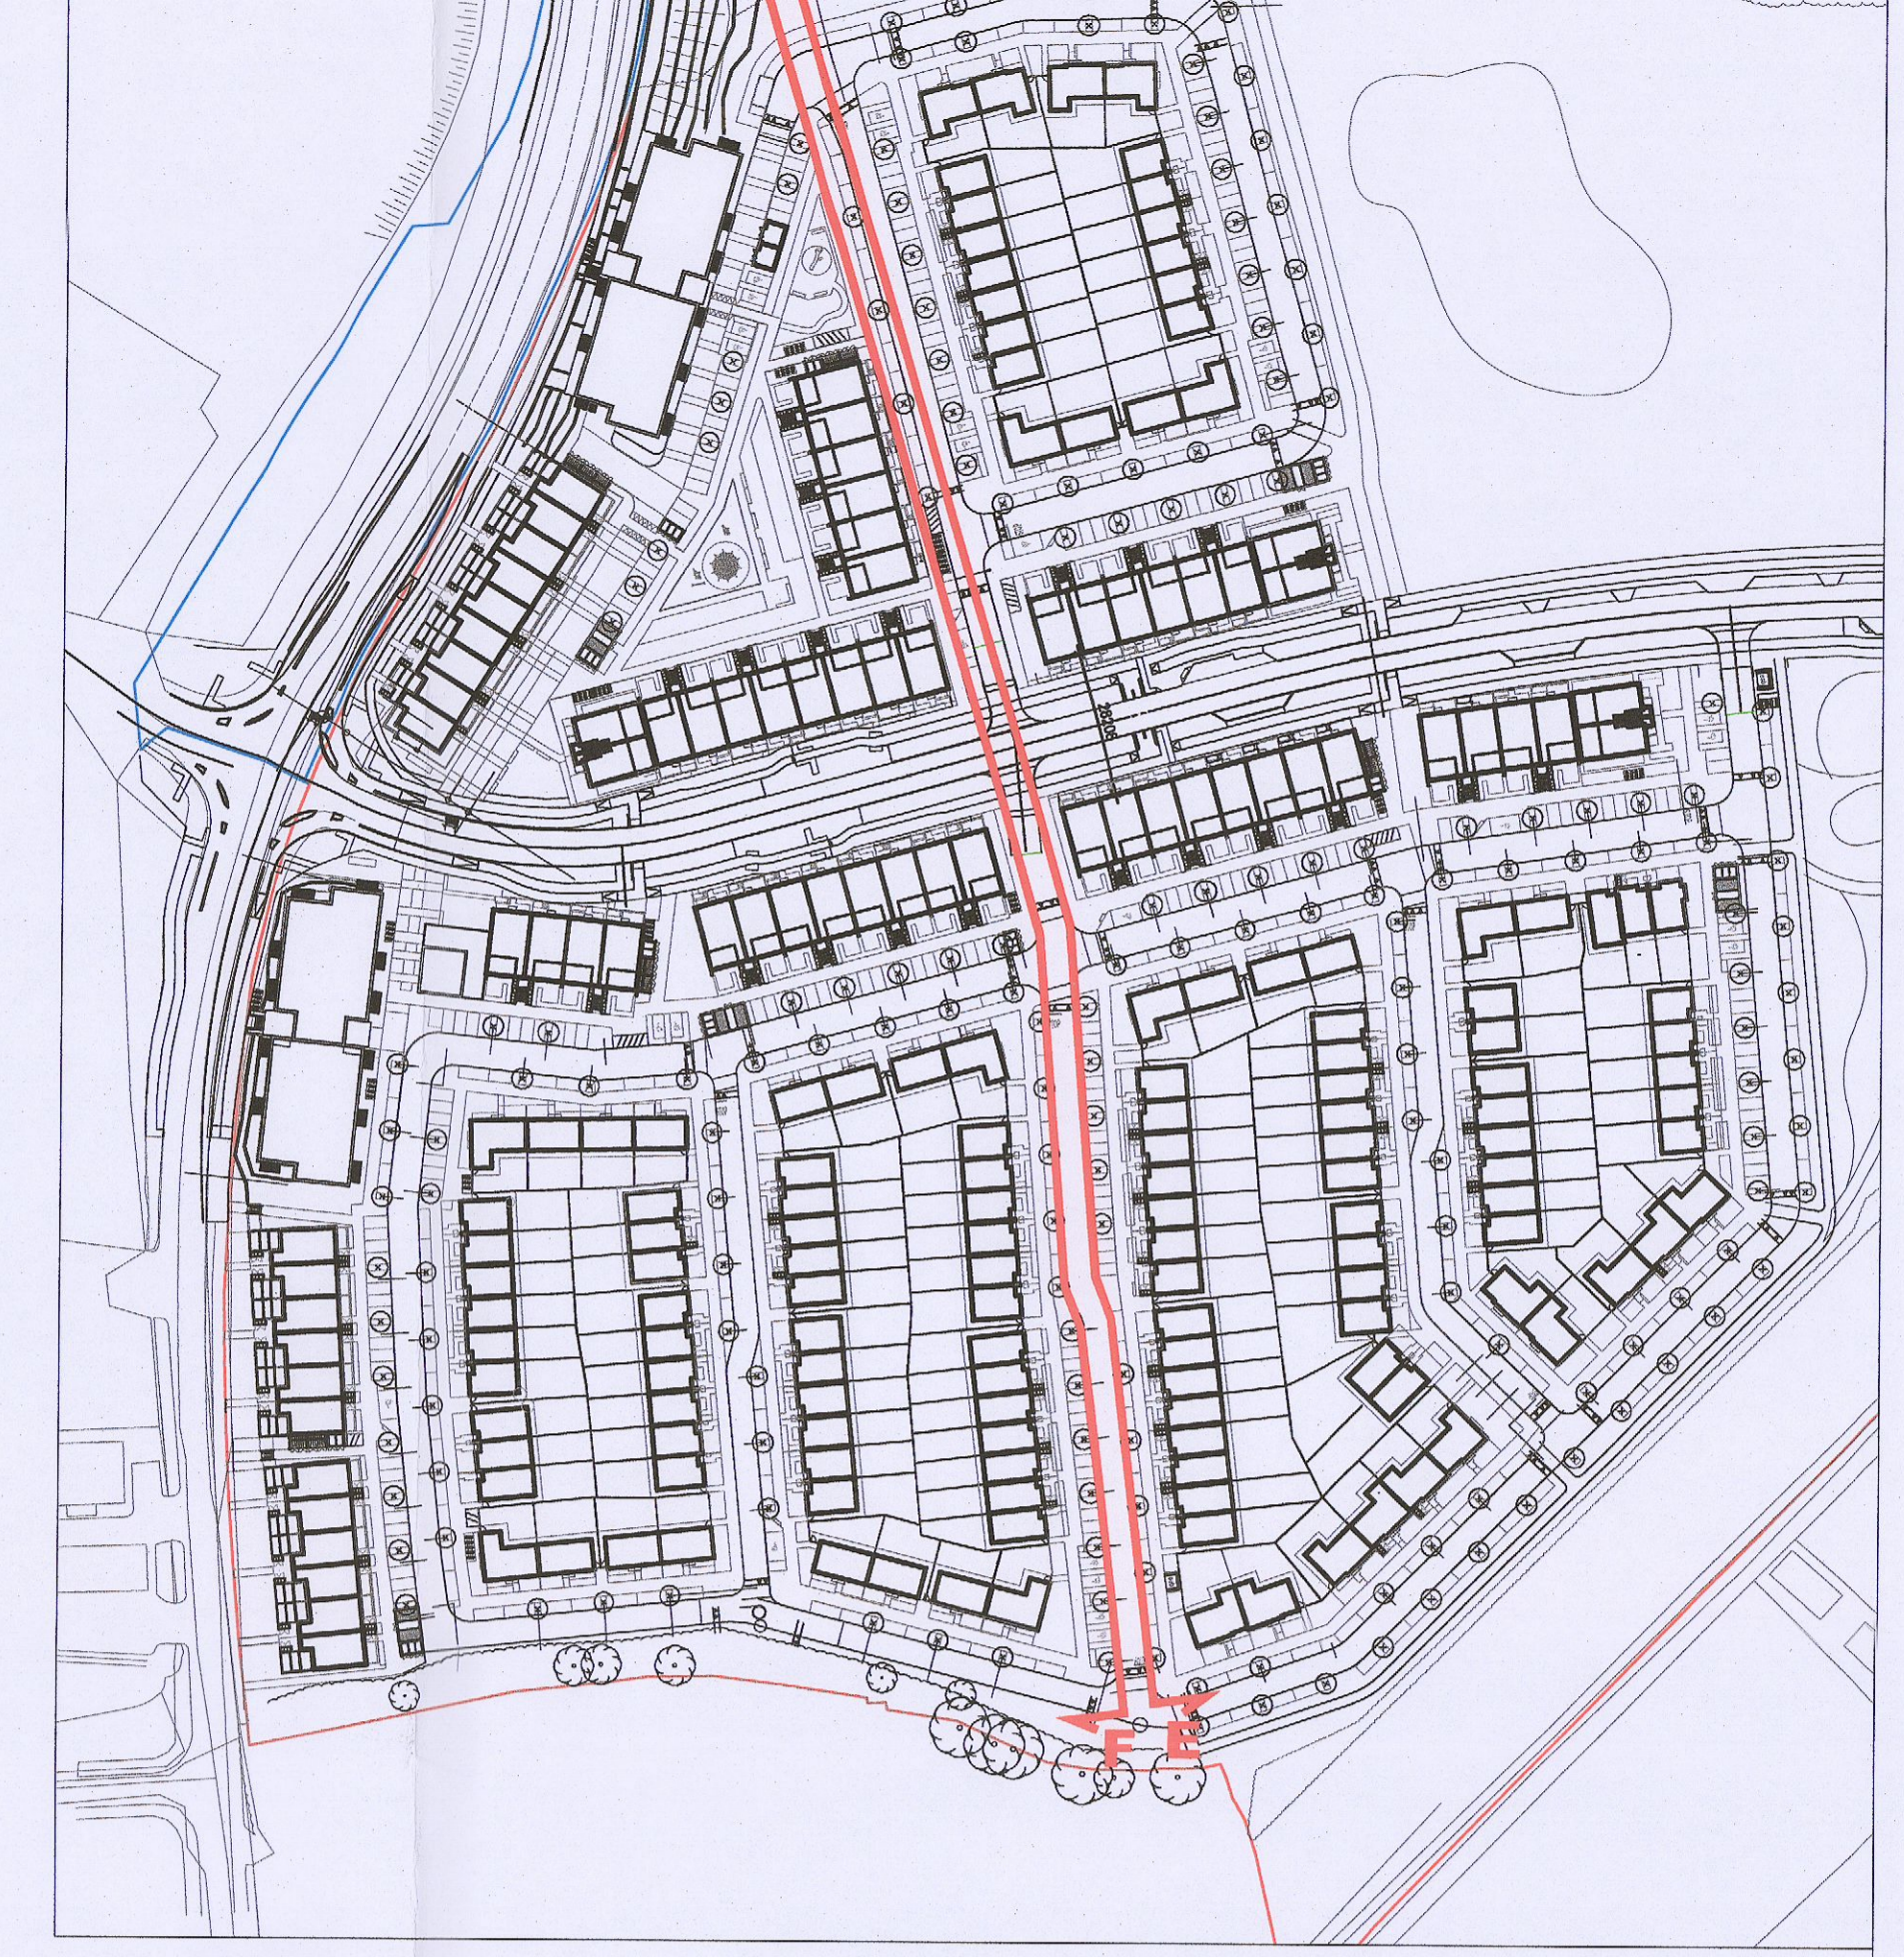

Keyplan
 Not to scale

MATERIAL CODE LEGEND

- 01 - BUFF BRICK - STANDARD BOND LIGHT APPROVED TONE
- 02 - BUFF BRICK - FEATURE BOND LIGHT APPROVED TONE
- 03 - BUFF BRICK - STANDARD BOND BROWN APPROVED TONE
- 04 - BUFF BRICK - FEATURE BOND BROWN APPROVED TONE
- 05 - SELF COLOURED RENDER LIGHT APPROVED TONE
- 06 - SELF COLOURED RENDER DARK APPROVED TONE
- 07 - CONCRETE ROOF TILES DARK APPROVED TONE
- 08 - POWDERCOATED METALWORK OR UPVC DARK APPROVED RAL COLOUR
- 09 - POWDERCOATED METAL SCREENING - DARK APPROVED RAL COLOUR
- 10 - CLEAR GLAZING WITH DARK APPROVED RAL COLOUR FRAMING
- 11 - OPACIFIED GLAZING WITH DARK APPROVED RAL COLOUR FRAMING

Notes:

1. Copyright Reserved
2. Work to fixed dimensions only. Do not scale drawings.
3. The contractor is responsible for checking all levels and dimensions on site and shall refer all discrepancies to the Architect.
4. Where appropriate, for details of structure, or mechanical and electrical details, see Engineers drawings.
5. Suppliers items shall be checked and approved in accordance with manufacturers instructions.
6. Some of contractor items shall be checked by manufacturer.
7. The contractor shall be responsible for the coordination of structure, finishes and services.

14 Project Section : C:\Users\B288\OneDrive\Work\CAD\Drawings\Planning\19\Residential\002 - Street Elevations & 04a - Sections\0208 - Street Elevations.dwg 24/10/2023 14:54:18

Issue Status	No	Date	Revision	Initials
Progress	01	27/07/23	Pre-planning meeting issue	RT
Final	02	01/11/23	RT Submission	RT

Project: Adamstown Extension - Clonburris SDZ Residential Development

Drawing Title: Contiguous Elevations - E-E & F-F

Drawing No: 0208-P-052

Scale: 1:200 @ A0

Rev: 02

Drawn: RT

Date: Jan 23

bkdarchitects
 BURKE-KENNEDY DOYLE