




01 Proposed Section A-A
1:200 @ A1



02 Proposed Section B-B
1:200 @ A1



03 Proposed Section C-C
1:200 @ A1

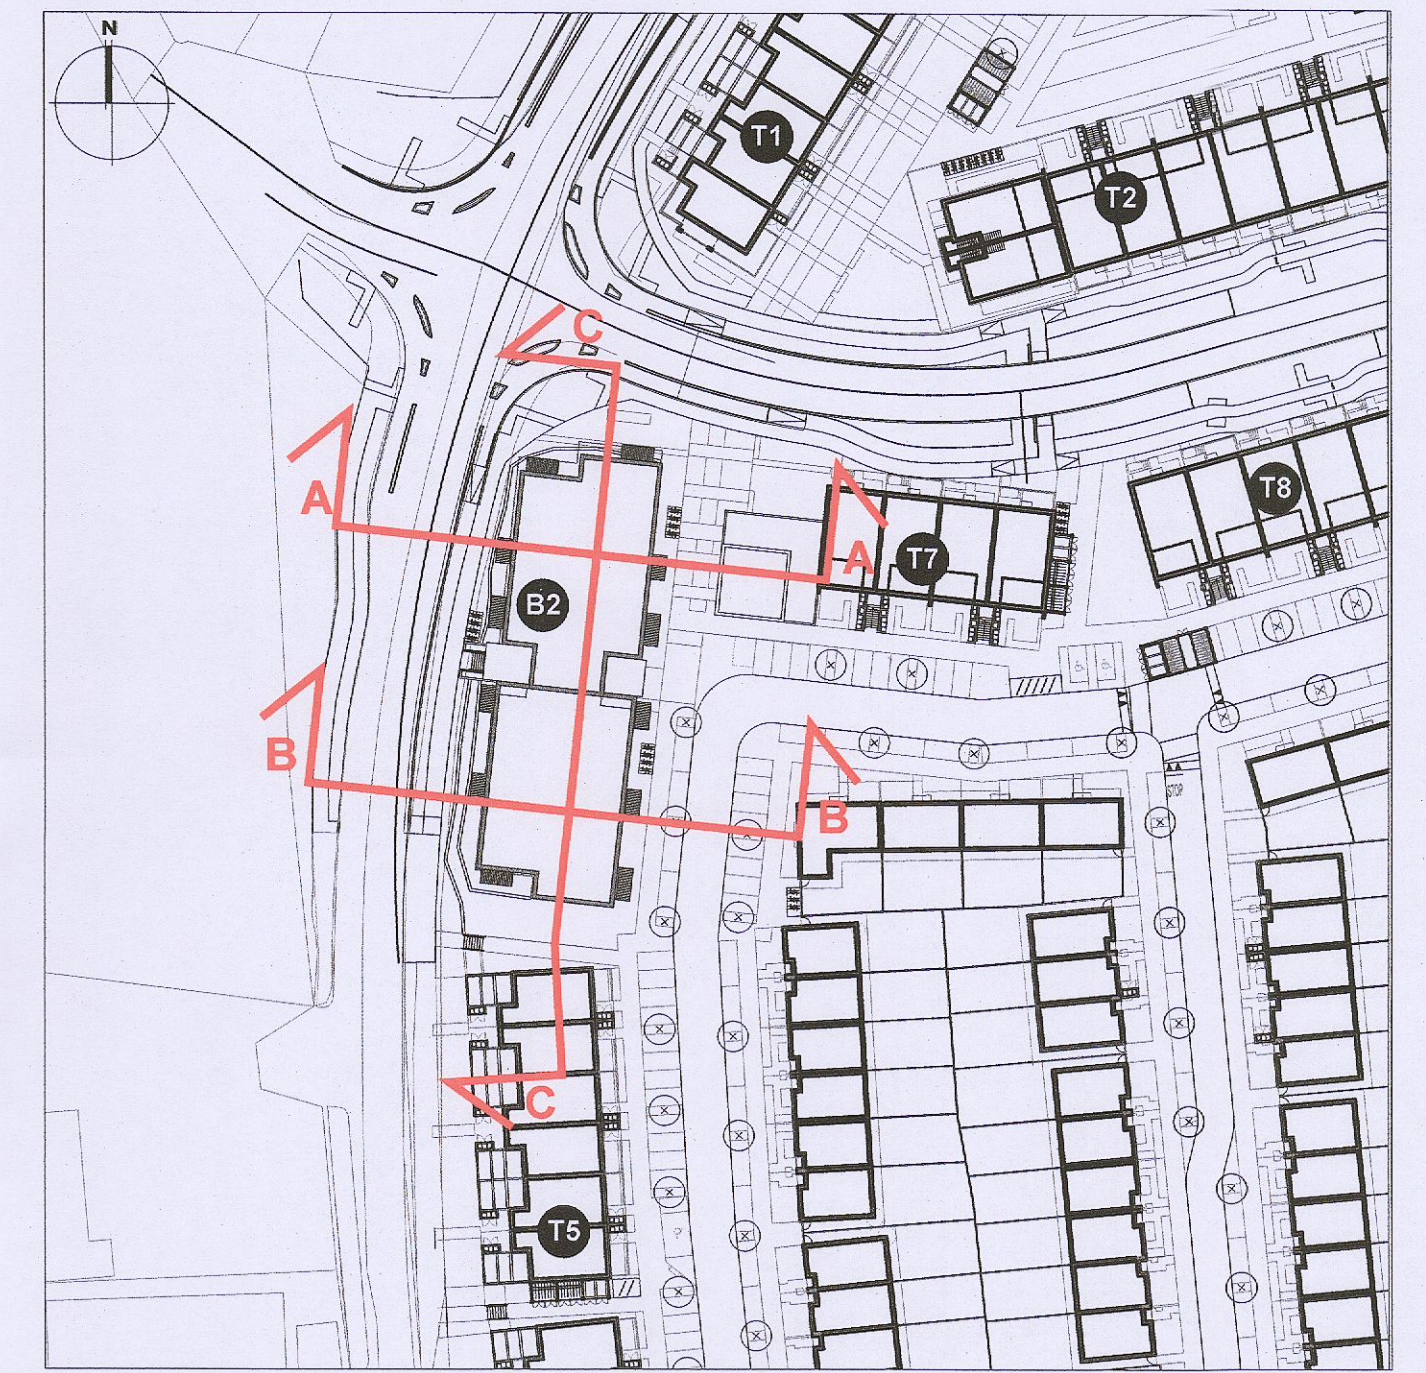

00 Keyplan
Not to scale

Notes		Issue Status		No.		Date	Revision	Initials
1.	Copyright Reserved	Progress		1	01/11/23	RPI Submission		VB
2.	Work to signed dimensions only. Do not scale drawing.	Planning Application						
3.	The contractor is responsible for checking all levels and dimensions on site and shall refer all discrepancies to the Architect.	Fire Cert						
4.	Where appropriate, for details of r.c. structure, or mechanical and electrical details, see Engineers drawings.	Disability Cert						
5.	Proprietary items shall be fixed in strict accordance with manufacturers instructions.	Tender						
6.	Sizes of proprietary items shall be checked with manufacturer.	Construction						
7.	The contractor shall be responsible for the coordination of structure, finishes and services.	As Built						
		Information Only						

Project	Adamstown Extension - Clonburris SDZ Residential Development		6-7 HARCOURT TERRACE, DUBLIN 2, IRELAND T: +353-1-618 2400 F: +353-1-675 7395 www.bkd.ie				
Drawing Title	Apartment Block 02 Proposed Sections A-A, B-B, C-C						
Drawing No	6268-P-501						
Scale	1:200@A1	Rev	01	Drawn	RT	Date	10/10/23

