


01 Proposed Bin / Bike Storage Building - Ground Plan
1:500A1



02 Proposed Bin / Bike Storage Building - Roof Plan
1:500A1

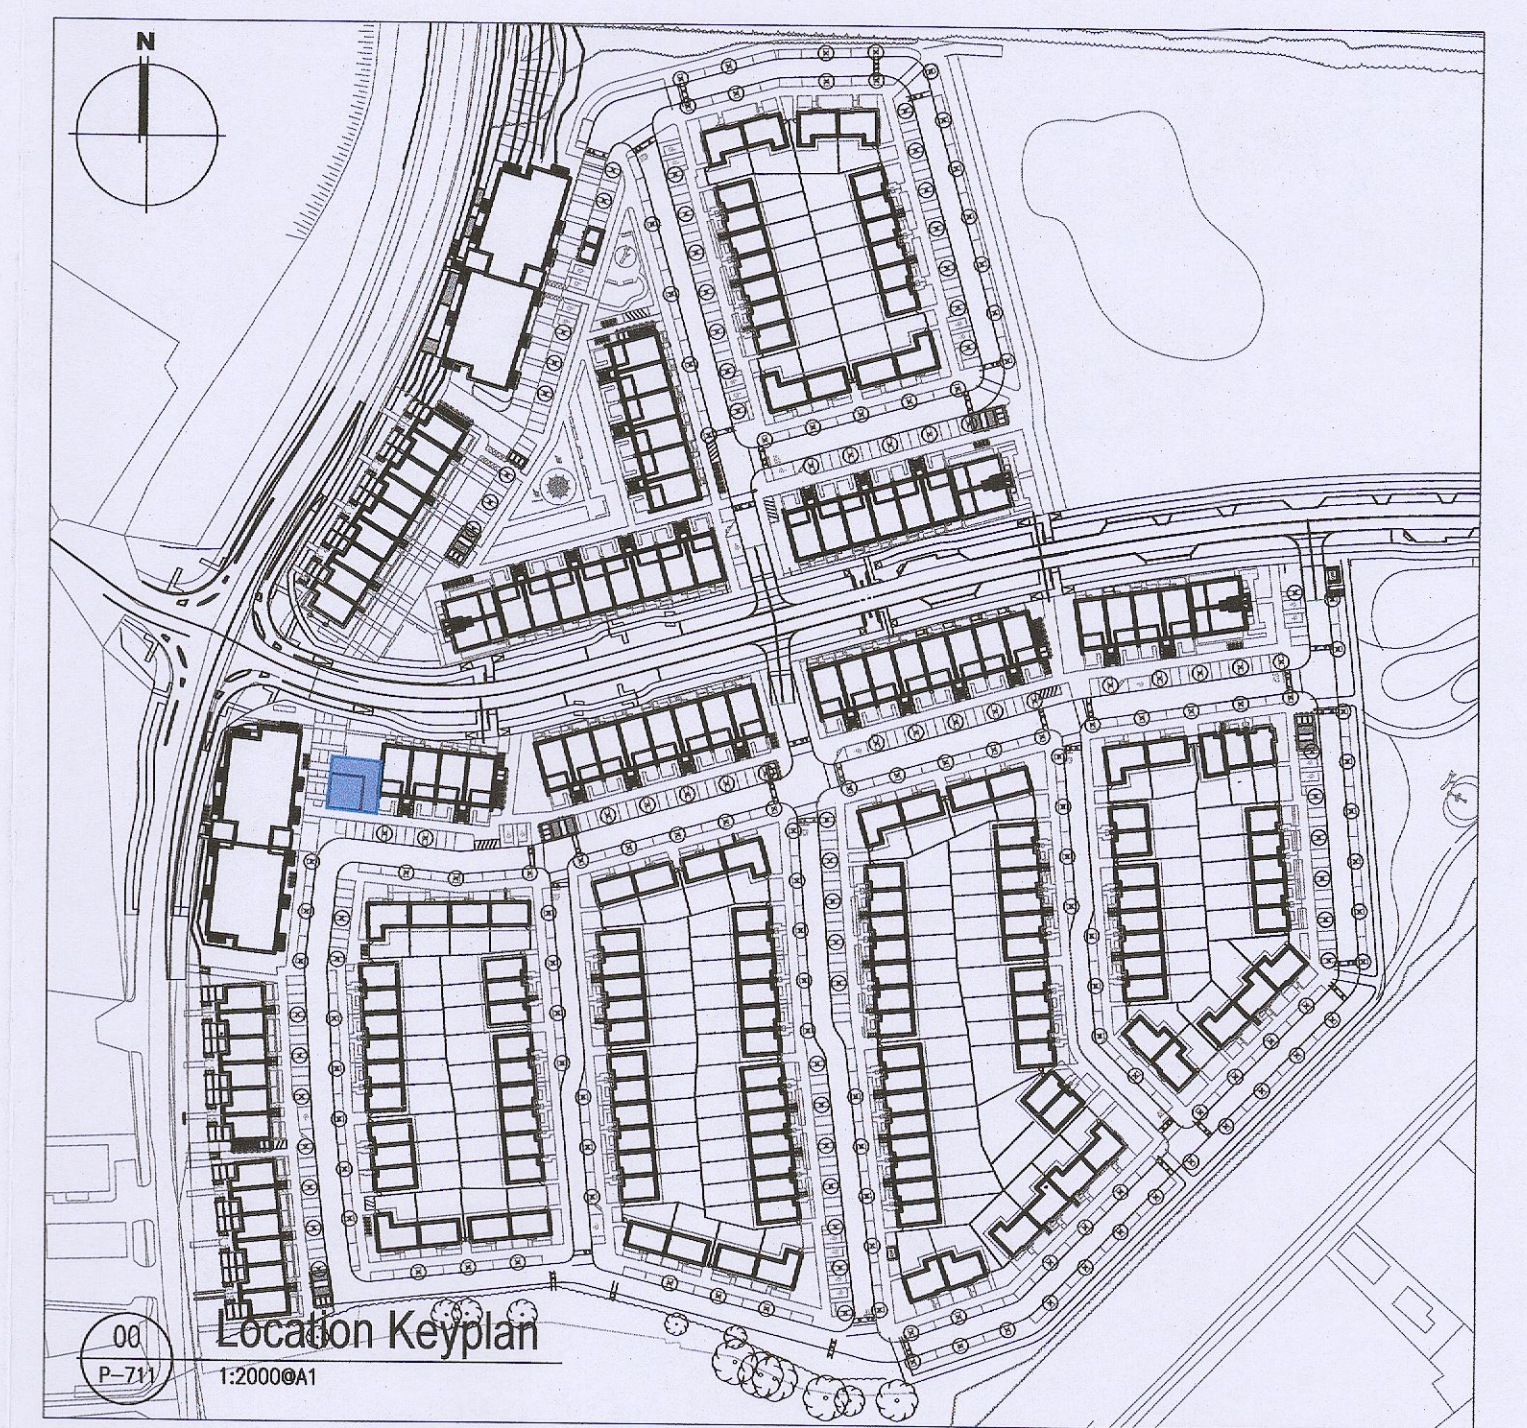

00 Location Keyplan
1:2000A1

- Notes
- Copyright Reserved
 - Work to figured dimensions only. Do not scale drawing.
 - The contractor is responsible for checking all levels and dimensions on site and shall refer all discrepancies to the Architect.
 - Where appropriate, for details of r.c. structure, or mechanical and electrical details, see Engineers drawings
 - Proprietary items shall be fixed in strict accordance with manufacturers instructions.
 - Sizes of proprietary items shall be checked with manufacturer.
 - The contractor shall be responsible for the coordination of structure, finishes and services.

Issue Status	Progress
Planning Application	■
Fire Cert	
Disability Cert	
Tender	
Construction	
As Built	
Information Only	

No.	Date	Revision	Initials
01	01/11/23	RFI Submission	VB

BIN / BIKE STORAGE BUILDING TYPE 6

Project: Adamstown Extension - Clonburris SDZ Residential Development

Drawing Title: Bin/Bike Storage Building Details - Plans

Drawing No: 6268-P-711

Scale: 1:50@A1 Rev: 01 Drawn: VB Date: Nov'23

6-7 HARDOULT TERRACE, DUBLIN 2, IRELAND
T: +353-1-618 2600 F: +353-1-678 7285
www.bkd.ie

bkdarchitects
BURKE-KENNEDY DOYLE