


- NOTES
1. DO NOT SCALE. USE DIMENSIONED DIMENSIONS ONLY.
 2. THIS DRAWING IS TO BE READ IN CONJUNCTION WITH ALL OTHER RELEVANT ARCHITECTURAL AND ENGINEERING DRAWINGS.
 3. THIS IS NOT AN INSULATION DRAWING. THE SIB CONTRACTOR SHALL SUBMIT INSULATION DRAWINGS TO THE ENGINEER FOR APPROVAL.

LEGEND

PROPOSED DISTRICT HEATING SERVICES PERE

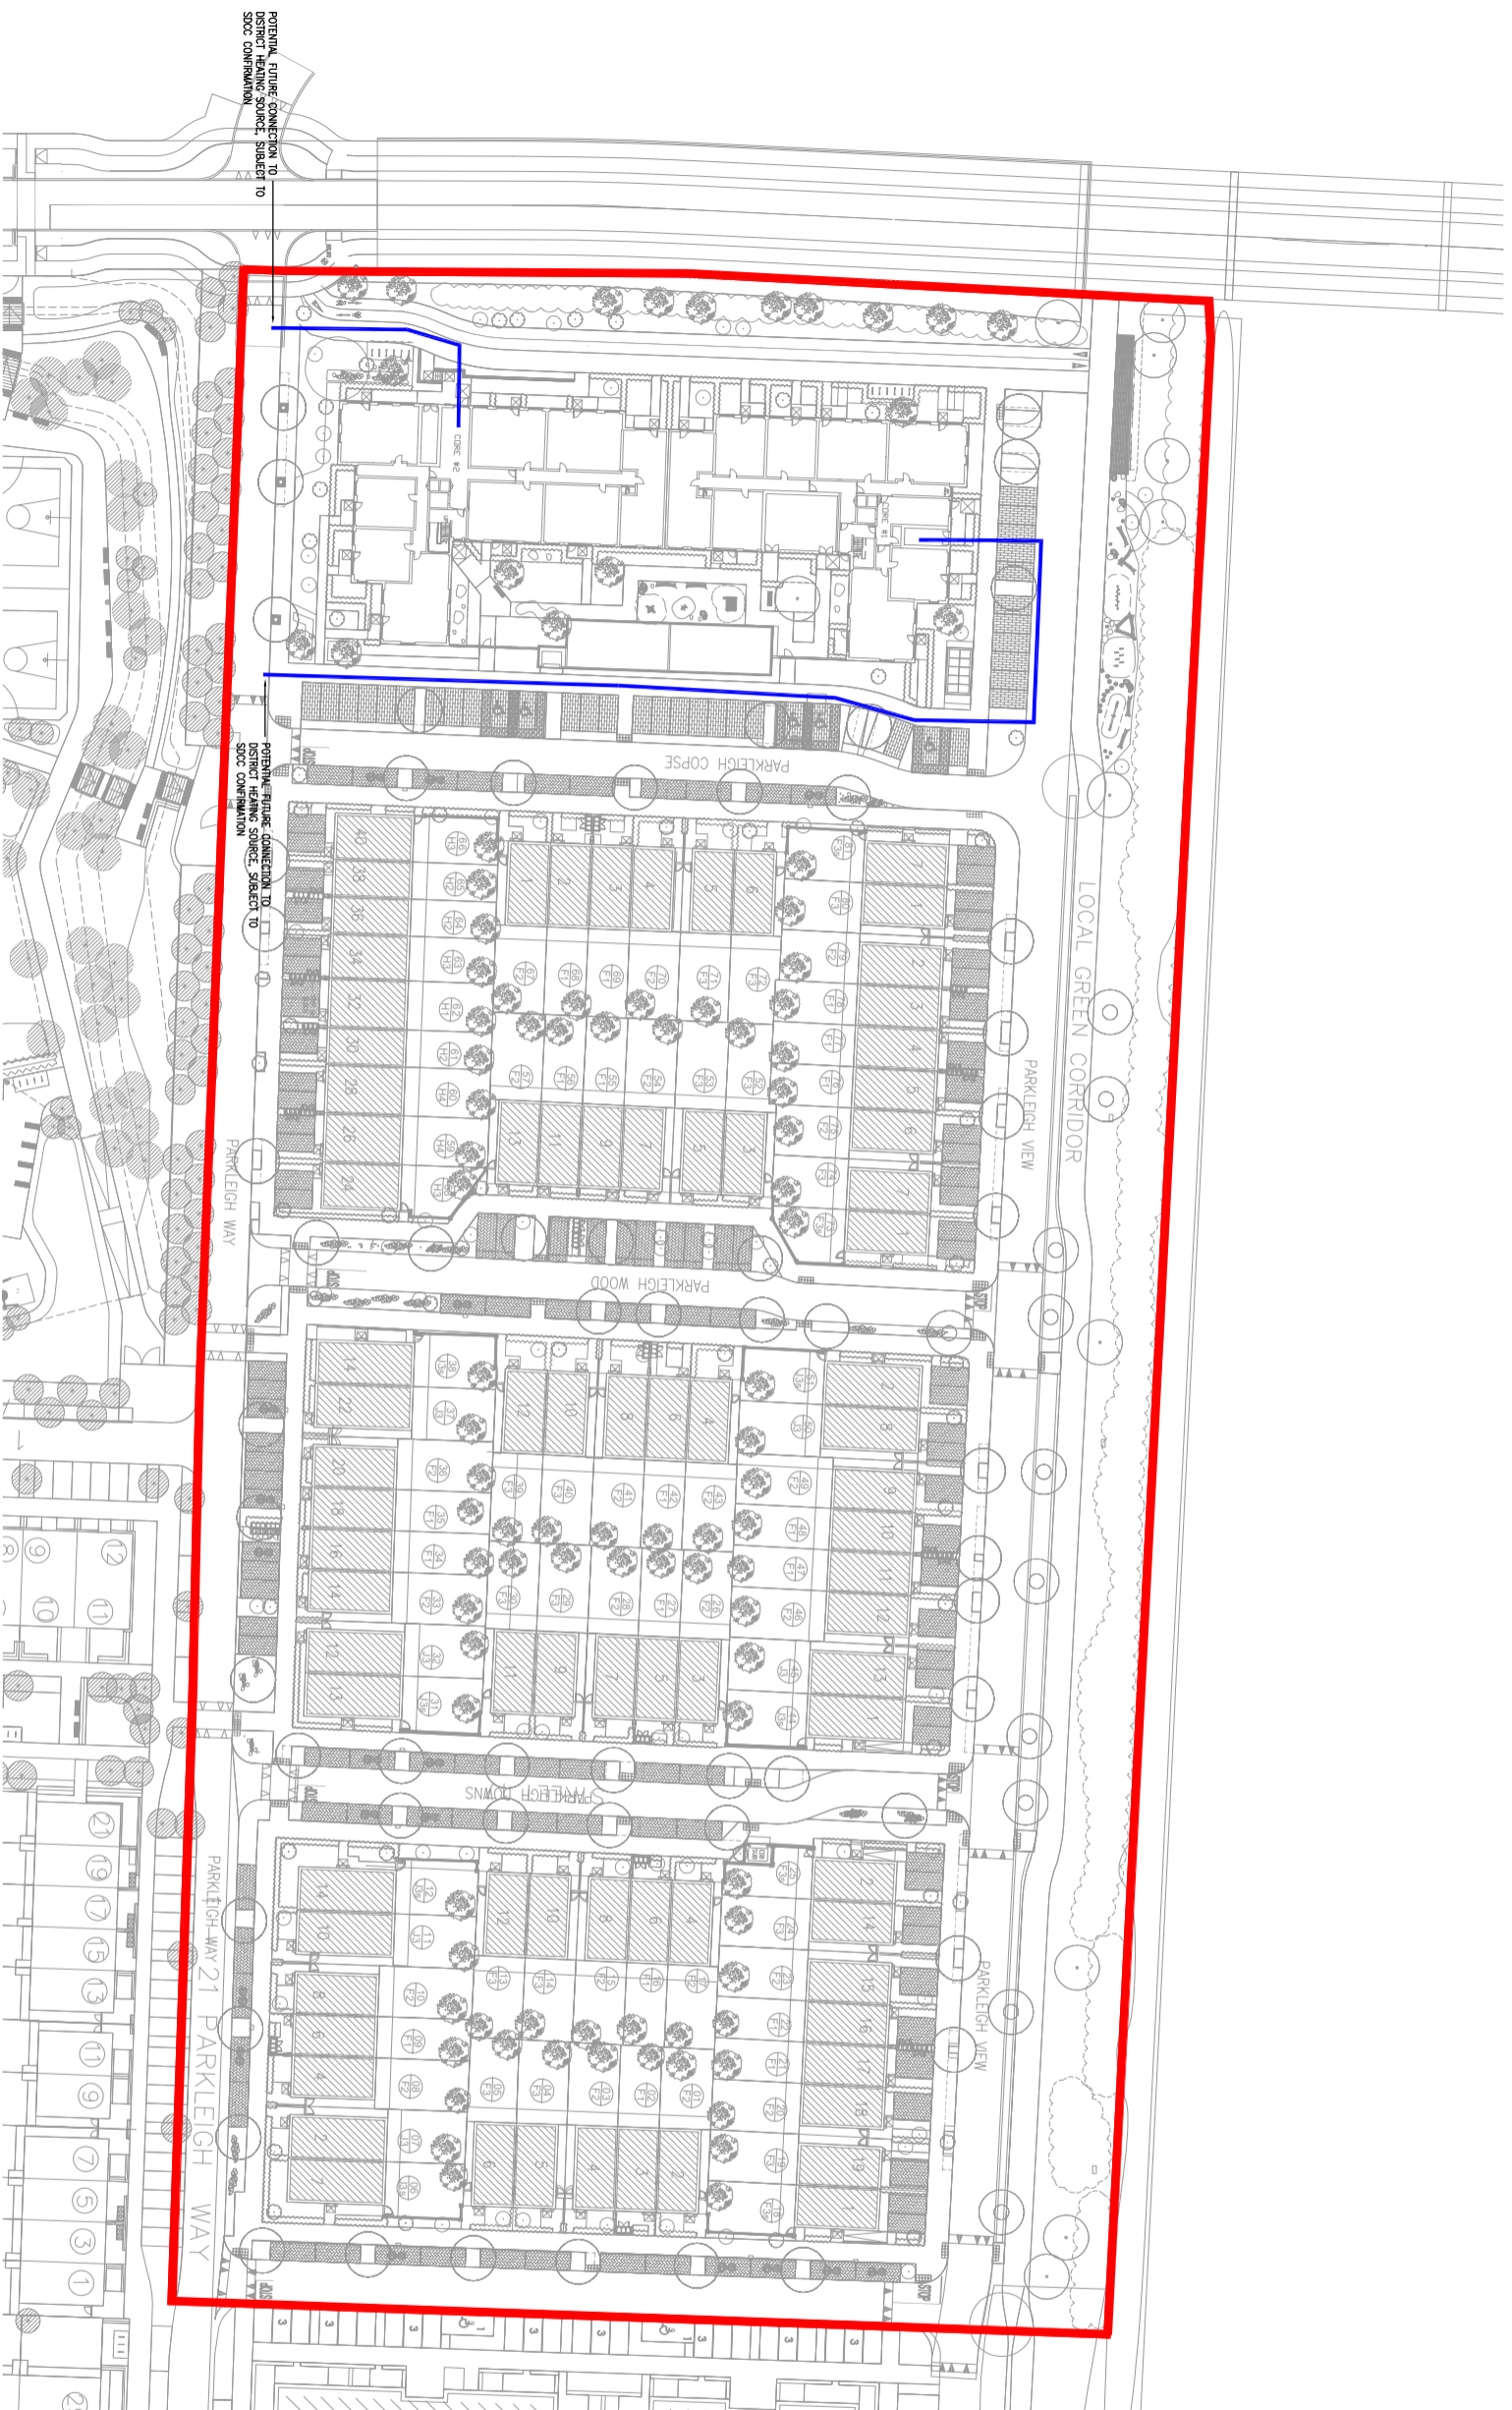

REV.	DATE	DESCRIPTION	DRN	APPD
1	19/03/24	F1 PLANNING RESPONSE	NB	AB
		AMENDMENT		

STATUS INFORMATION

Waterman Moylan
Engineering Consultants

Block 6, Eastpoint Business Park, Alfre Embury Road,
Dublin D03 H9F4 (REG. AND)
Tel: (01) 664 8800 Fax: (01) 661 3618
Email: info@waterman-moylan.ie www.waterman-moylan.ie

CLIENT: CAIRN HOMES PLC
ARCHITECT: MOORM ARCHITECTS
PROJECT: CLONBURRS T1E 3

TITLE: ELECTRICAL ENGINEERING SERVICES
SITE UTILITIES
PROPOSED DISTRICT HEATING LAYOUT
CLB-T3-60-UT-ZZZ-DR-WM-EE-E1004

DRAWN	DESIGNED	APPROVED	DATE
NB	AB	NC	MARCH 2024
SCALE	JOB NO.	DRG. NO.	REVISION
1:500 @ A1	23-010	13-E1004	1