

Legend:

Proposed application boundary



PROPOSED AREAS TO BE TAKEN IN CHARGE

PROPOSED AREAS TO BE TAKEN IN CHARGE BY A MANAGEMENT COMPANY

THIS DRAWING RELATES TO ORDNANCE SURVEY MAPS O.S. MAP REF: 3260-a,3220-15

OS DATUM TO MALIN HEAD

DIGITALLY REPRODUCED UNDER LICENCE NUMBER: CYAL50177125 © ORDNANCE SURVEY IRELAND / GOVERNMENT OF IRELAND.

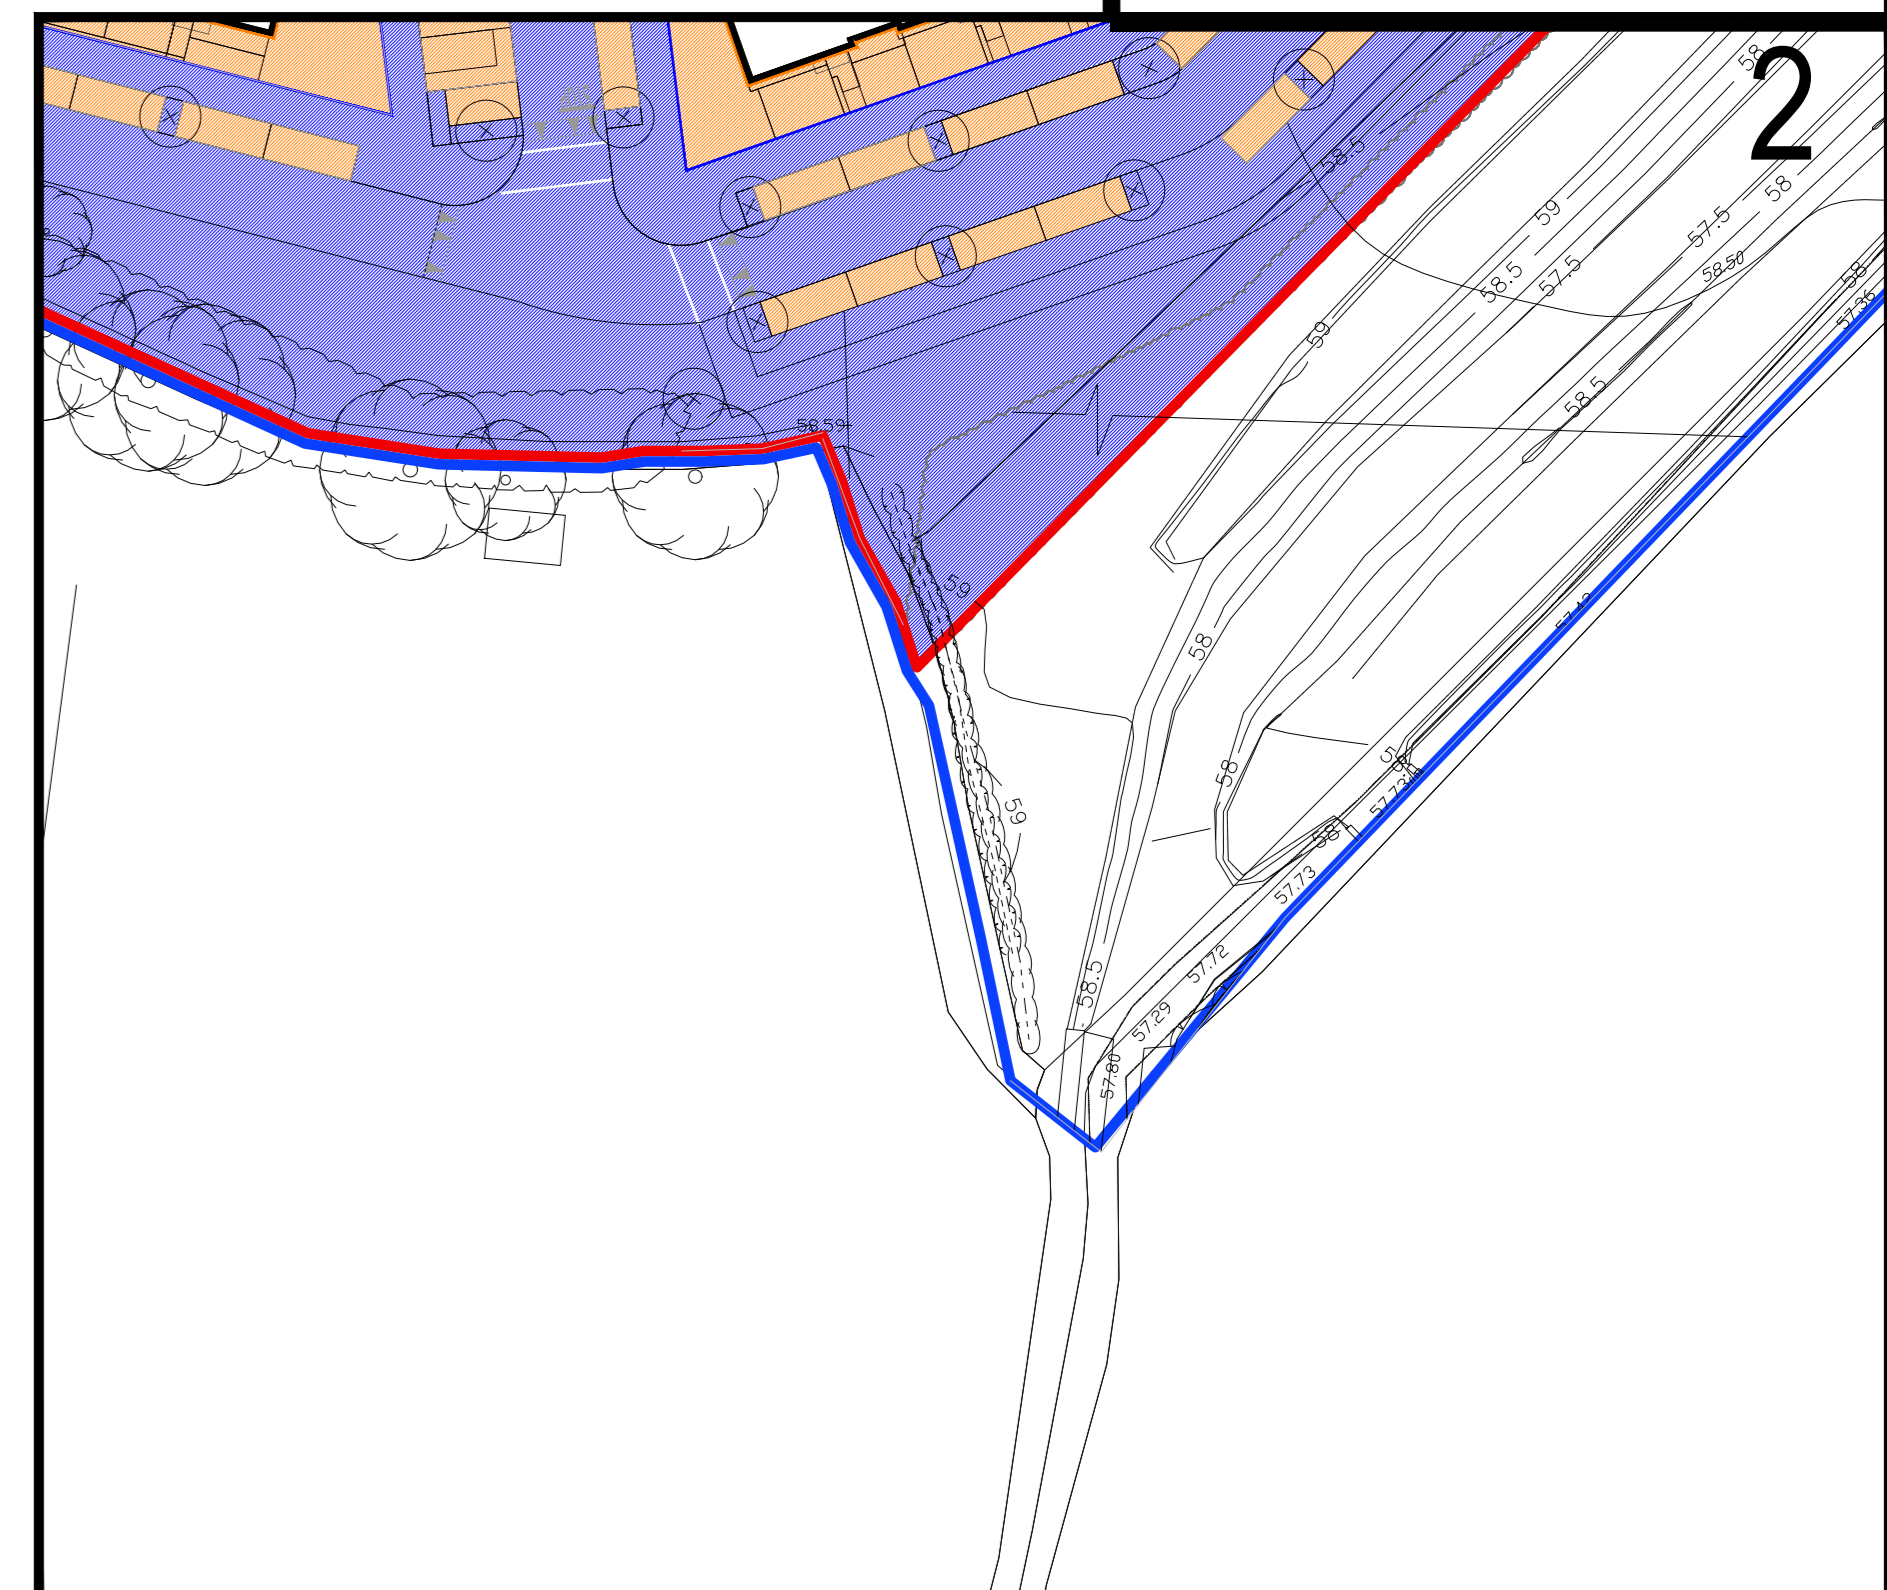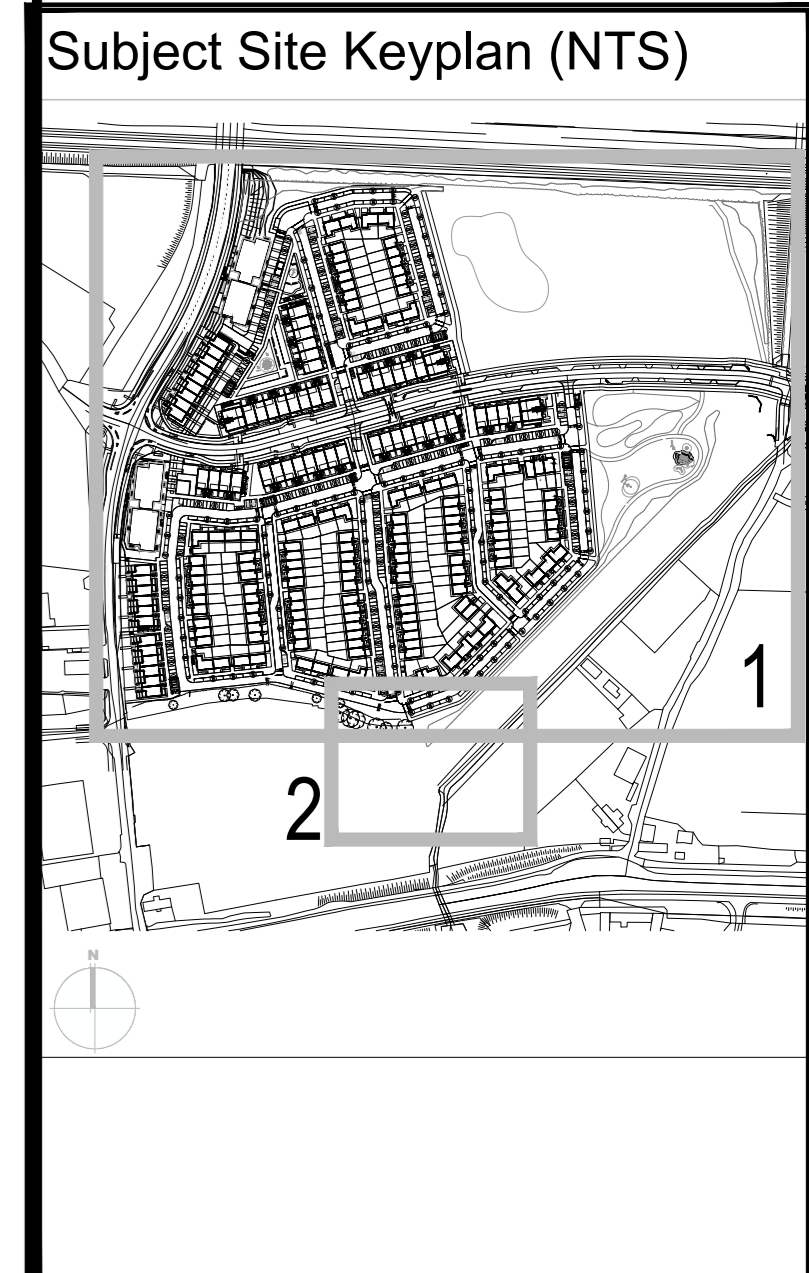

Notes:

1. Copyright Reserved
2. Work to be done in accordance with the approved drawings only. Do not scale drawings.
3. The contractor is responsible for checking all levels and dimensions on site and shall advise of discrepancies to the Architect.
4. Where appropriate, for details of c/s, structure, or mechanical and electrical details, see Engineers drawings.
5. Proprietary items shall be fixed in strict accordance with manufacturers instructions.
6. Scope of proprietary items shall be checked with manufacturer.
7. The contractor shall be responsible for the coordination of structure, finishes and services.

Issue Matrix	
Program	
Planning Application	
PC/EC	
Disability Cert	
Permit	
Construction	
As Built	
Information Only	

Rev	Date	Description	By	Check
01	27/07/23	Planning Application	RT	RT
02	01/11/23	Rev Submission	RT	RT

Project	Adamstown Extension - Clonburris SDZ Residential Development
Drawing Title	Proposed Taking in Charge Plan
Drawing No.	6268-P-005
Scale	1:500@A0
Rev	02
Drawn	RT
Date	July 23

bkd architects
BURRE-KENNEDY DOYLE

• 7 FINGHURST TERRACE, DUBLIN 2, IRELAND
T: +353 1 454 4444 F: +353 1 454 4444
www.bkd.ie