



**NOTES**


1. THIS DRAWING IS TO BE READ IN CONJUNCTION WITH ALL ENGINEERS & ARCHITECTS DRAWINGS FIGURED DIMENSIONS ONLY (NOT SCALING) TO BE USED. WHERE A CONFLICT OF INFORMATION EXISTS OR IN ANY DOUBT - ASK.
2. CONSULTANTS TO BE INFORMED IMMEDIATELY OF ANY DISCREPANCIES BEFORE WORK PROCEEDS.

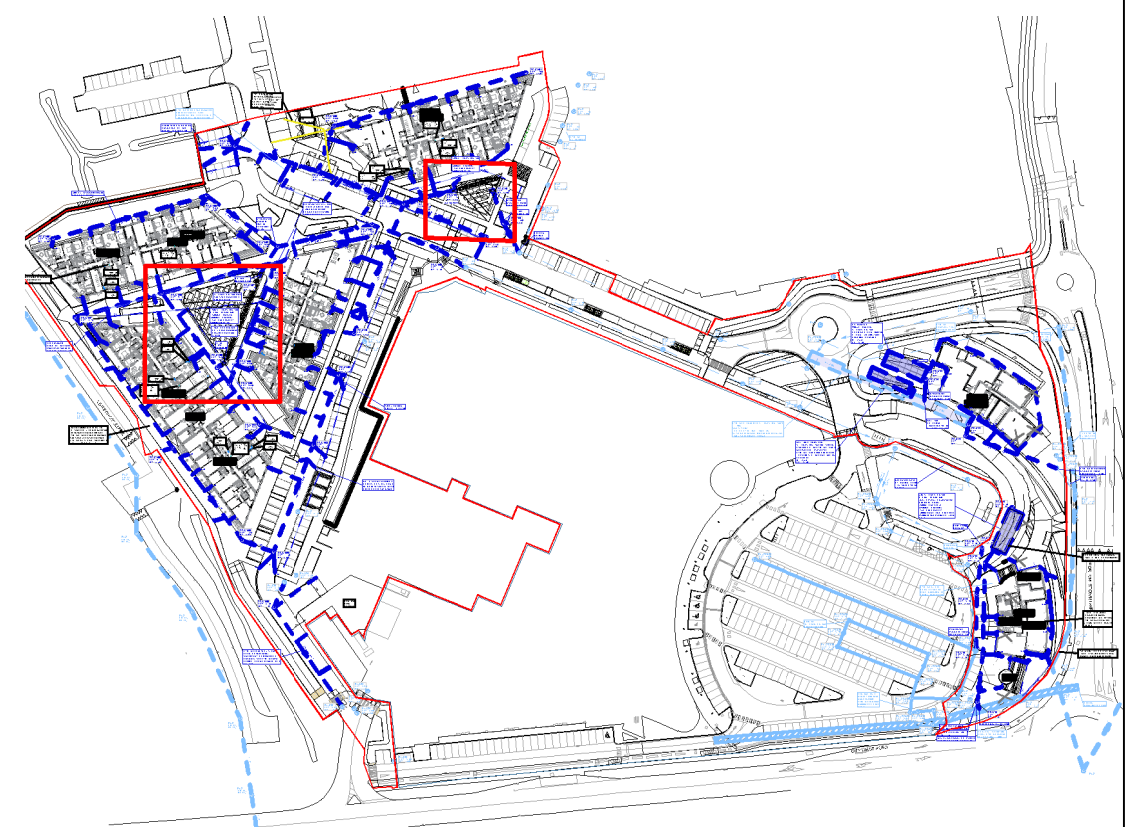


**KEY PLAN**  
SCALE @ A3: 1:5000

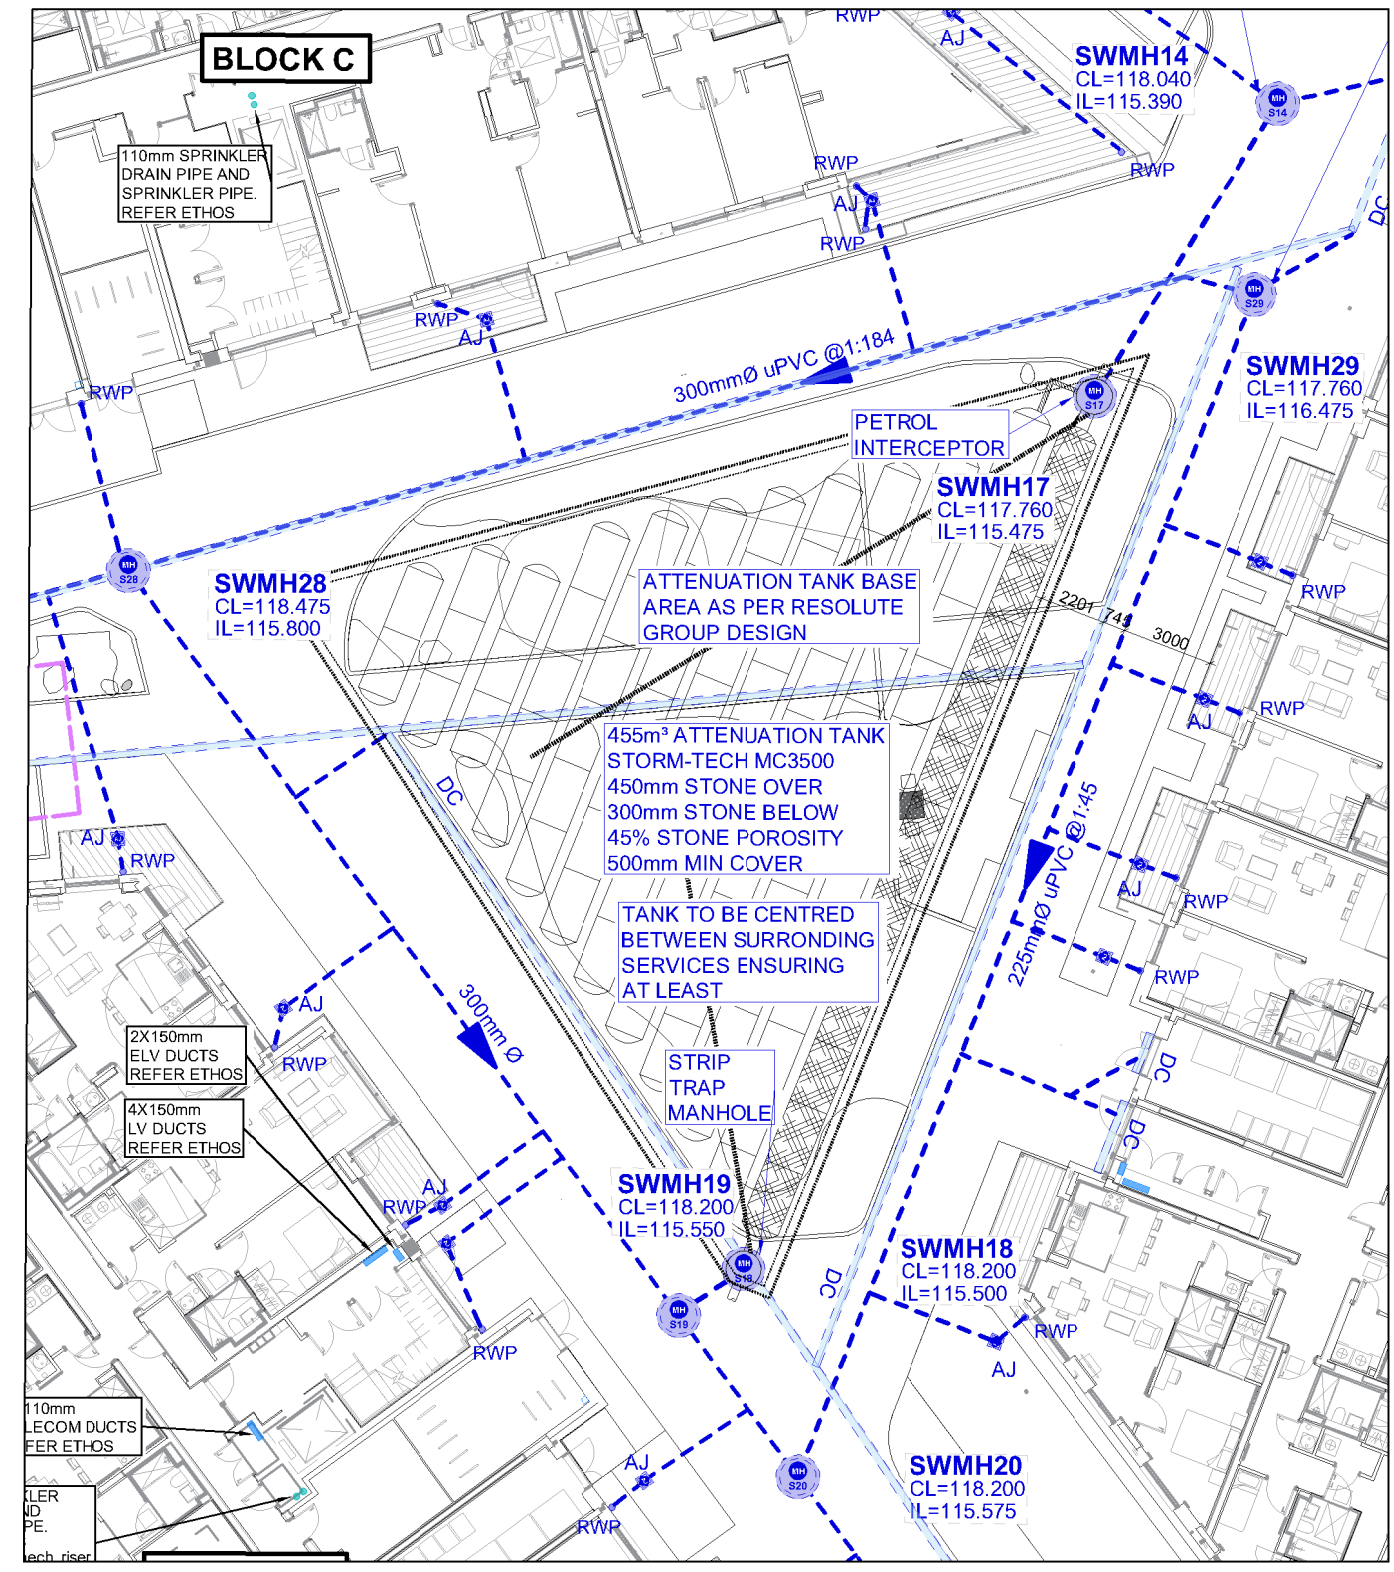


**PROPOSED SURFACE WATER DRAINAGE LAYOUT - TANK ABC**  
SCALE @ A1: 1:250  
SCALE @ A3: 1:500

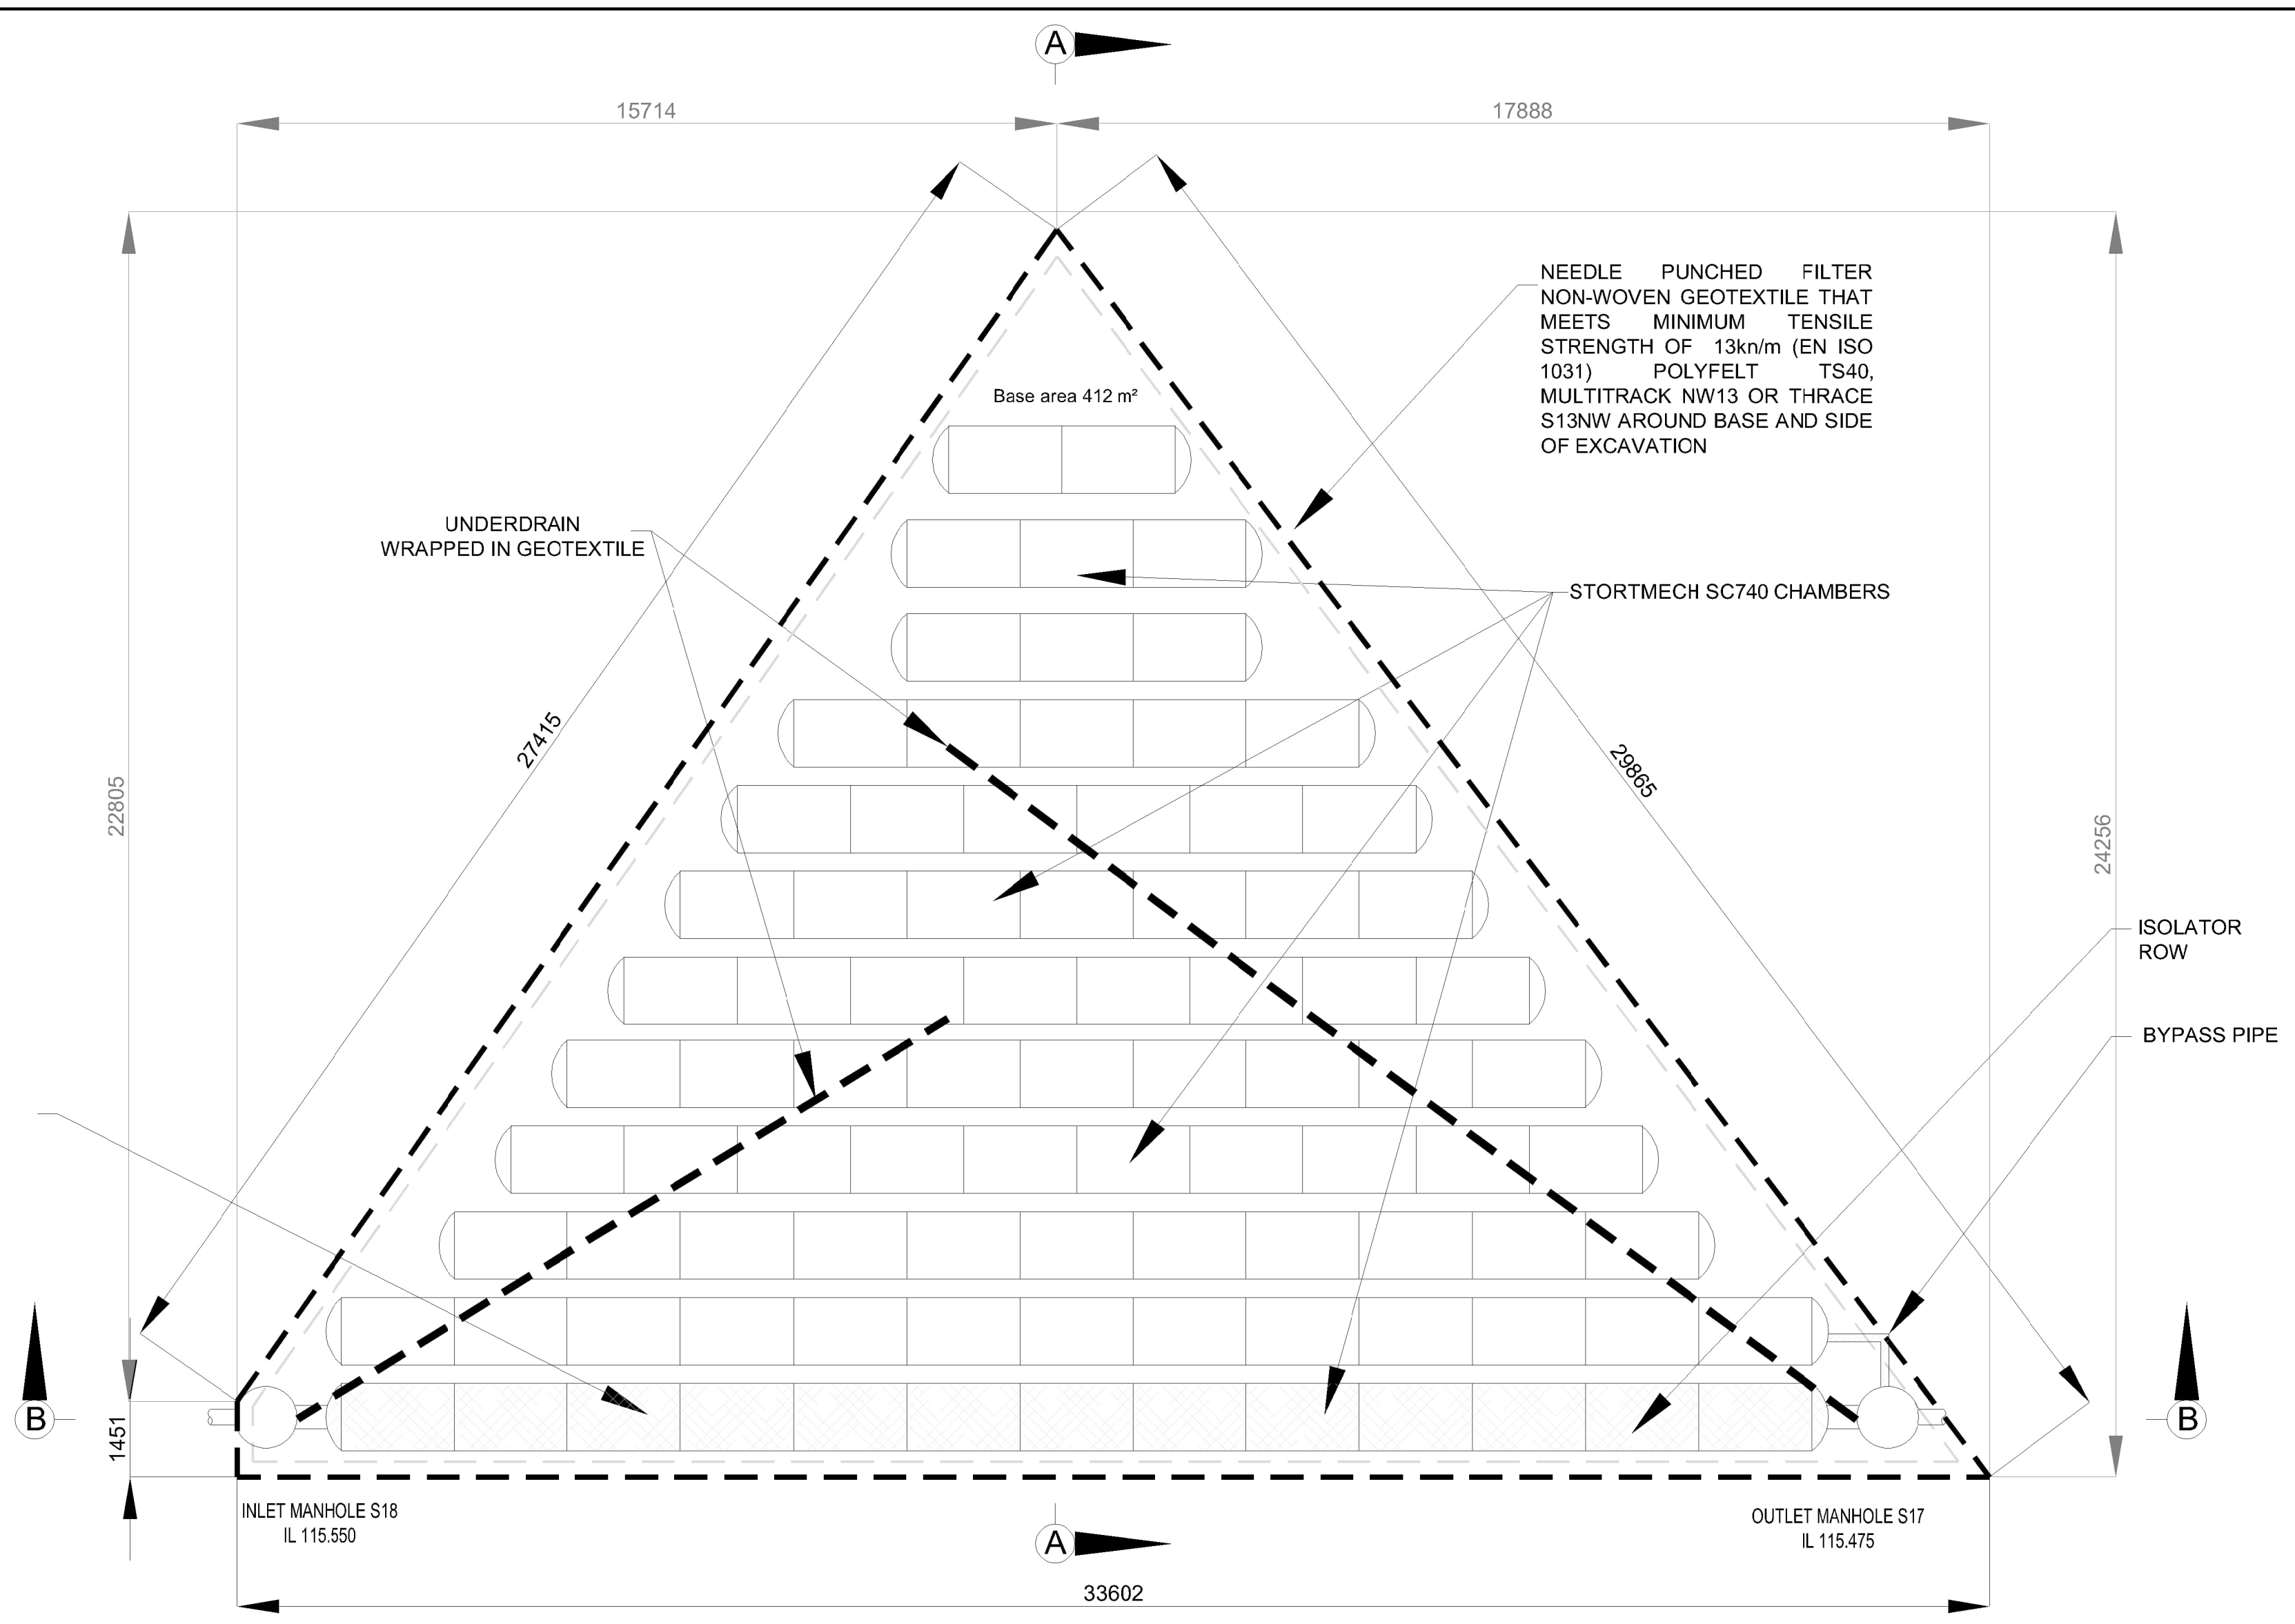


**PLAN - TANK ABC**  
SCALE @ A1: 1:100  
SCALE @ A3: 1:300

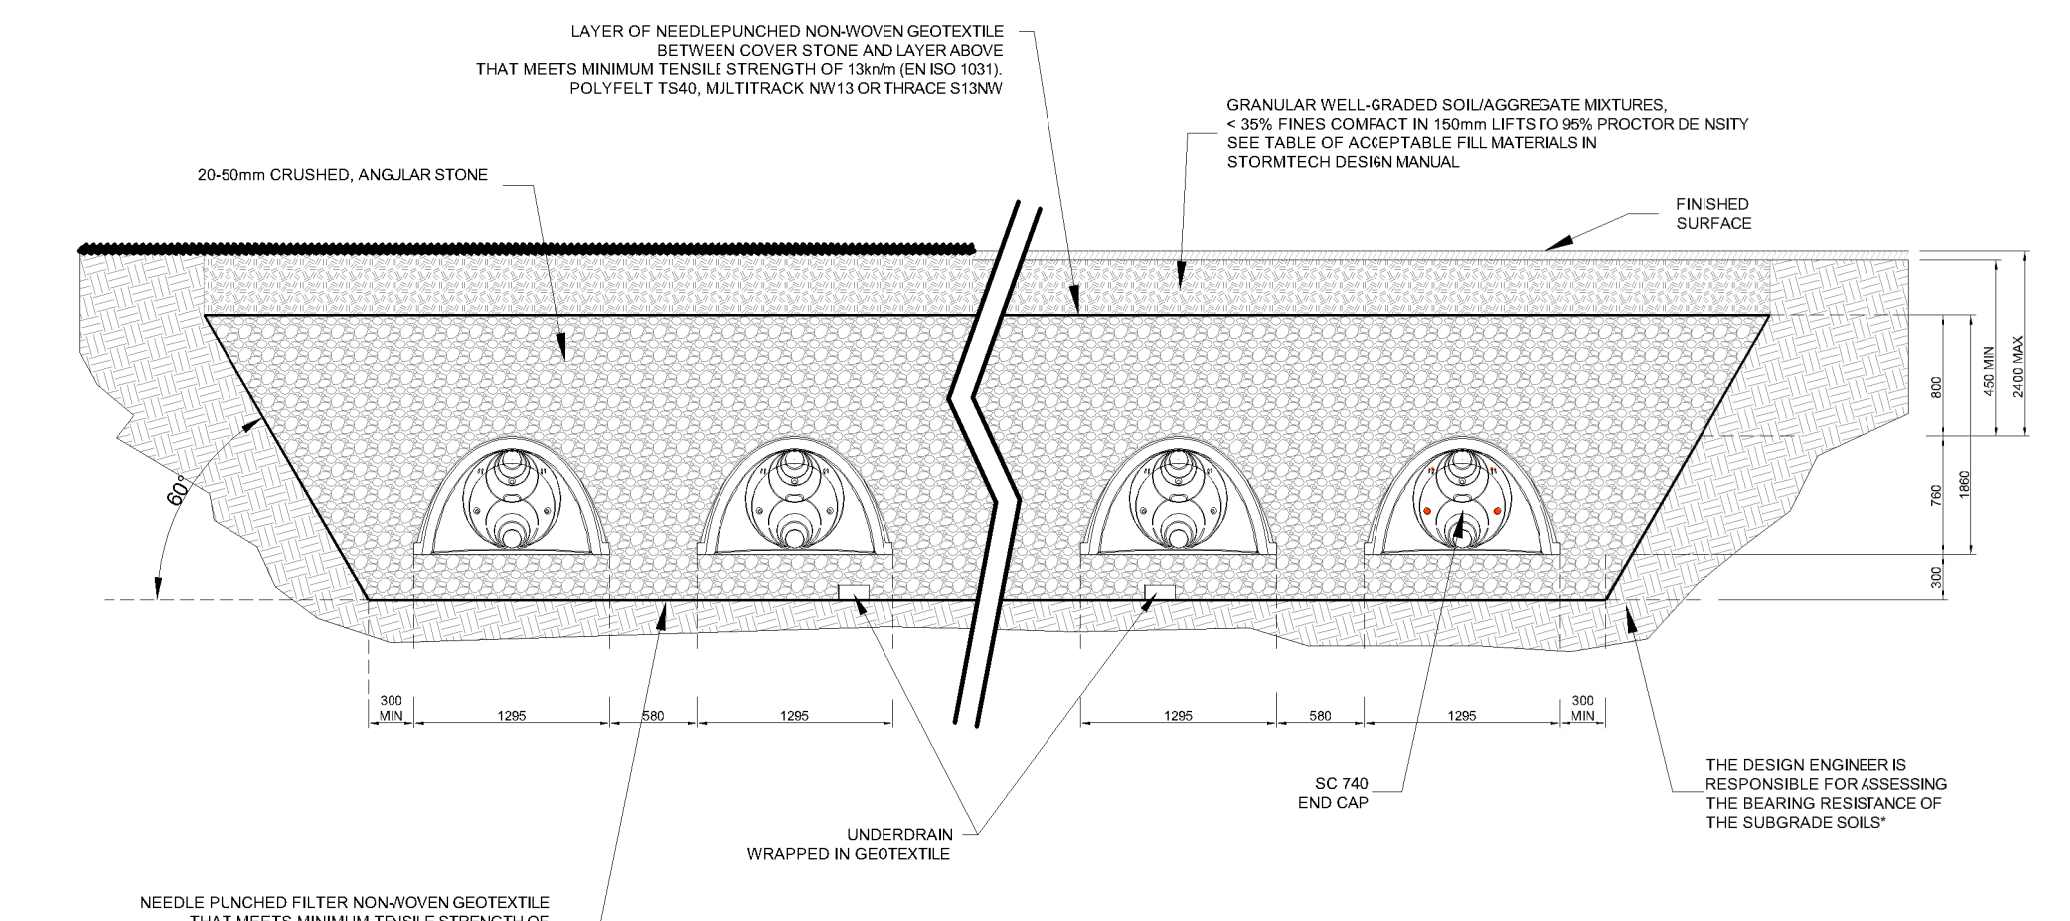


**SECTION A - TANK ABC**  
SCALE @ A1: 1:50  
SCALE @ A3: 1:100

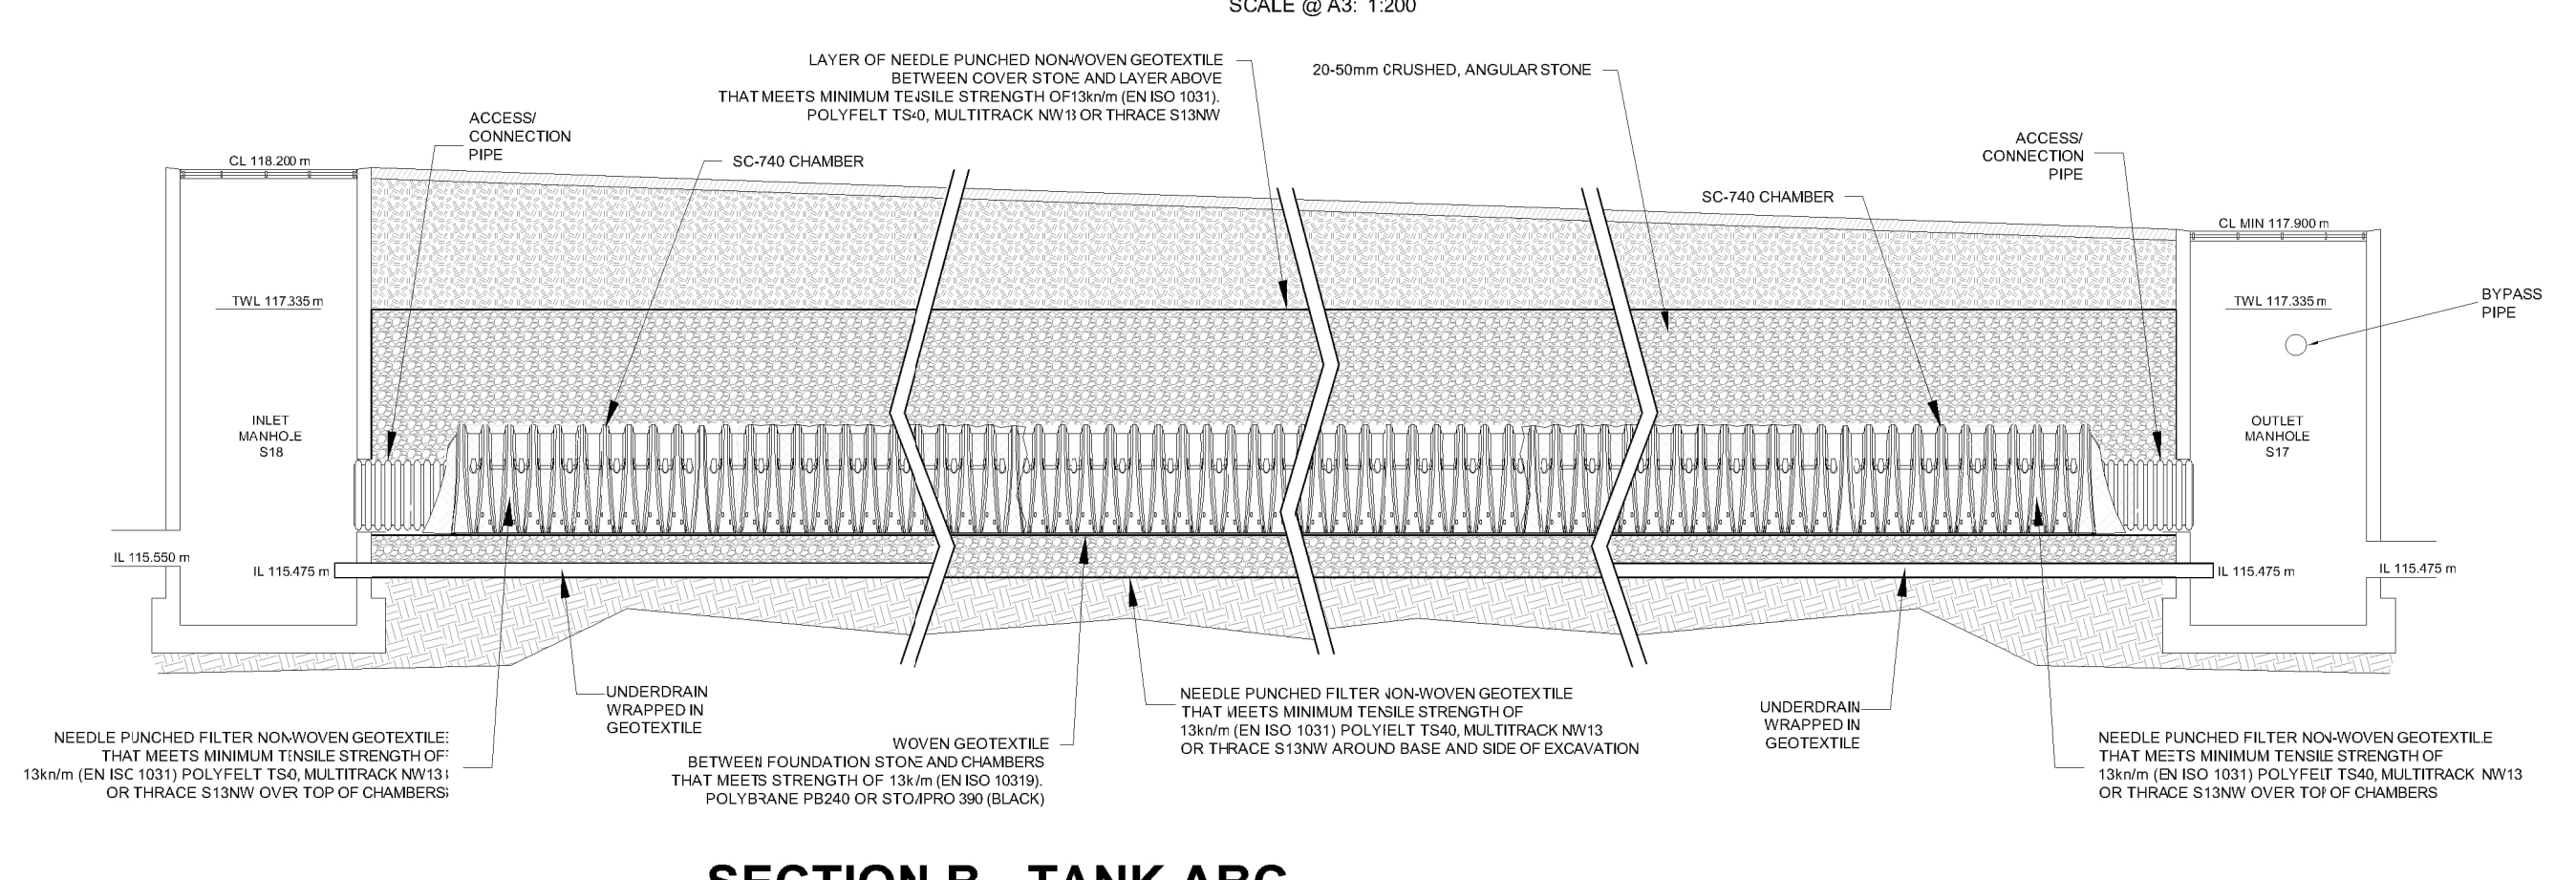


**SECTION B - TANK ABC**  
SCALE @ A1: 1:75  
SCALE @ A3: 1:100

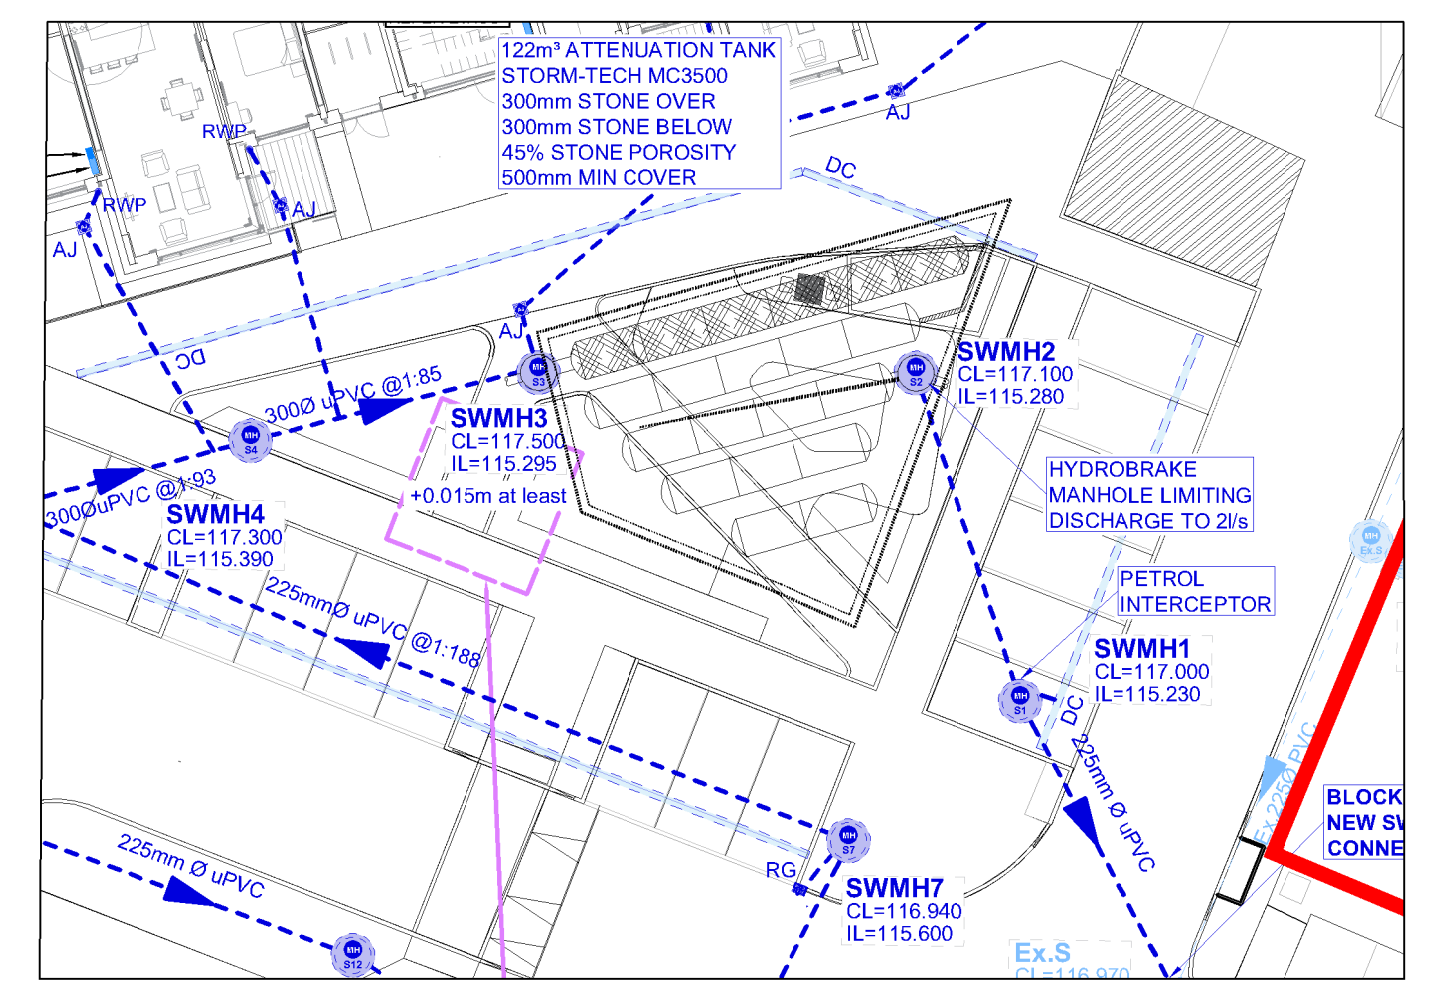


**PROPOSED SURFACE WATER DRAINAGE LAYOUT - TANK D**  
SCALE @ A1: 1:250  
SCALE @ A3: 1:500

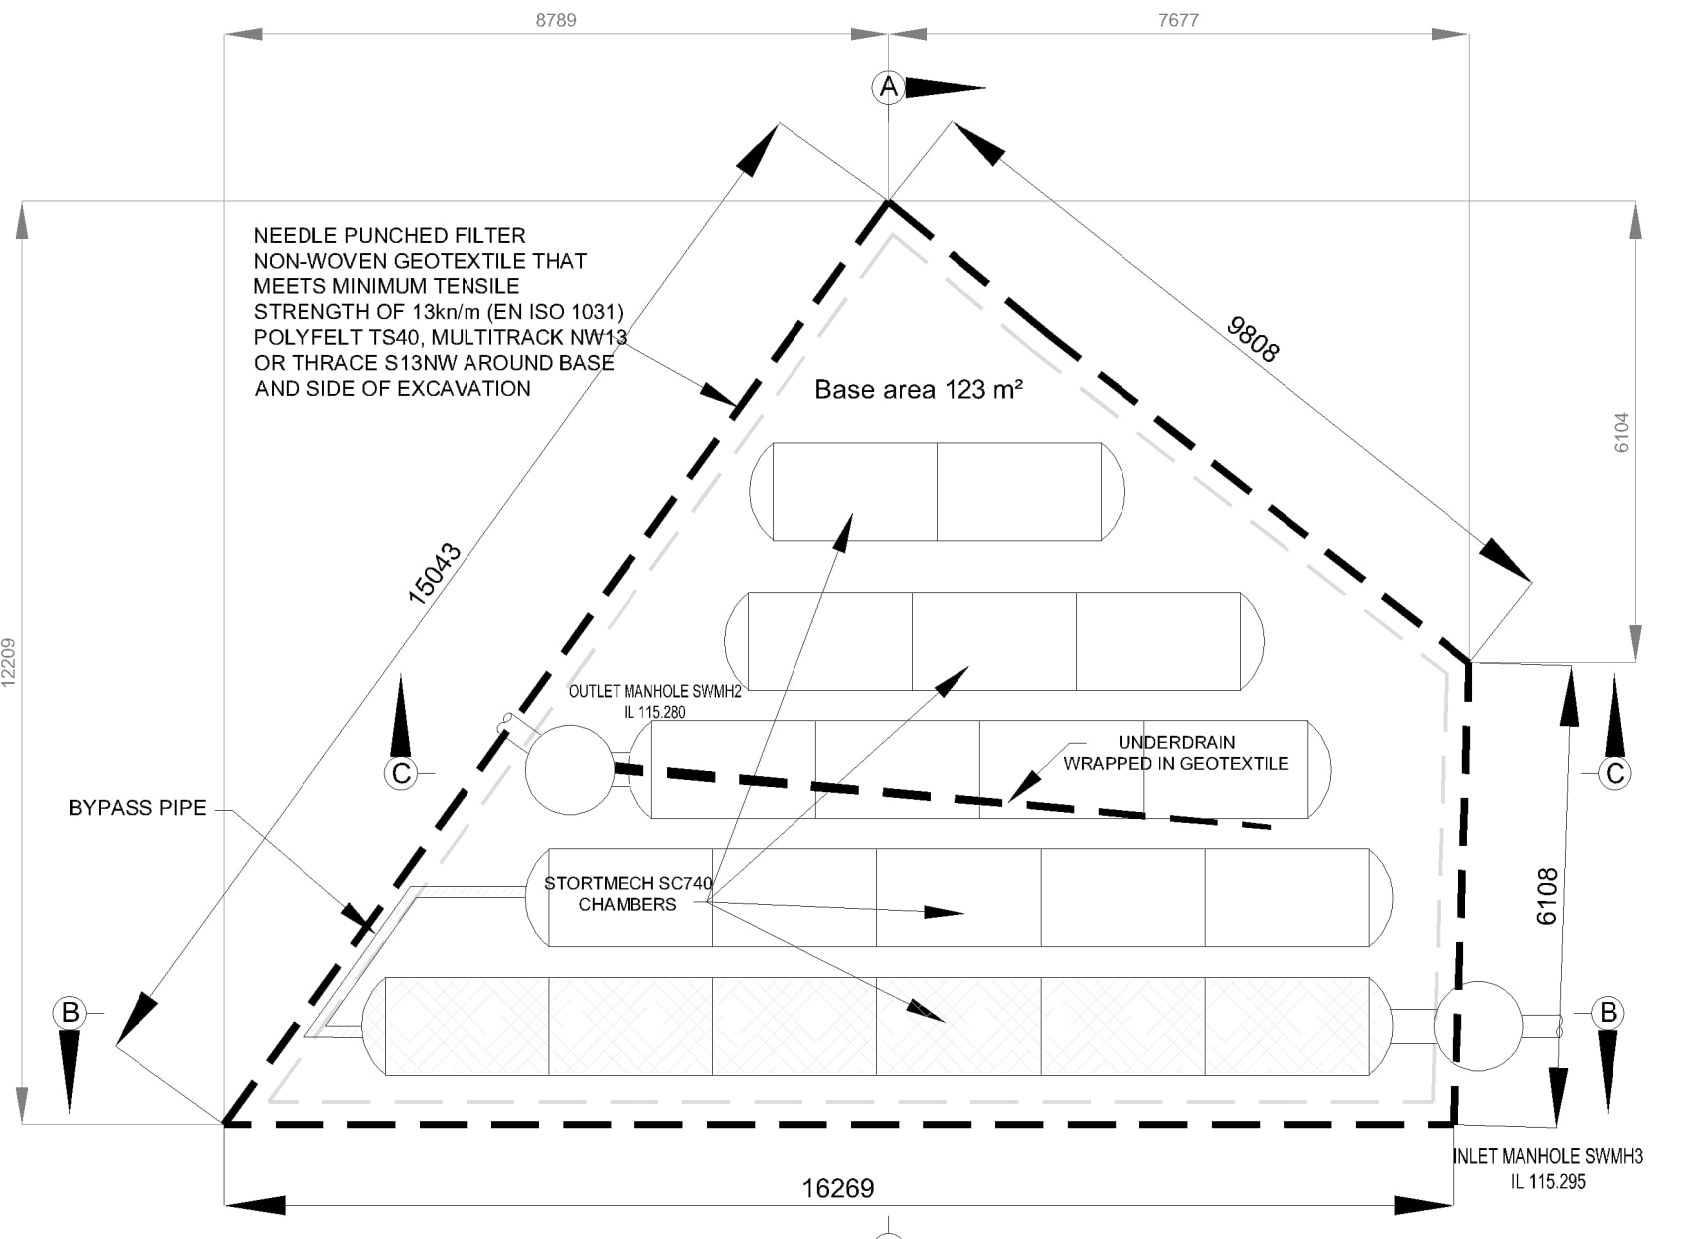

**PLAN - TANK D**  
SCALE @ A1: 1:100  
SCALE @ A3: 1:200

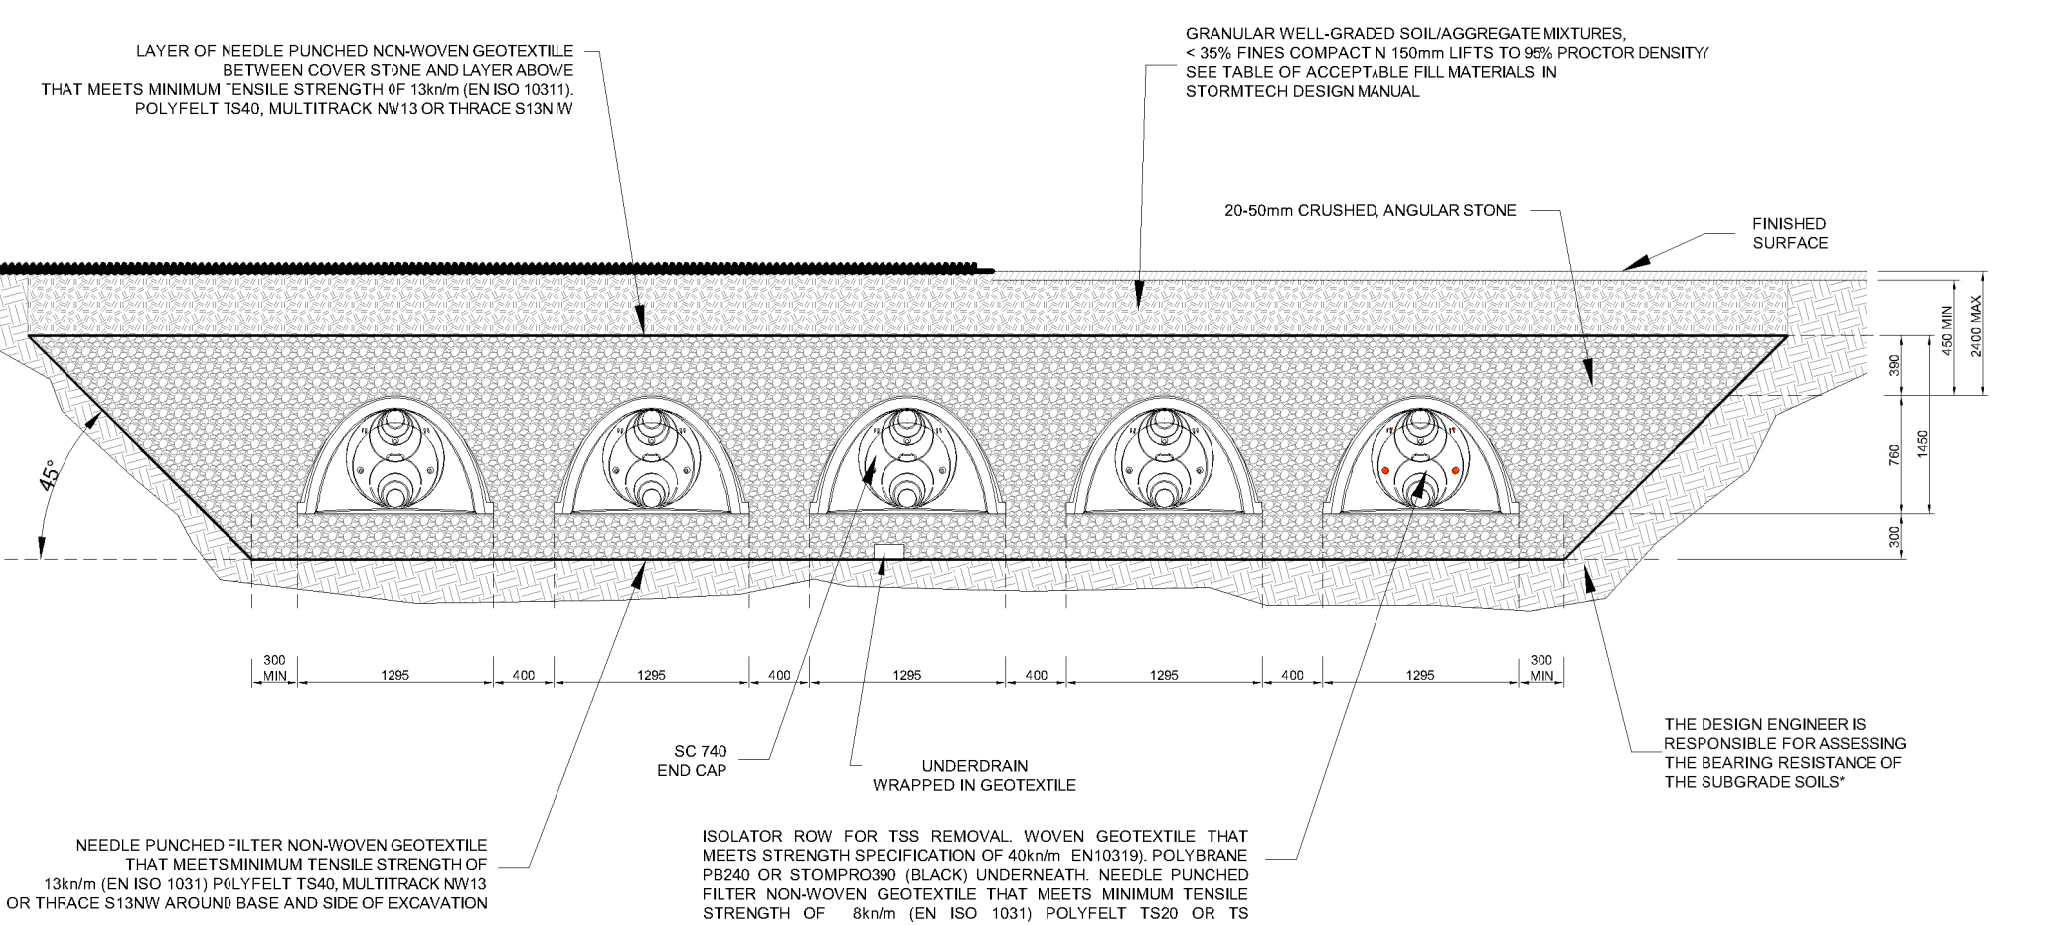

**SECTION A - TANK D**  
SCALE @ A1: 1:50  
SCALE @ A3: 1:100

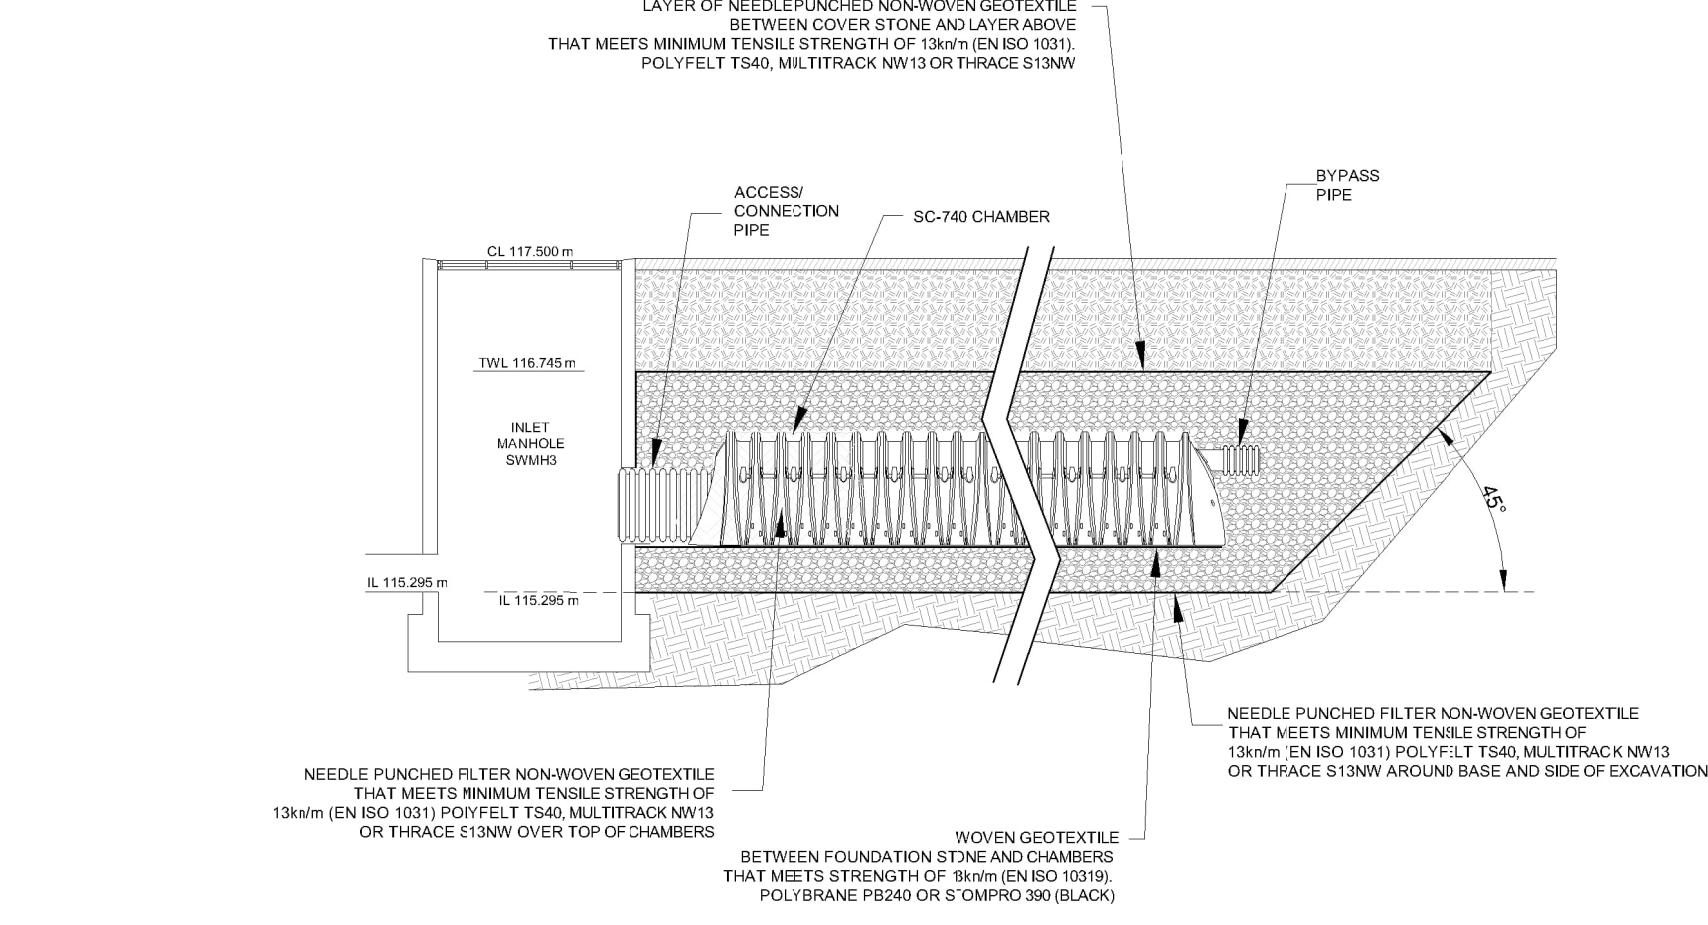

**SECTION B - TANK D**  
SCALE @ A1: 1:75  
SCALE @ A3: 1:100

PL1	19.03.24	ISSUED FOR PLANNING	AM
ISSUE	DATE	DESCRIPTION	BY
Project Engineer: B ON		Project Director: MH	
<b>PLANNING COMPLIANCE</b>			
<b>BM</b> Dublin Office: Sandhill House, 55-56 Lower Sandhill Street, Dublin 2, Ireland Tel: (01) 877 3350 Fax: (01) 877 3164 London Office: 5th Floor, Mill House, 8 Mill Street, London SE1 2SA, United Kingdom Tel: (02044) 293759 3030 Consulting Engineers, Civil, Structural, Project Management, etc. Email: info@bm.co.uk Web: www.bm.co.uk			
<b>ACEI</b> The Institution of Structural Engineers Chartered Institution of Engineers			
<b>CLIENT</b> ARDSTONE HOMES LIMITED			
<b>PROJECT TITLE</b> CARRIGMORE WOODS		<b>EM PROJECT No.</b> 21.226	
<b>REFERENCE</b>		<b>SUITABILITY</b> 80	
<b>DRAWING TITLE</b> CATCHMENT A AND B ATTENUATION TANK DETAILS			
<b>DRAWING REFERENCE</b> CWD-BMCE-ZZ-ZZ-DR-C-1039		<b>STATUS</b> PL1	